

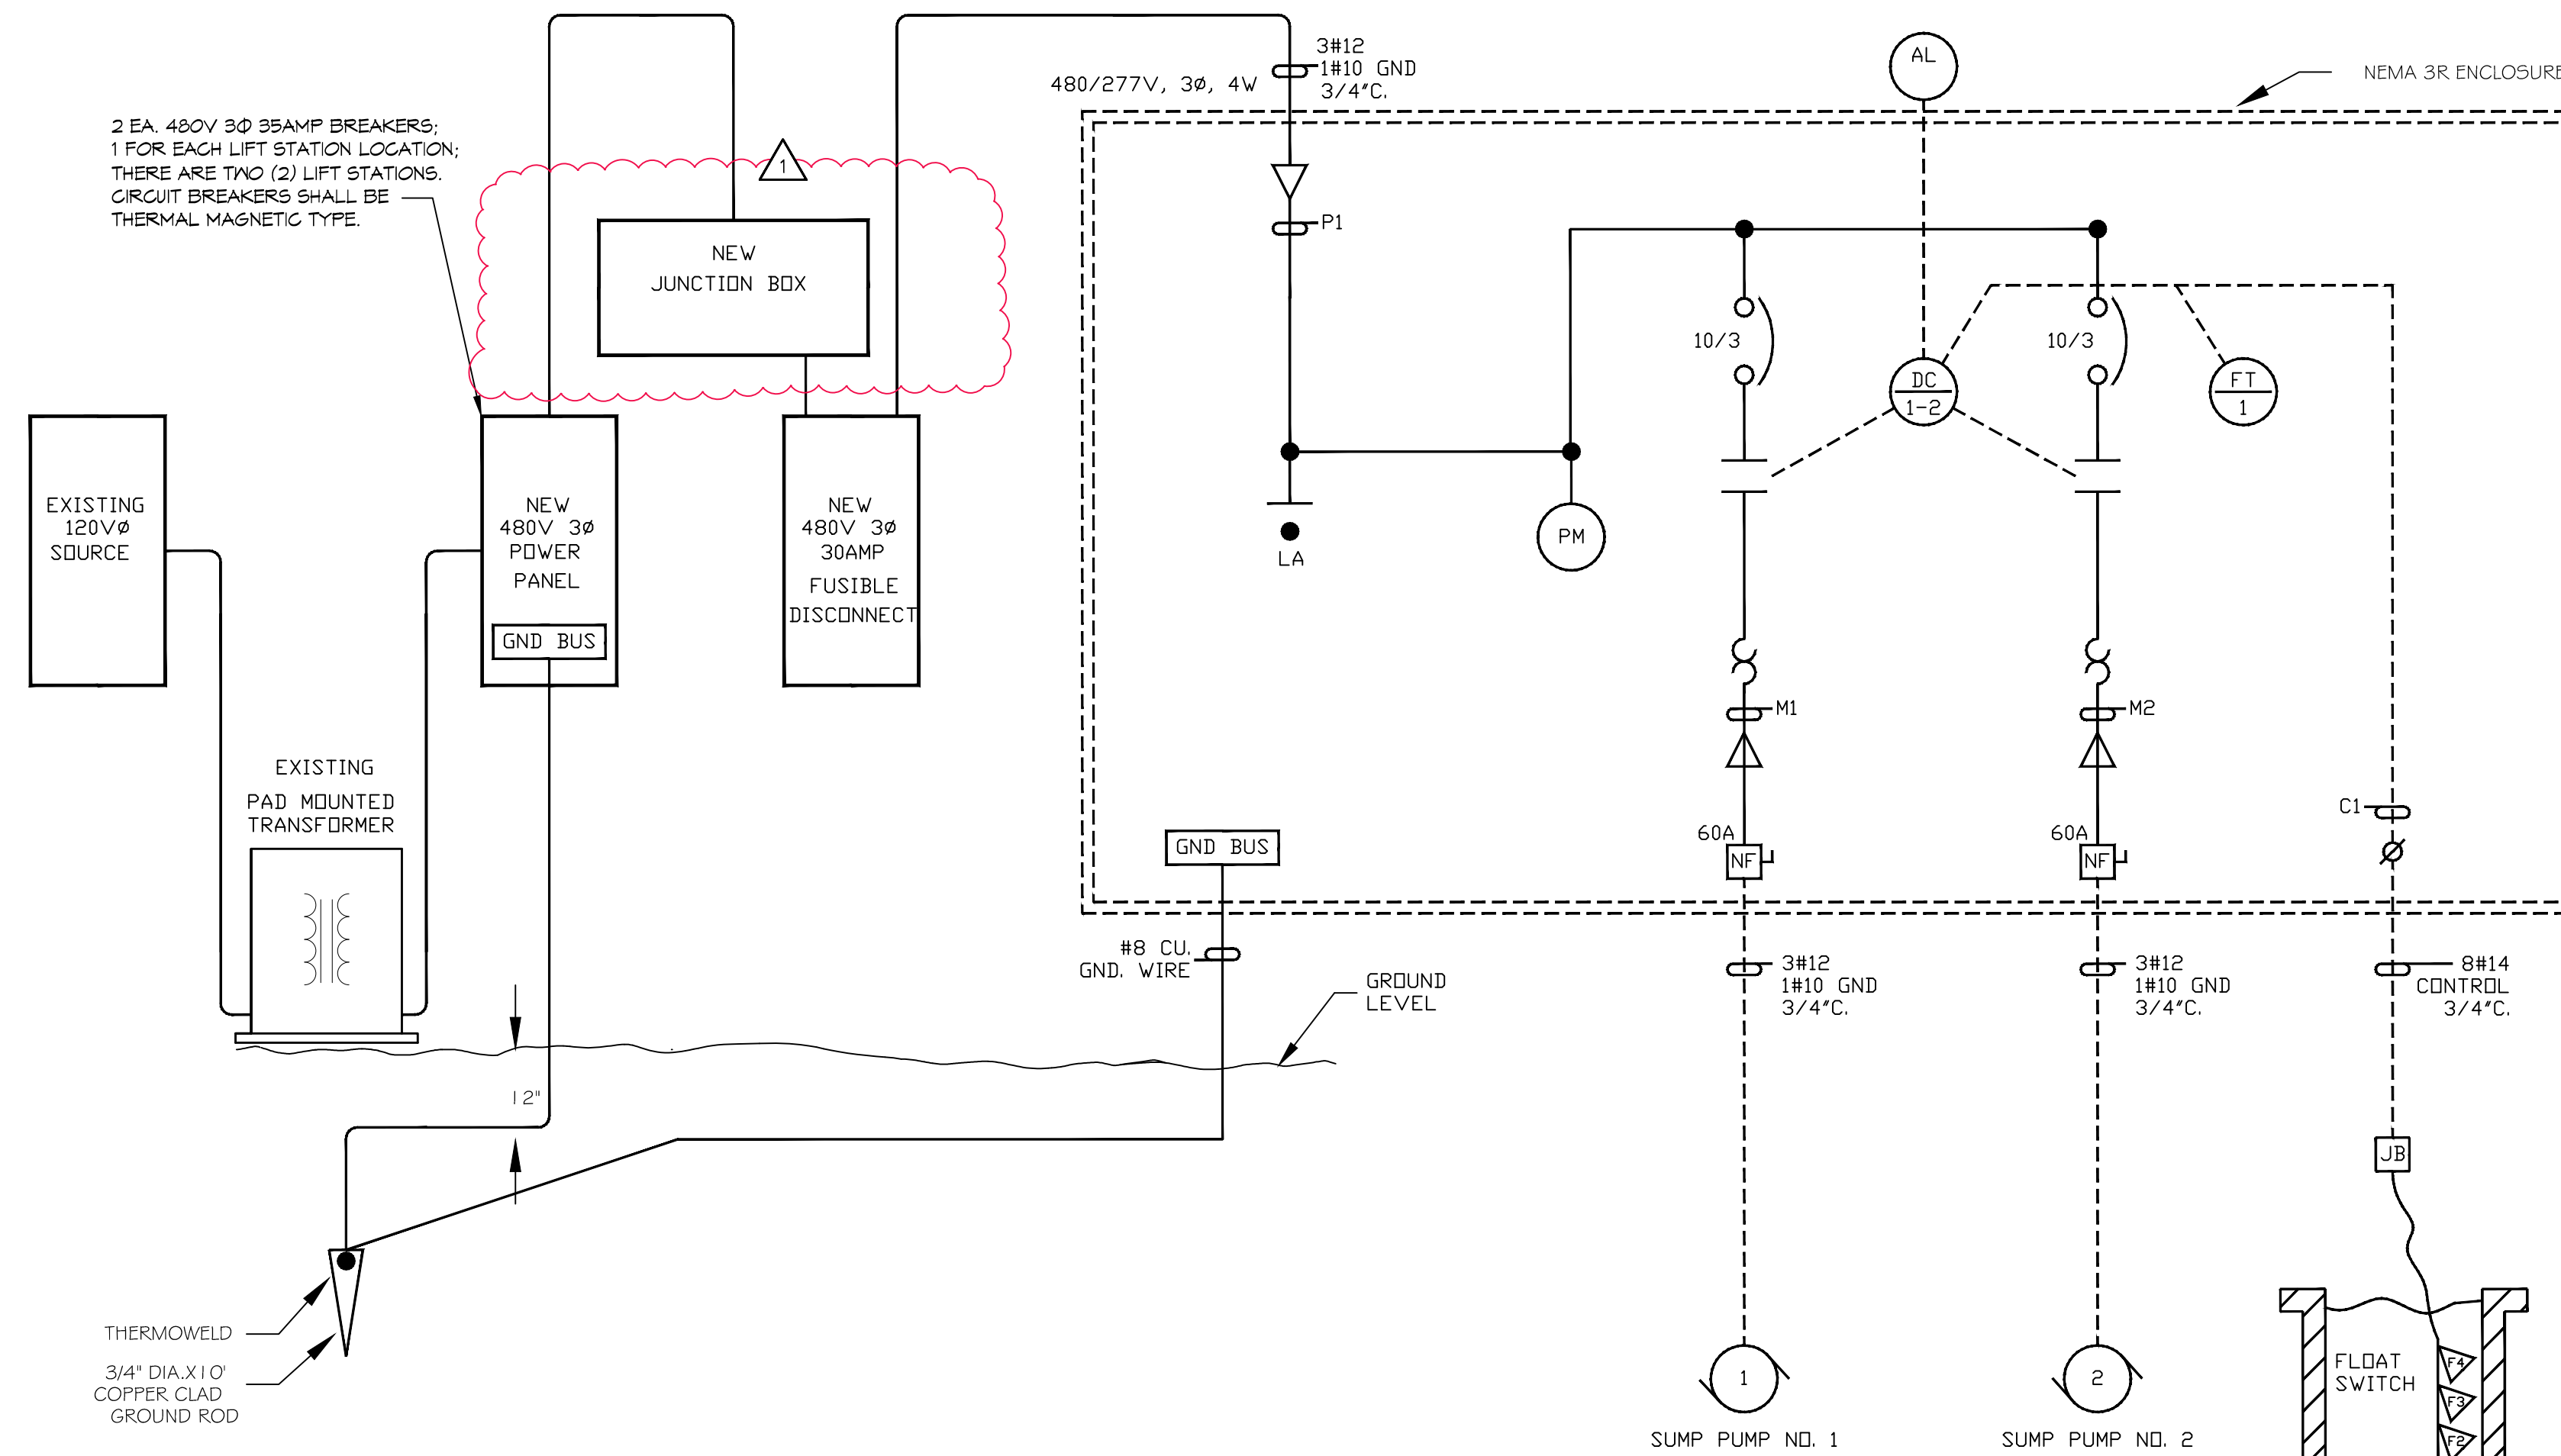


NEMA 3R ENCLOSURE
(24"H x 24"W x 8"D)
OR OTHER APPROVED PRE-DESIGNED
MANUFACTURE ENCLOSURE

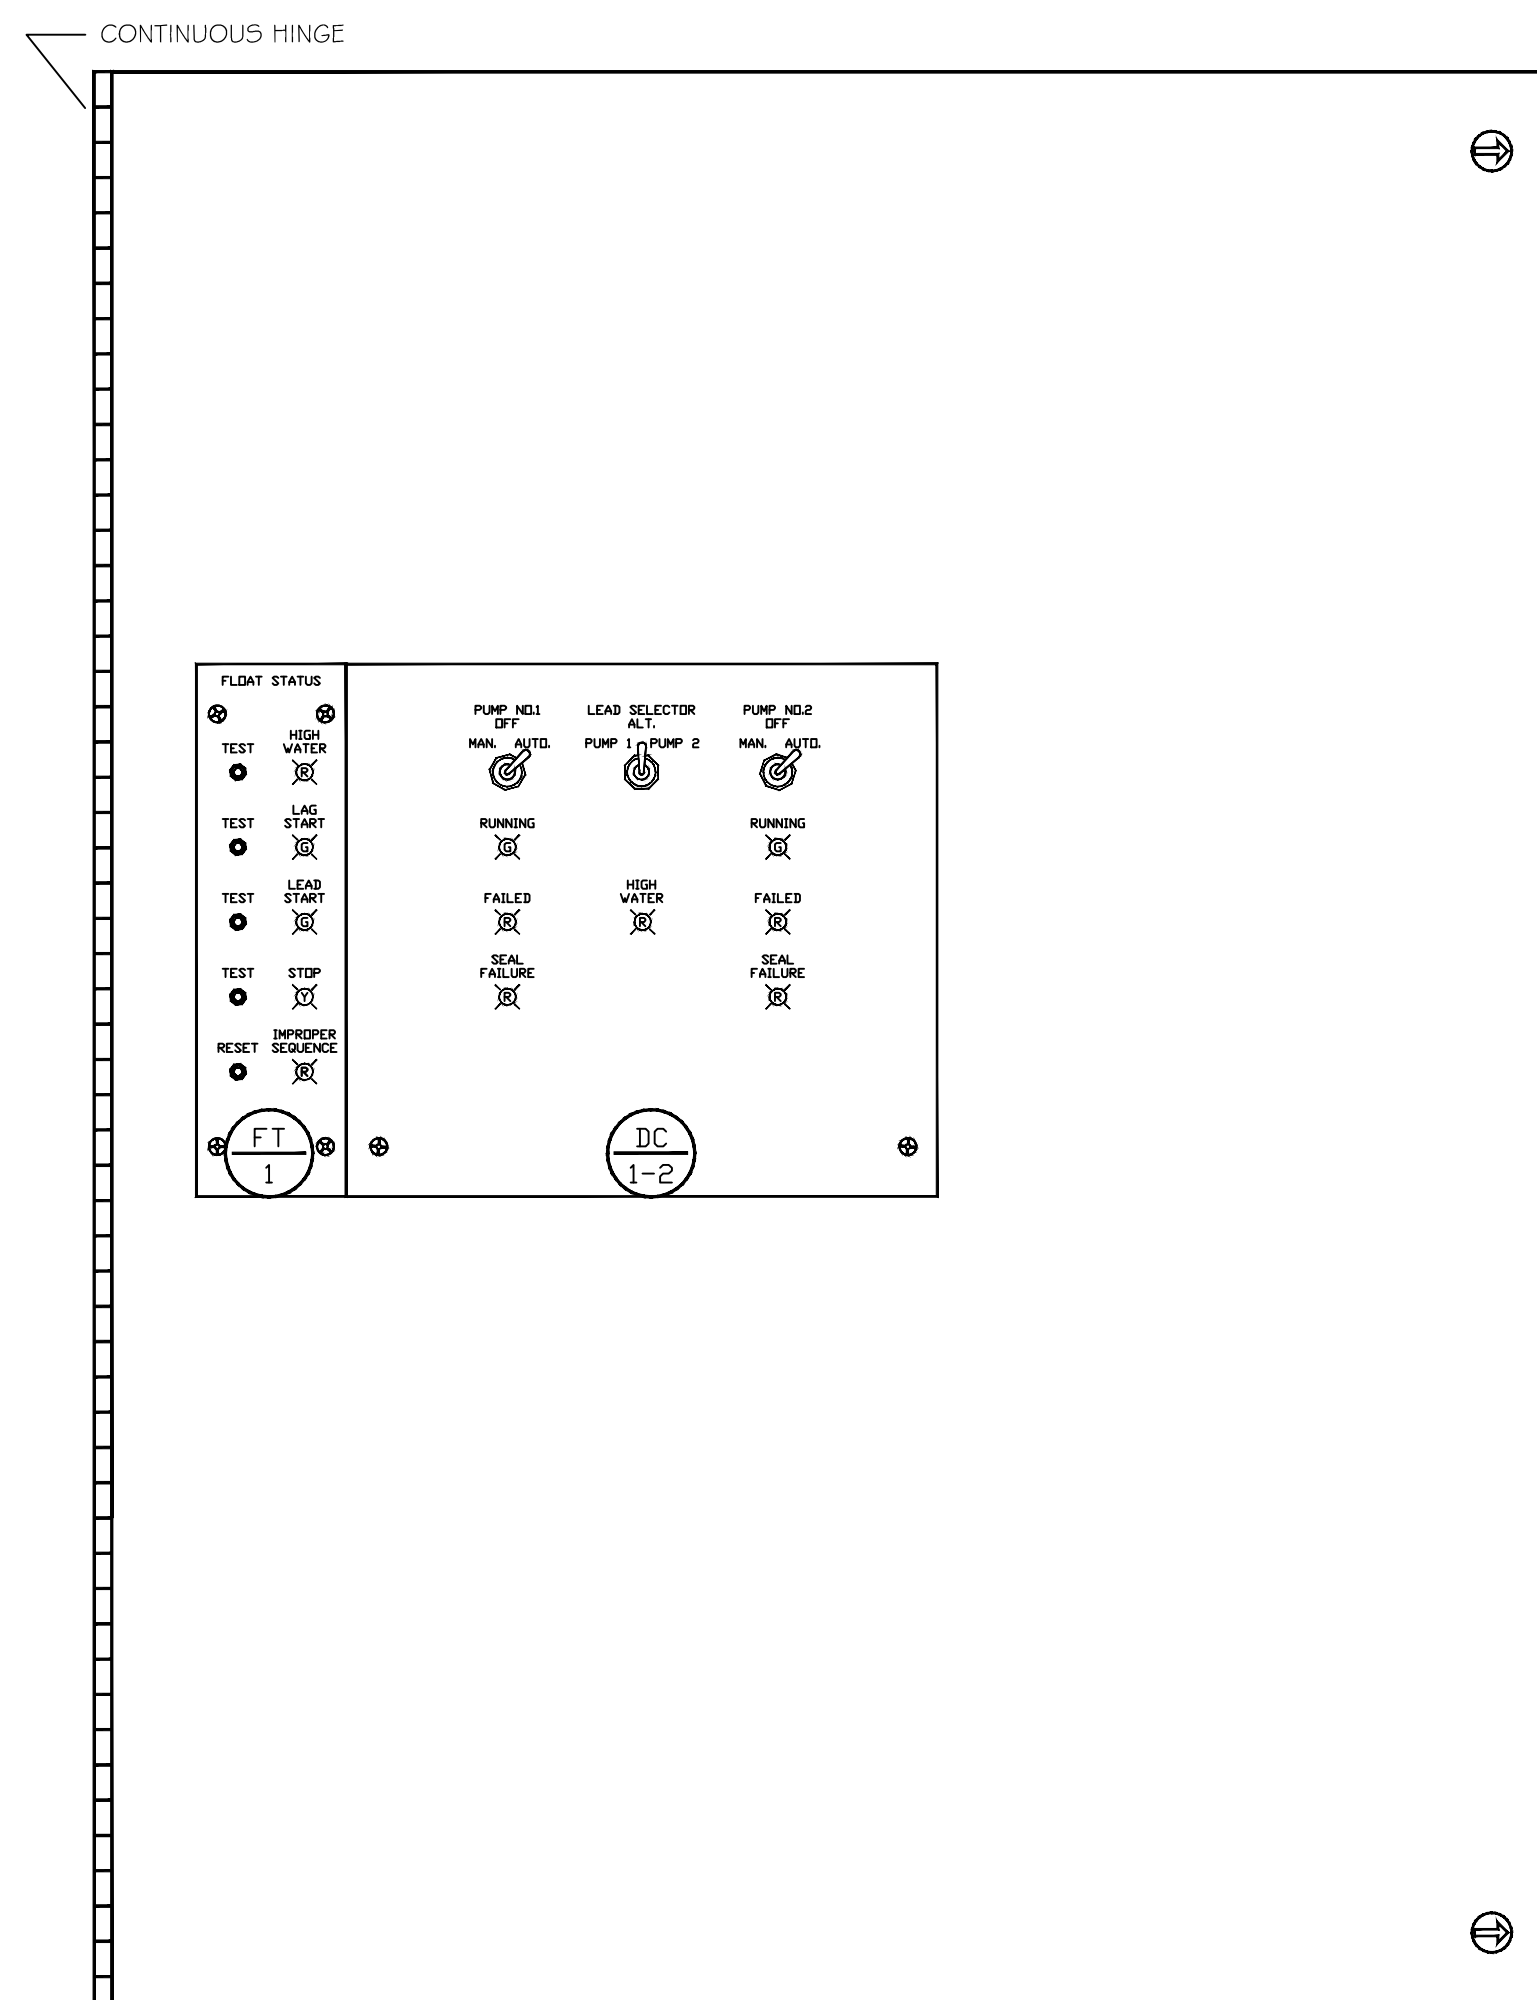

CONTROL PANEL
DEADFRONT DETAIL

LIFT STATION CONTROL PANEL
ONE LINE POWER DIAGRAM AND
PROCESS AND INSTRUMENTATION DIAGRAM (P&ID)

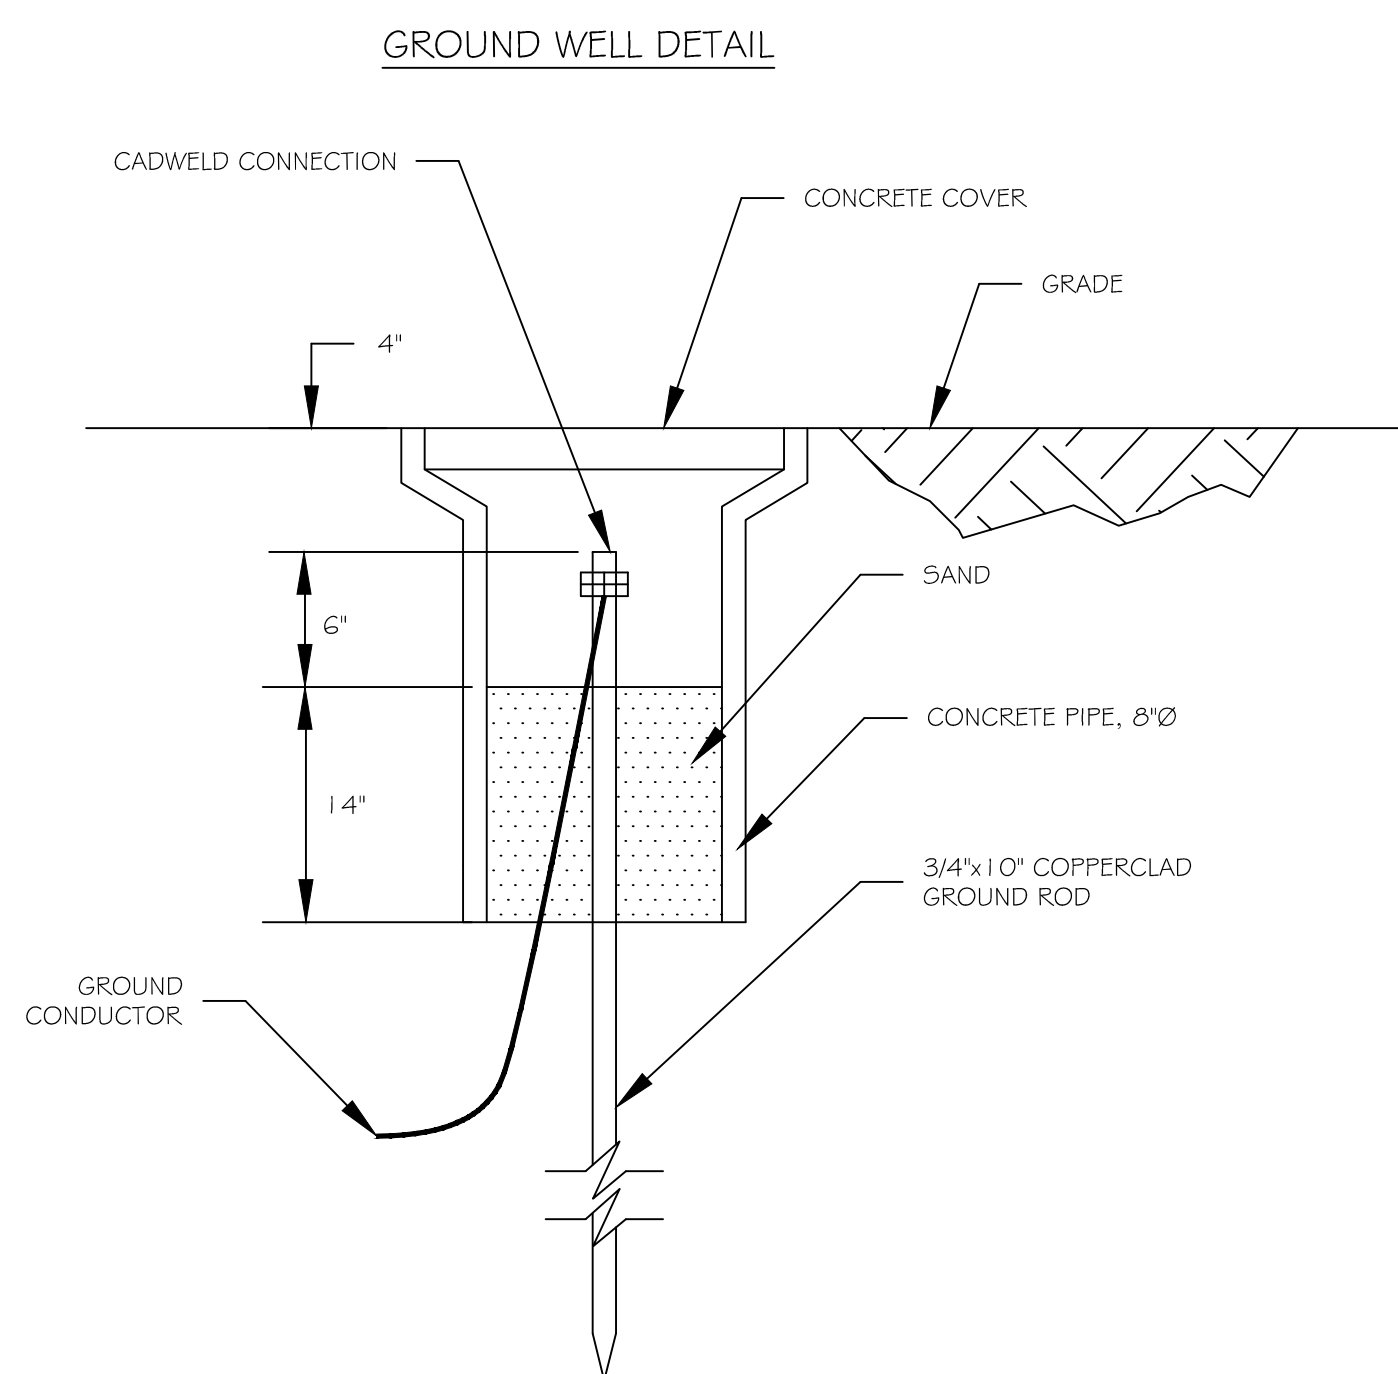

REVISIONS	DATE
1	3/14/2018
2	

DESCRIPTION

1 REVISED PLAN FOR 35AMP BRK @ MDP AND ADD JUNCTION BOX

SEAL:

SEWER SYSTEM RENOVATION;
PROJECT NUMBERS: 08-403-11-01 PART 1 &
08-403-04B-01, PART 20 & 01-10T-06B-11, PART 17
BRIDGE CITY CENTER FOR YOUTH

3225 RIVERS ROAD
BRIDGE CITY, LA 70094
JOB No: 2156 DATE: 10/7/2016
DRAWN BY: CHECKED BY:

SHEET TITLE:
**LIFT STATION
CONTROLS**

DRAWING NUMBER:

E-2