


**GENERAL RCP NOTES**

1. CEILING HEIGHT TO BE 9'-0" AFF UNLESS NOTED OTHERWISE.
2. CEILING MATERIAL SHALL BE PAINTED GWB UNLESS NOTED OTHERWISE. REFER TO FINISH SCHEDULE FOR MORE DETAILED INFORMATION RE GWB TYPE.
3. TYPES SHALL HAVE COARSE GRANULAR FILL.
4. REFER TO ELECTRICAL LIGHTING PLAN FOR LIGHT FIXTURE TYPE.

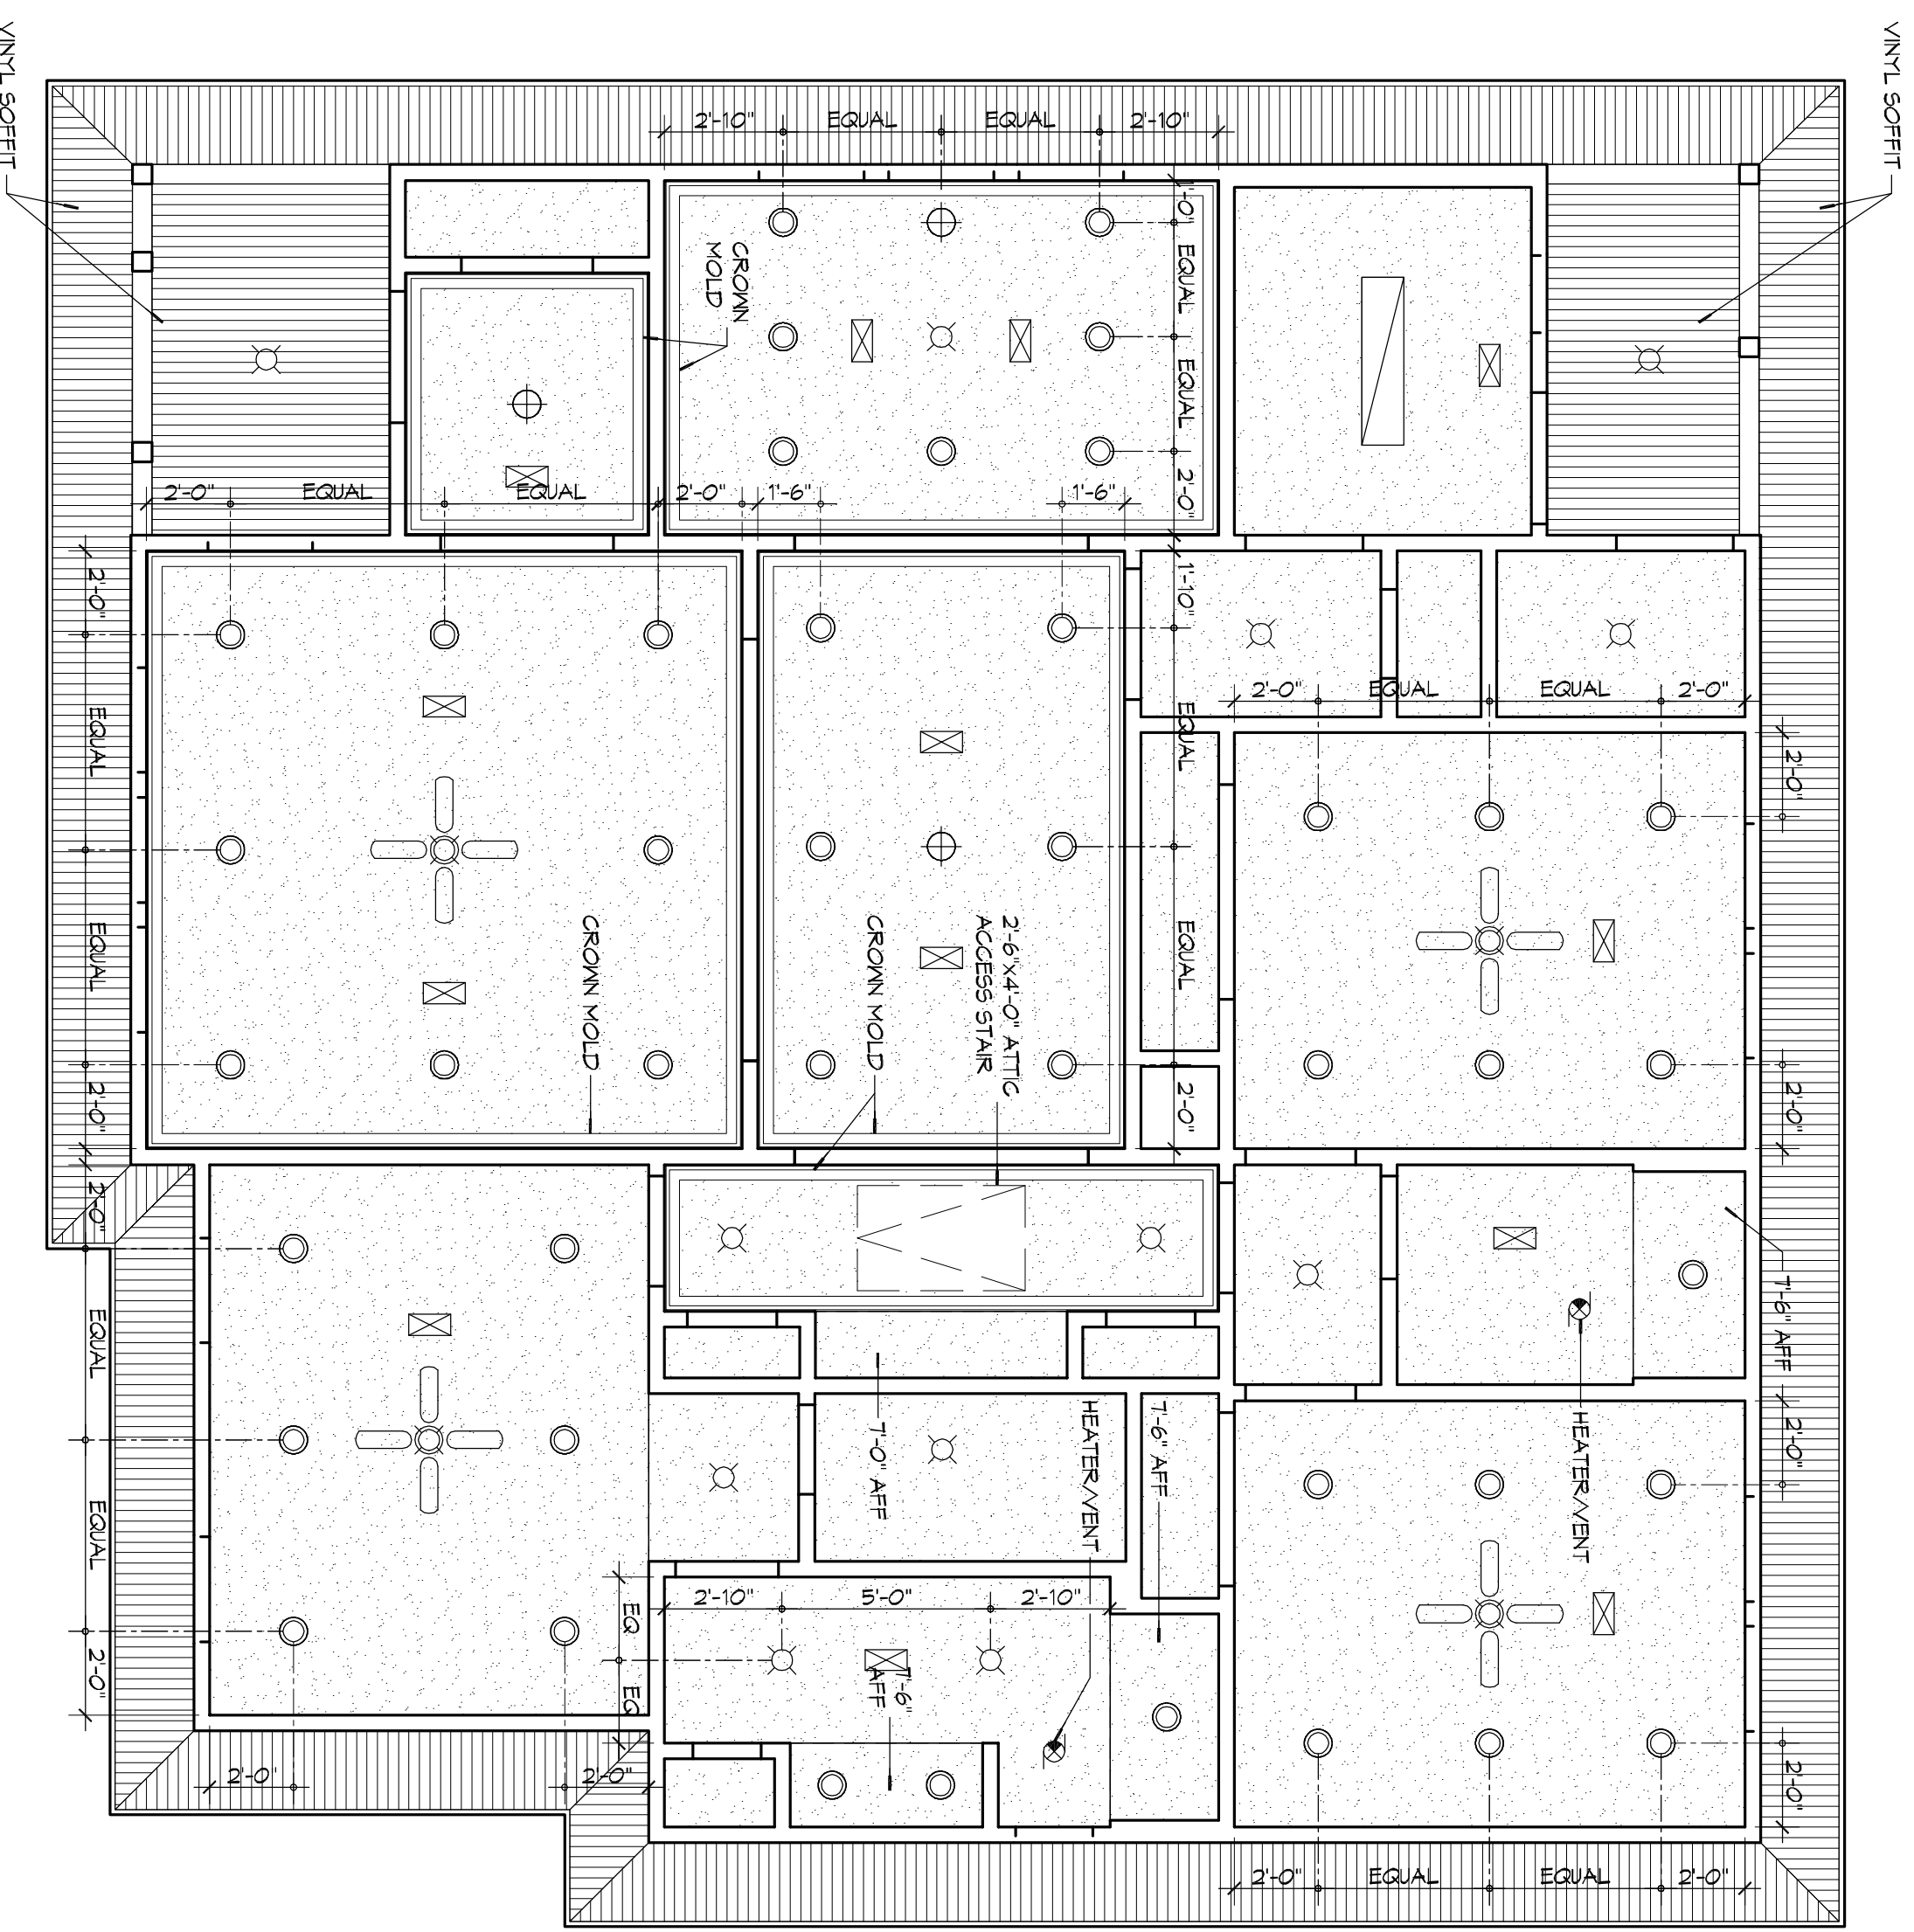

**REFLECTED CEILING PLAN**

SCALE: 1/4" = 1'-0"

**DAMMON**  
ENGINEERING, INC.  
*Architects & Engineers*

Chief Architect: Kevin J. Kinchen, NCARB  
Chief Engineer: Brian Mistich, PE  
554 Old Spanish Trail  
Slidell, LA 70458  
www.dammonengineering.com  
info@dammonengineering.com  
PH: 985.649.5832  
F: 985.641.5950

REVISIONS		DATE
#	DESCRIPTION	

**50% SUBMITTAL**  
**NOT FOR CONSTRUCTION**

**NEW COMMANDER'S POST**

SLIDELL, LA

JOB No: 2210    DATE: JULY 22, 2014

DRAWN BY: KJK    CHECKED BY: KJK

The owner warrants and warrants that the design and construction of the project shall be in accordance with the applicable laws, codes, and regulations. The design and construction shall be in accordance with the applicable laws, codes, and regulations. The design and construction shall be in accordance with the applicable laws, codes, and regulations.

SHEET TITLE:  
REFLECTED CEILING PLAN

DRAWING NUMBER:

**A4**