

FILE NAME: C:\Users\dammon\Documents\Drawings\2014\2014-06-11\2014-06-11-11-11-11.dwg

HVAC SYSTEM REPLACEMENT
 STATE POLICE TROOP L HEADQUARTERS
 2600 N CAUSEWAY BLVD
 MANDEVILLE, LOUISIANA
 PROJECT NO.: 01-107-06B-11, F.01003807
 STATE ID: S00814 SITE CODE: 1-52-004




TROOP L

STATE OF LOUISIANA
 JOHN BEL EDWARDS
 GOVERNOR

DIVISION OF ADMINISTRATION
 JAY DARDENNE
 COMMISSIONER OF ADMINISTRATION

OFFICE OF FACILITY PLANNING AND CONTROL
 MARK MOSES
 DIRECTOR

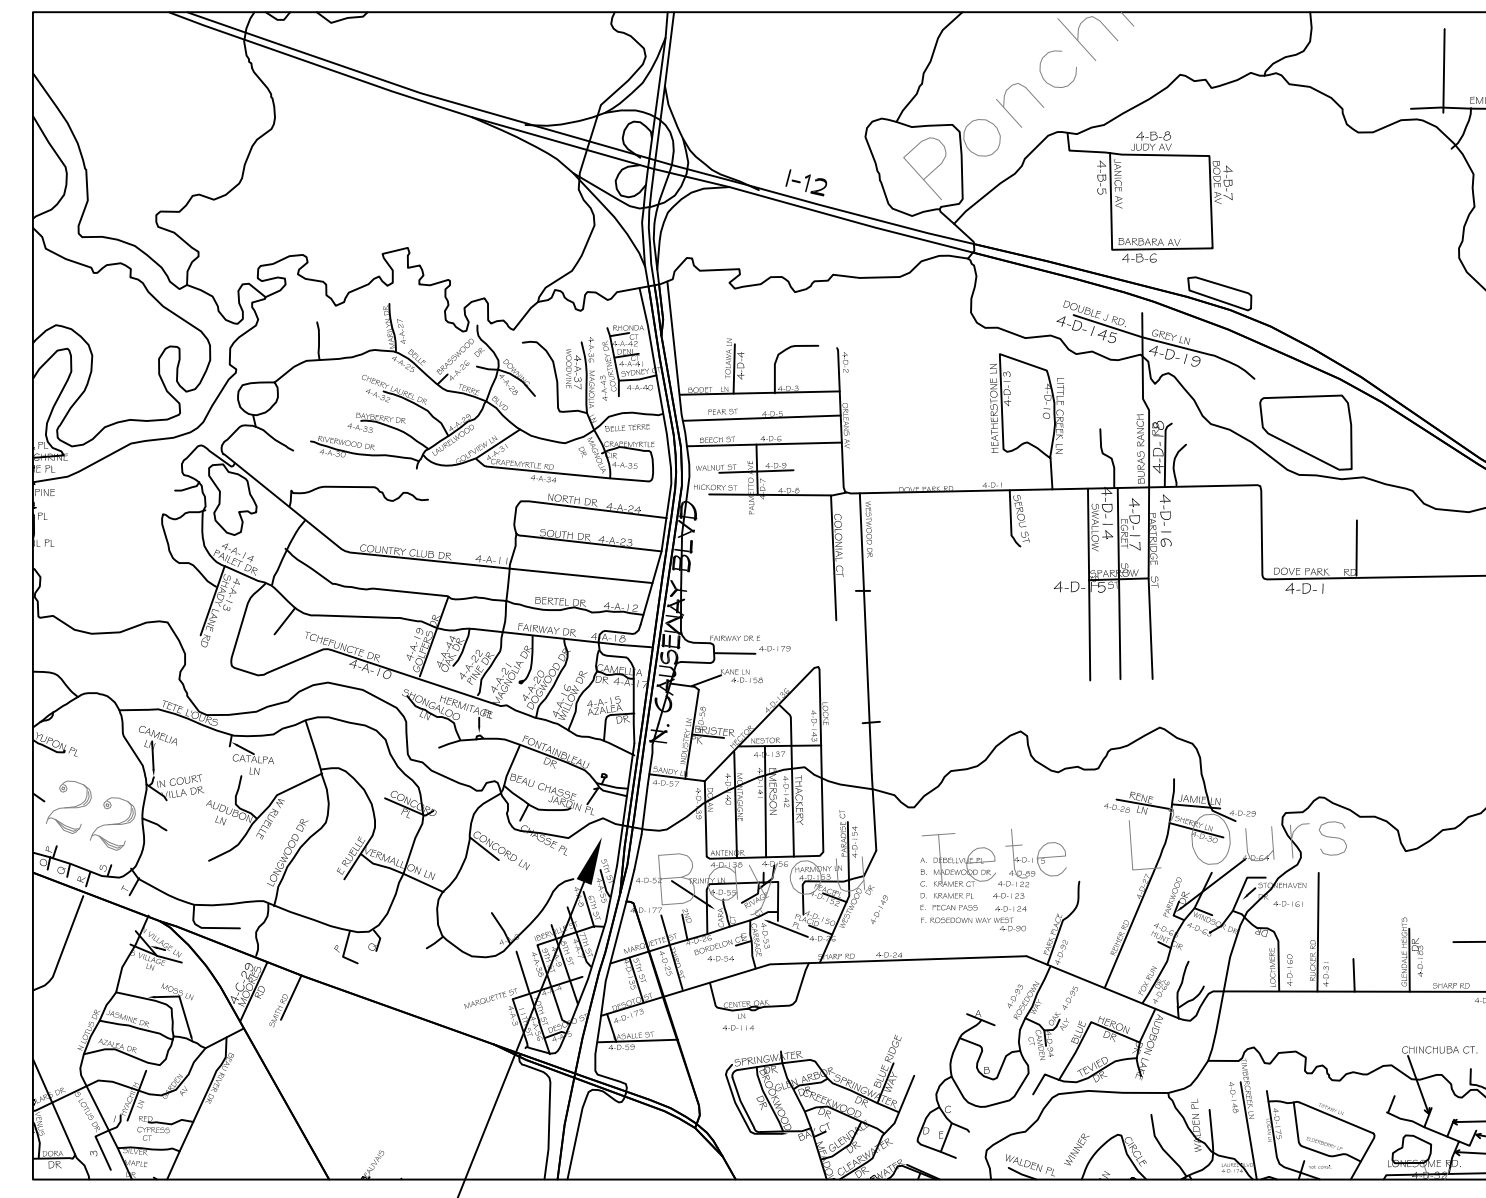

AREA OF WORK
 VICINITY MAP
 N.T.S.

INDEX OF DRAWINGS			
SHT#	DWG#	DRAWING NAME	REVISED
1	CS	COVERSHEET	
2	D101	MECHANICAL DEMO PLAN	
3	M101	MECHANICAL ZONES PLAN	
4	M102	MECHANICAL PLAN	
5	M102A	MECHANICAL PLAN WEST	
6	M102B	MECHANICAL PLAN EAST	
7	M102C	MECHANICAL DETAILS	
8	M103	HVAC DETAILS	
9	M104	HVAC CONTROL SCHEMATIC	
10	E101	ELECTRICAL PLAN	

DAMMON
 ENGINEERING, INC.
 LOUISIANA & MISSISSIPPI

Chief Engineer: Brian Misch, PE
 1000 Old Spicewood Trail
 Slidell, LA 70688
 www.dammonengineering.com
 info@dammoneng.com
 PH: 855.649.5822

#	DESCRIPTION	DATE

SEAL:

HVAC SYSTEM REPLACEMENT
 PROJECT NO.: 01-107-06B-11, F.01003807
 STATE POLICE TROOP L
 HEADQUARTERS

2600 N CAUSEWAY BLVD, MANDEVILLE, LA 70471
 STATE ID: S00814 SITE CODE: 1-52-004
 JOB No: 2372 DATE: 7/25/2014
 DRAWN BY: BNM
 CHECKED BY: DFP

SHEET TITLE:
 COVER SHEET

DRAWING NUMBER:
CS

SHEET No: 1 of 10