


- LEGEND**
- ⊕ NEW DUPLEX RECEPTACLE
  - ⊖ EXHAUST FAN
  - ⬆ SECURITY ACCESS DOOR (SCANNER BY OTHERS)
  - ⊕ COMM & DATA
  - ⊕ COLUMN MOUNTED UTILITY
- NOTES**
- ALL NEW POWER PANELS ARE TO BE MOUNTED ON THE NORTH WALL OF THE MECHANICAL ROOMS.


**ACCESS CONTROL**  
 SINGLE DOOR WITH CARD READER,  
 MAGNETIC LOCK, REX, JUNCTION  
 BOX, DOOR CONTACT

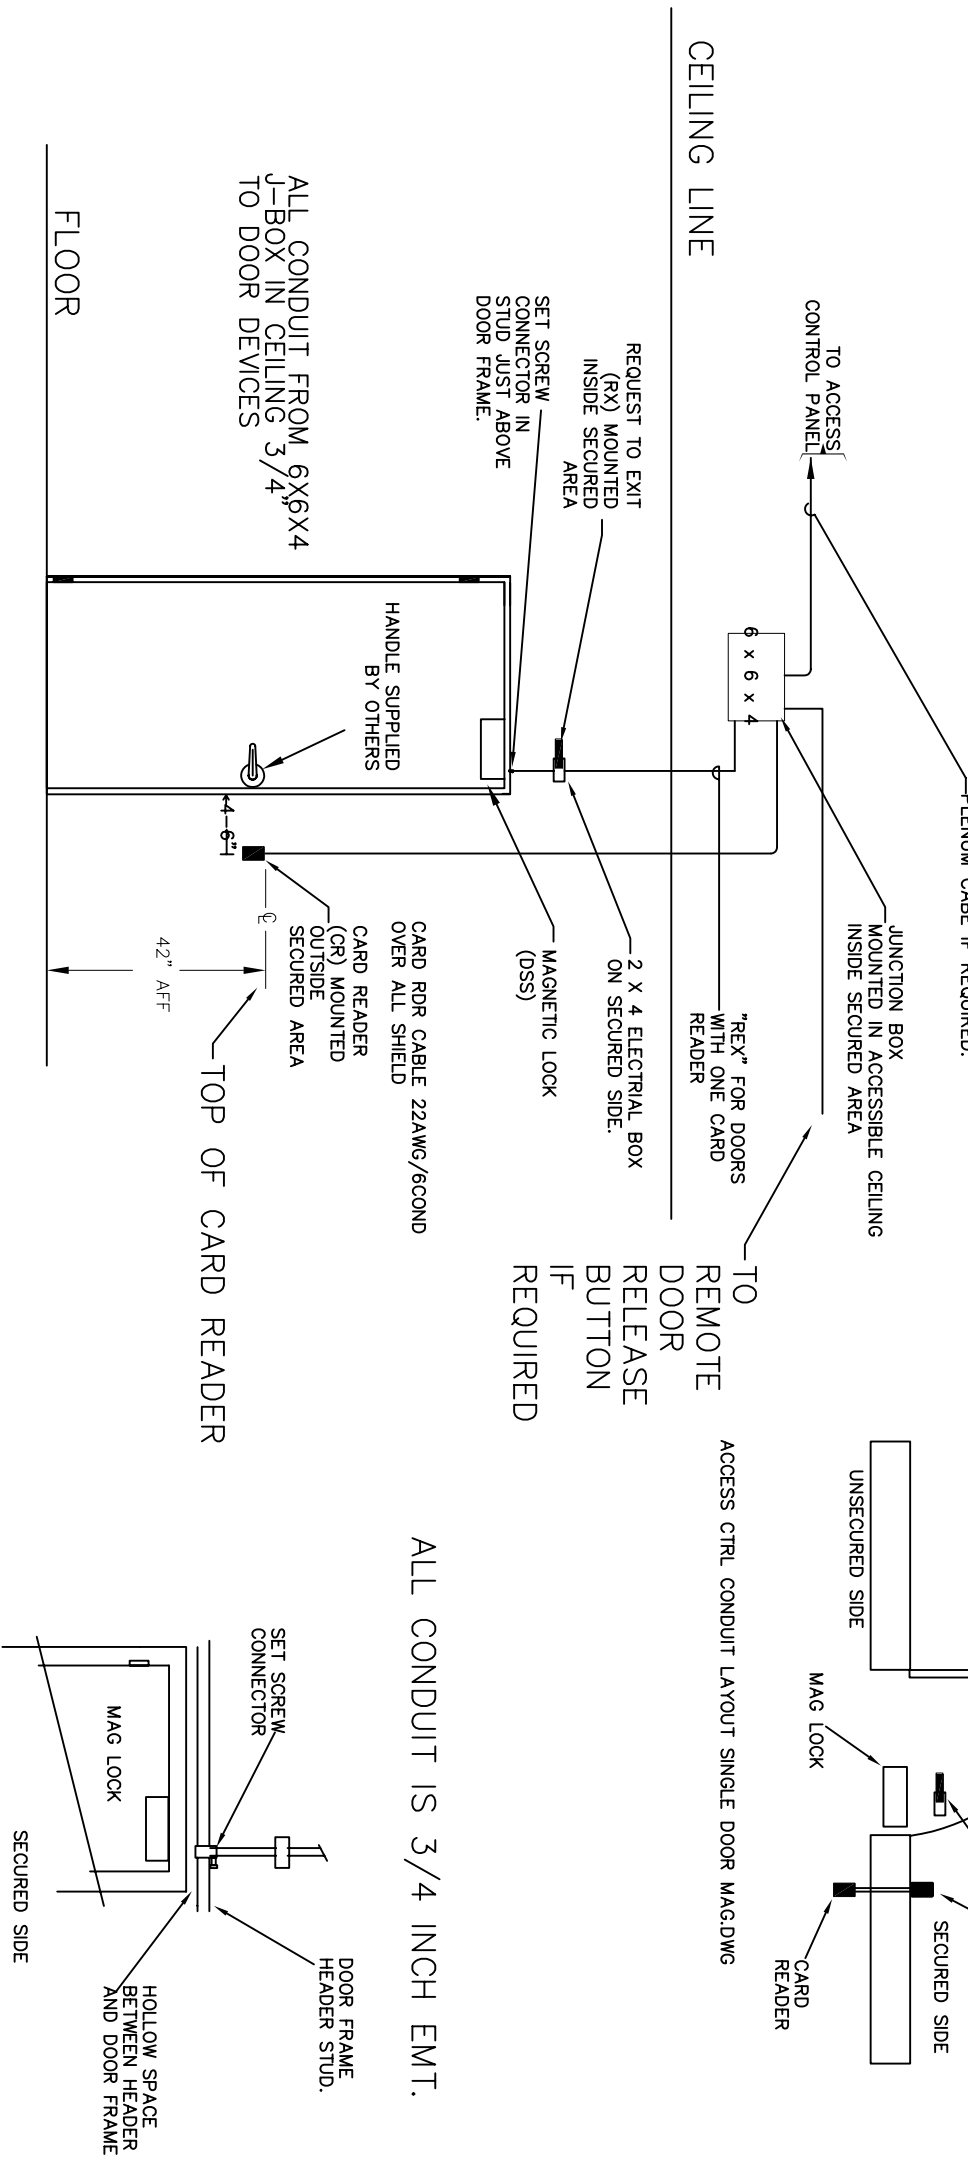

**THIRD FLOOR POWER PLAN**  
 SCALE: 3/16" = 1'-0"

- ⊕ - INDICATES AREAS CHANGED - 10/17/08
- ⊕ - INDICATES ITEMS CHANGED - 06/27/08
- ⊕ - INDICATES ITEMS CHANGED - 02/26/08
- ⊕ - INDICATES ITEMS CHANGED - 05/29/08
- A = ADDED

**COLUMN MOUNTED UTILITY DETAIL**  
 SCALE: NTS

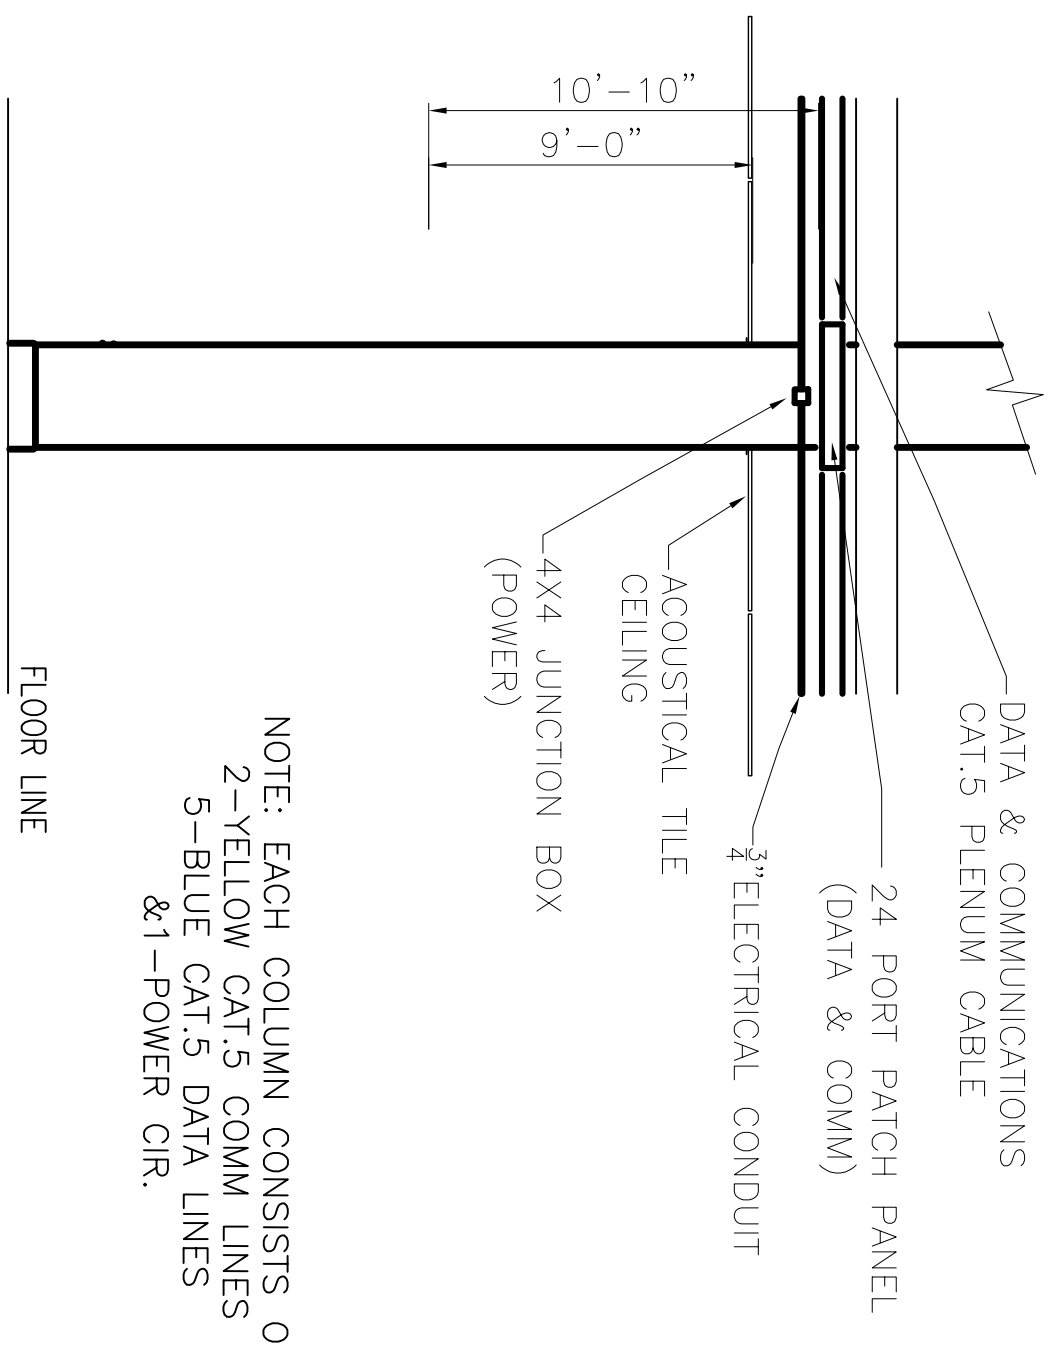

NOTE: EACH COLUMN CONSISTS OF  
 2-YELLOW CAT 5 COMM LINES  
 5-BLUE CAT 5 DATA LINES  
 & 1-POWER CIR.

RFP 6 REVISED: 10/17/08 ab  
 STAR HVAC REVISED: 05/29/08 ab  
 HVAC REVISED: 02/26/08 ab  
 HVAC REVISED: 11/05/07 ab  
 HVAC REVISED: 01/25/07

RFP #2 11-13-07

**3RD FLOOR POWER PLAN**  
 ST. TAMMANY PARISH ADMIN. COMPLEX  
 OLD SPANISH TRAIL  
 SLIDELL, LOUISIANA

RENOVATE OFFICE BUILDING  
**DAMMON ENGINEERING, INC.**  
 1095 FLORIDA AVENUE 985-649-5832 SLIDELL, LA. 70458  
 DAMMONENGINEERING.COM

SCALE: AS NOTED  
 FILE:  
 JOB NO. 1729  
 DATE: 1-8-07  
 SHEET  
**E3P**  
 OF