



- LEGEND**
- 2x4 FLUORESCENT FIXTURE
  - 2x4 FLUORESCENT FIXTURE W- BATTERY BACKUP
  - 2x4 FLUORESCENT FIXTURE W- BATTERY BACKUP
  - ⊞ SINGLE POLE SWITCH
  - ⊞ THREE-WAY SWITCH
  - ⊞ EXIT LIGHT FIXTURE (BATTERY BACK UP)
  - ▲ SECURITY ACCESS DOOR (SCANNER BY OTHERS)
  - ⊞ WALL MTD. FLUORESCENT FIXTURE W/ 90 MIN. BATTERY BACKUP

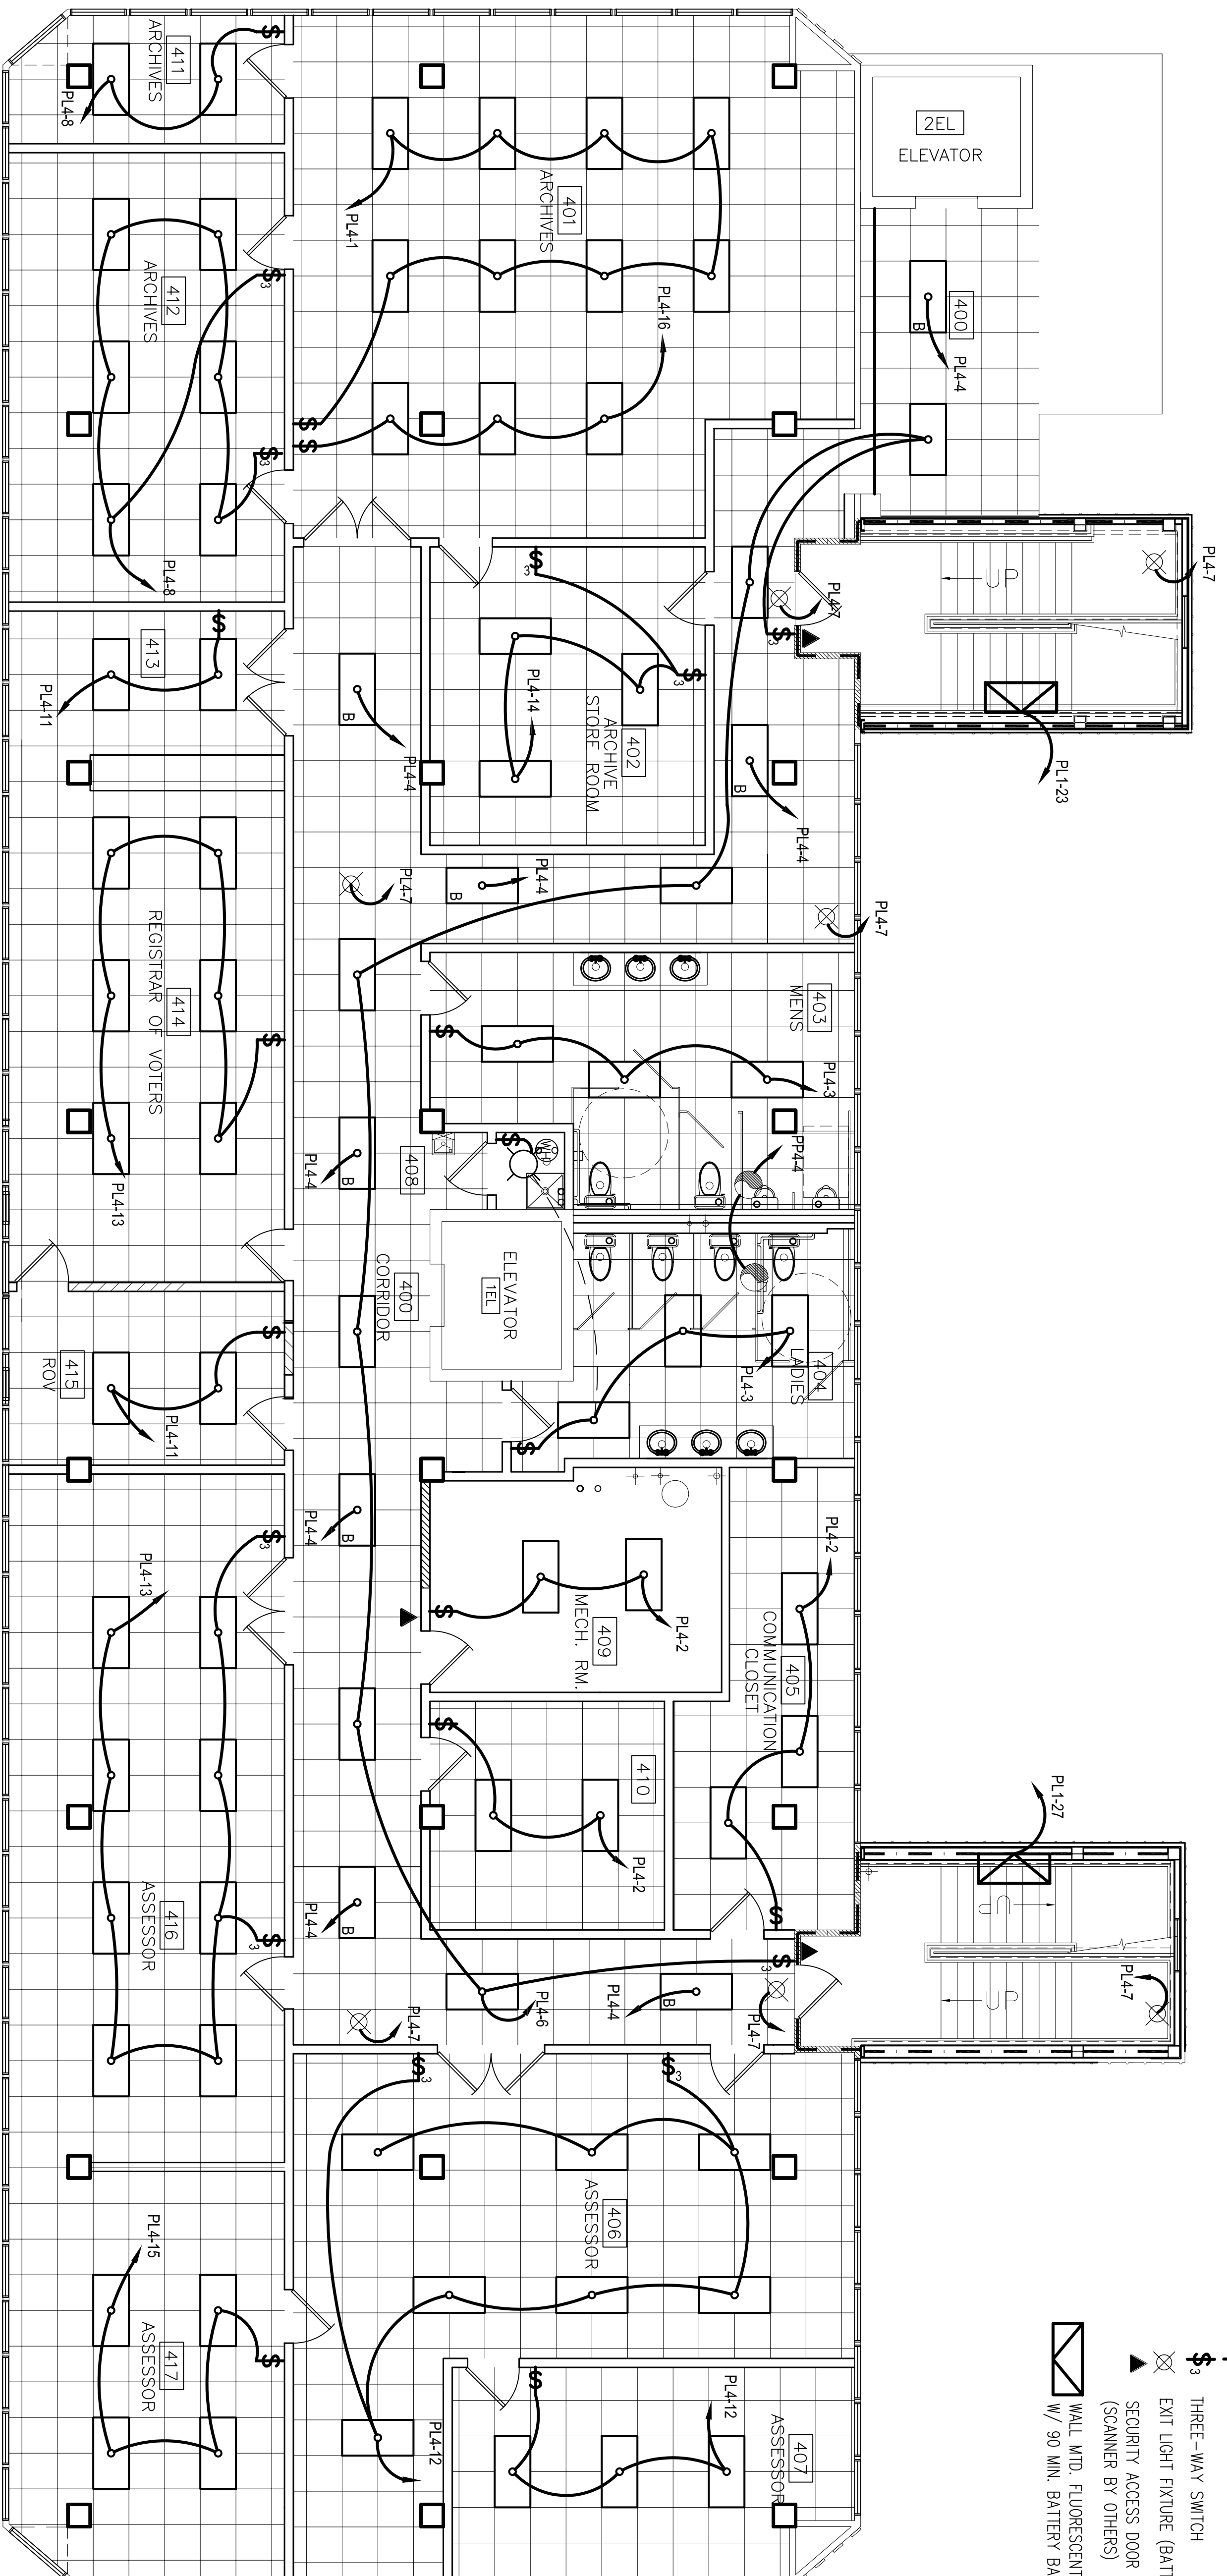

FOURTH FLOOR LIGHTING PLAN  
 SCALE: 3/16" = 1'-0"

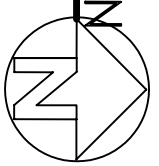

**4TH FLOOR LIGHTING PLAN**  
 ST. TAMMANY PARISH ADMIN. COMPLEX  
 OLD SPANISH TRAIL  
 SLIDELL, LOUISIANA

RENOVATE OFFICE BUILDING

**DAMMON ENGINEERING. INC.**

1095 FLORIDA AVENUE 985-649-5832 SLIDELL, LA. 70458  
 DAMMONENGINEERING.COM

SCALE: AS NOTED  
 FILE:  
 JOB NO.: 1729  
 DATE: 1-8-07  
 SHEET

OF  
**E4L**