




- LEGEND**
- ⊕ NEW DUPLEX RECEPTACLE
 - ⊖ EXHAUST FAN
 - ▲ SECURITY ACCESS DOOR (SCANNER BY OTHERS)
 - ◁ COMM @ DATA
 - Ⓜ COLUMN MOUNTED UTILITY
 - Ⓜ POWER AND COMM POLE
- NOTES**
- ALL NEW POWER PANELS ARE TO BE MOUNTED ON THE NORTH WALL OF THE MECHANICAL ROOMS

ACCESS CONTROL SINGLE DOOR WITH CARD READER, MAGNETIC LOCK, REX, JUNCTION BOX, DOOR CONTACT

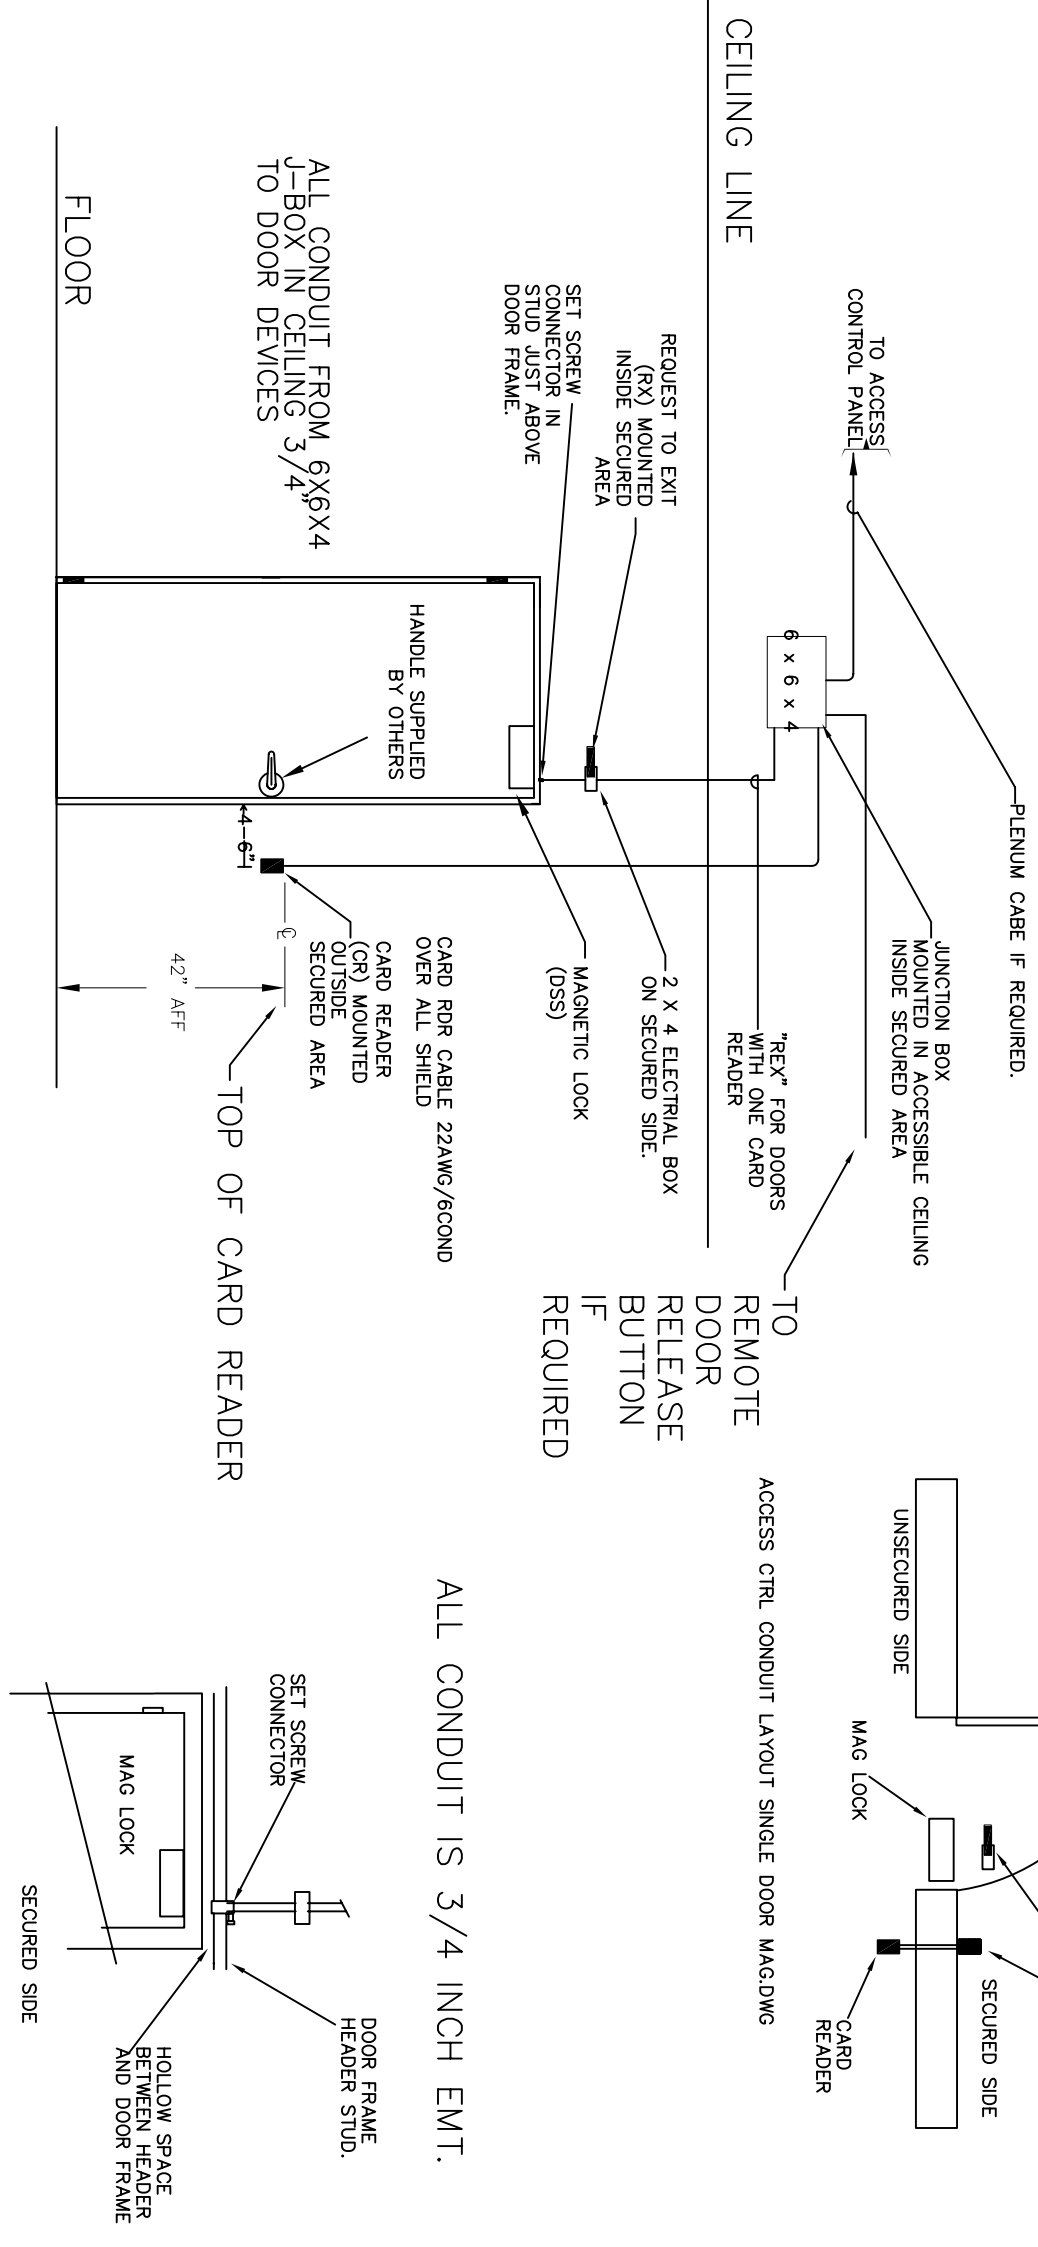

FIFTH FLOOR POWER PLAN

SCALE: 3/16" = 1'-0"

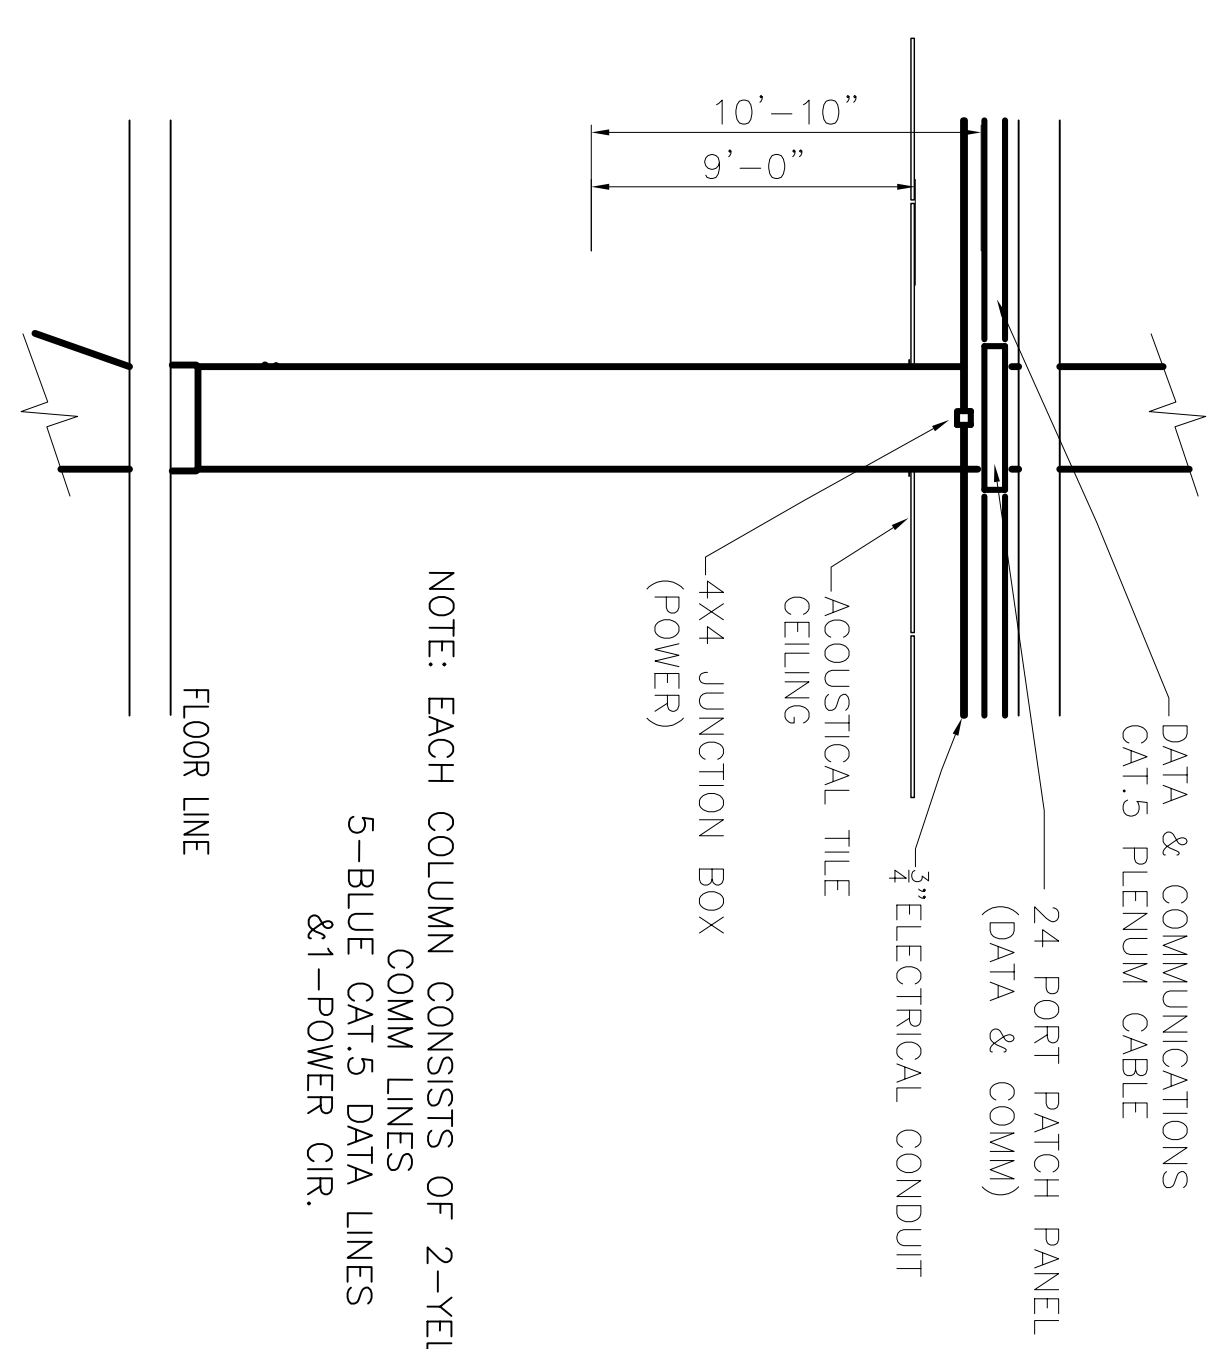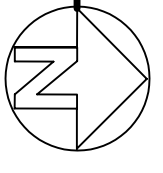

COLUMN MOUNTED UTILITY DETAIL

SCALE: NTS

- Ⓜ - INDICATES ITEMS CHANGED - 06/27/08
- Ⓜ - INDICATES ITEMS CHANGED - 05/29/08
- A = ADDED

5TH FLOOR POWER PLAN

ST. TAMMANY PARISH ADMIN. COMPLEX
OLD SPANISH TRAIL
SLIDELL, LOUISIANA

DAMMON ENGINEERING. INC.

1095 FLORIDA AVENUE 985-649-5832 SLIDELL, LA. 70458
DAMMONENGINEERING.COM

SHEET
ESP
OF

DATE: 1-8-07
JOB NO. 1729
SCALE: AS NOTED
FILE:
STAR HVAC REVISED: 05/29/08 ab
HVAC REVISED: 11/05/07 ab
REVISED: 01/23/07

RFP #2 11-13-07