

LEGEND



- ⊕ NEW DUPLEX RECEPTACLE
- ⊖ EXHAUST FAN
- ⬆ SECURITY ACCESS DOOR (SCANNER BY OTHERS)
- ⊙ COMM @ DATA
- ⊕ COLUMN MOUNTED UTILITY
- ⊖ POWER AND COMM POLE

NOTES

ALL NEW POWER PANELS ARE TO BE MOUNTED ON THE NORTH WALL OF THE MECHANICAL ROOMS

SIXTH FLOOR POWER PLAN
SCALE: 3/16" = 1'-0"

ACCESS CONTROL,
SINGLE DOOR WITH CARD READER,
MAGNETIC LOCK, REX, JUNCTION
BOX, DOOR CONTACT

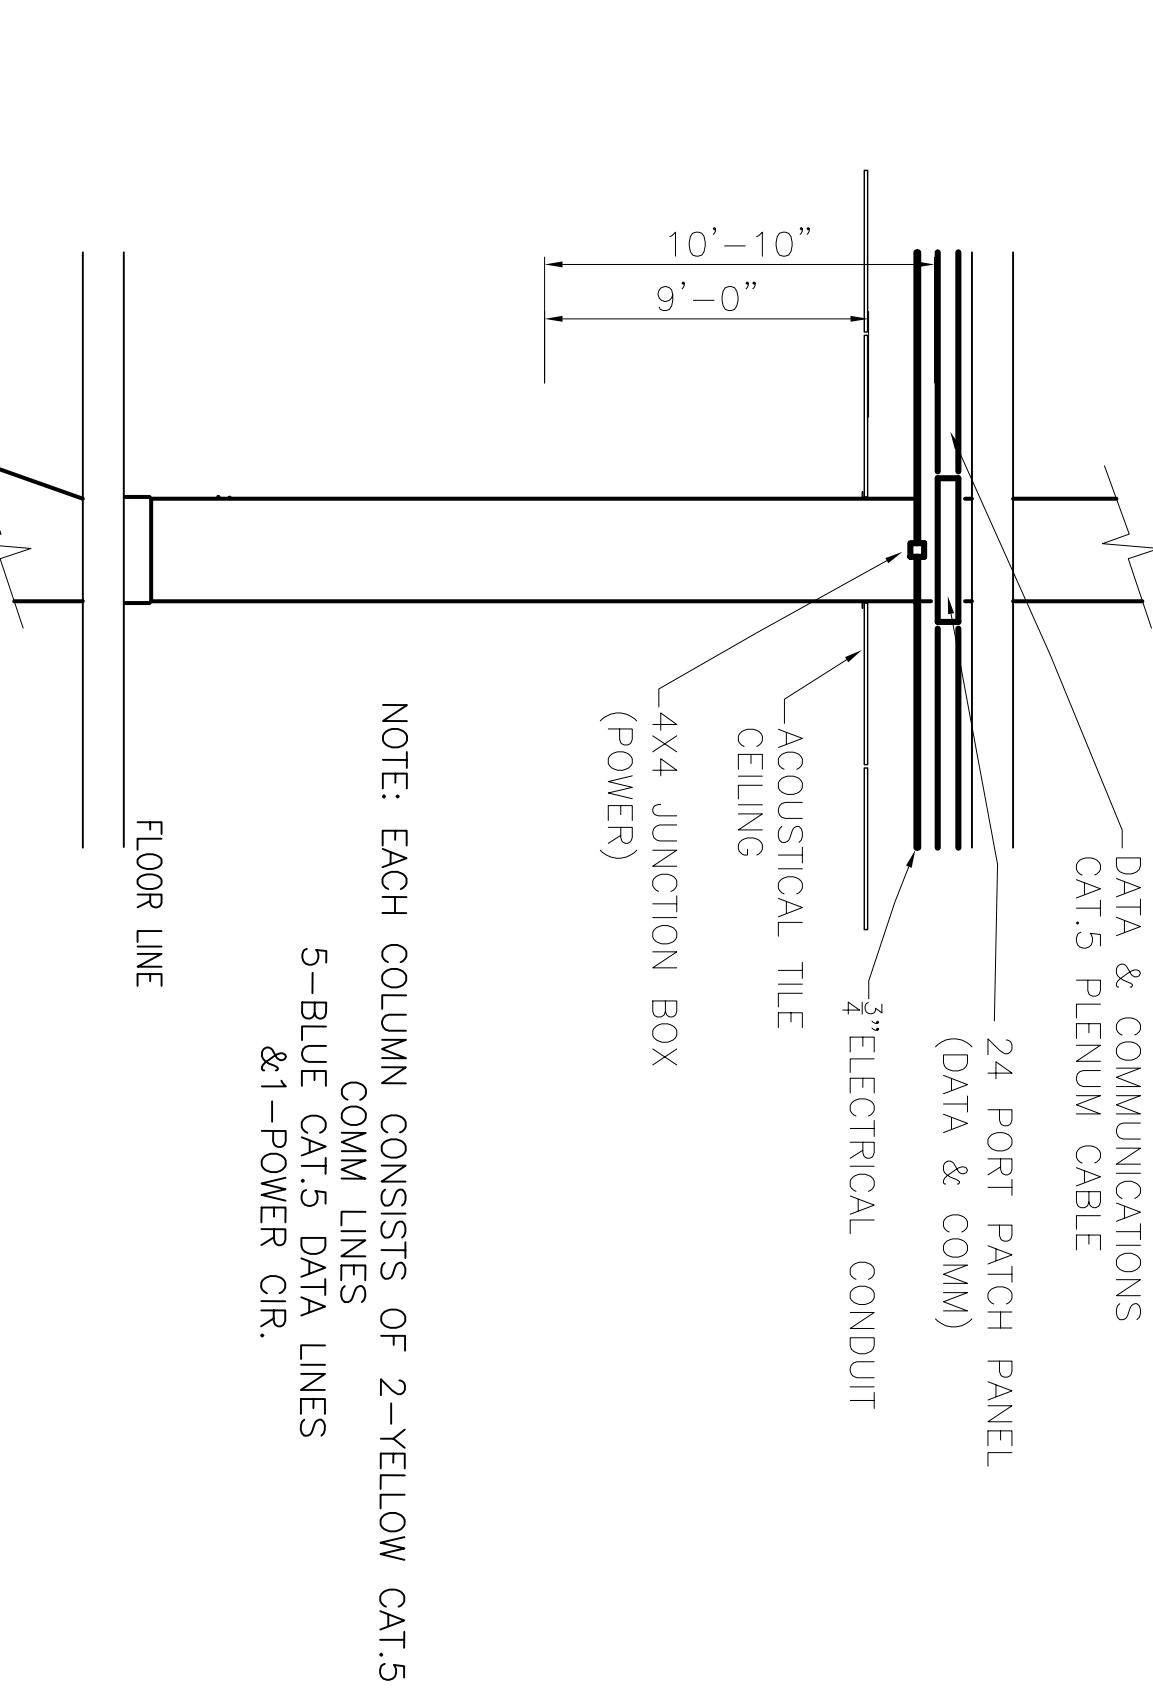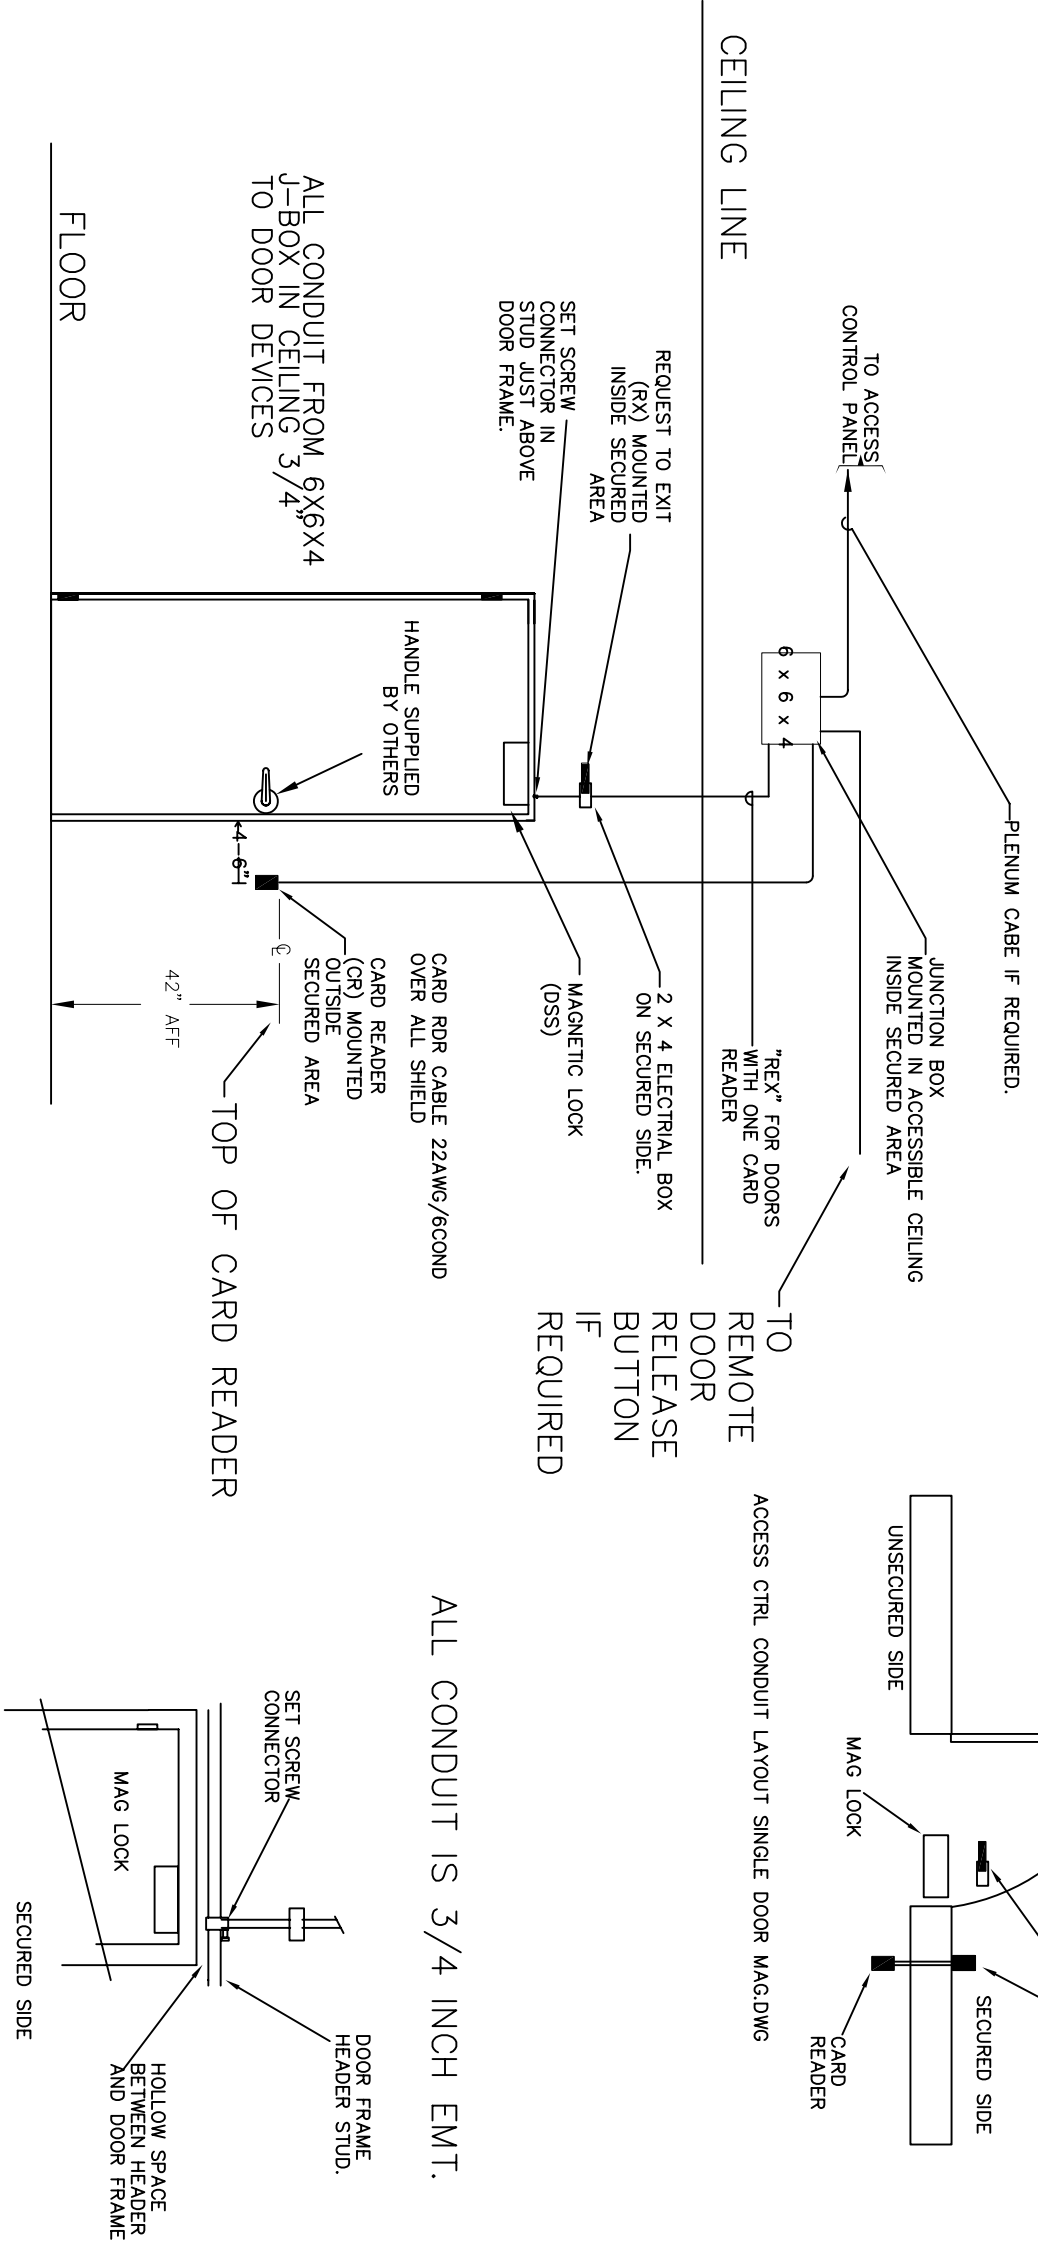

NOTE: EACH COLUMN CONSISTS OF 2-YELLOW CAT.5
COMM LINES
5-BLUE CAT.5 DATA LINES
& 1-POWER CIR.

- 45824 - INDICATES AREAS & ITEMS CHANGED - 10/17/08
- 45823 - INDICATES ITEMS CHANGED - 06/27/08
- 0000 - INDICATES ITEMS CHANGED - 05/29/08
- R = RELOCATED
- A = ADDED

COLUMN MOUNTED UTILITY DETAIL

SCALE: NTS

RFP 6 REVISED: 10/17/08 cb
STAR HVAC REVISED: 05/29/08 cb
HVAC REVISED: 11/05/07 ab
REVISED: 04/23/07
REVISED: 01/23/07

6TH FLOOR POWER PLAN

ST. TAMMANY PARISH ADMIN. COMPLEX
OLD SPANISH TRAIL
SLIDELL, LOUISIANA

RENOVATE OFFICE BUILDING

DAMMON ENGINEERING. INC.

1095 FLORIDA AVENUE 985-649-5832 SLIDELL, LA. 70458
DAMMONENGINEERING.COM

SHEET

DATE: 1-8-07

JOB NO. 1729

FILE:

SCALE: AS NOTED

6 P

OF

RFP #2 11-13-07