


**ST. TAMMANY PARISH
ADMINISTRATION COMPLEX RENOVATIONS**

520 OLD SPANISH TRAIL
SLIDELL, LOUISIANA

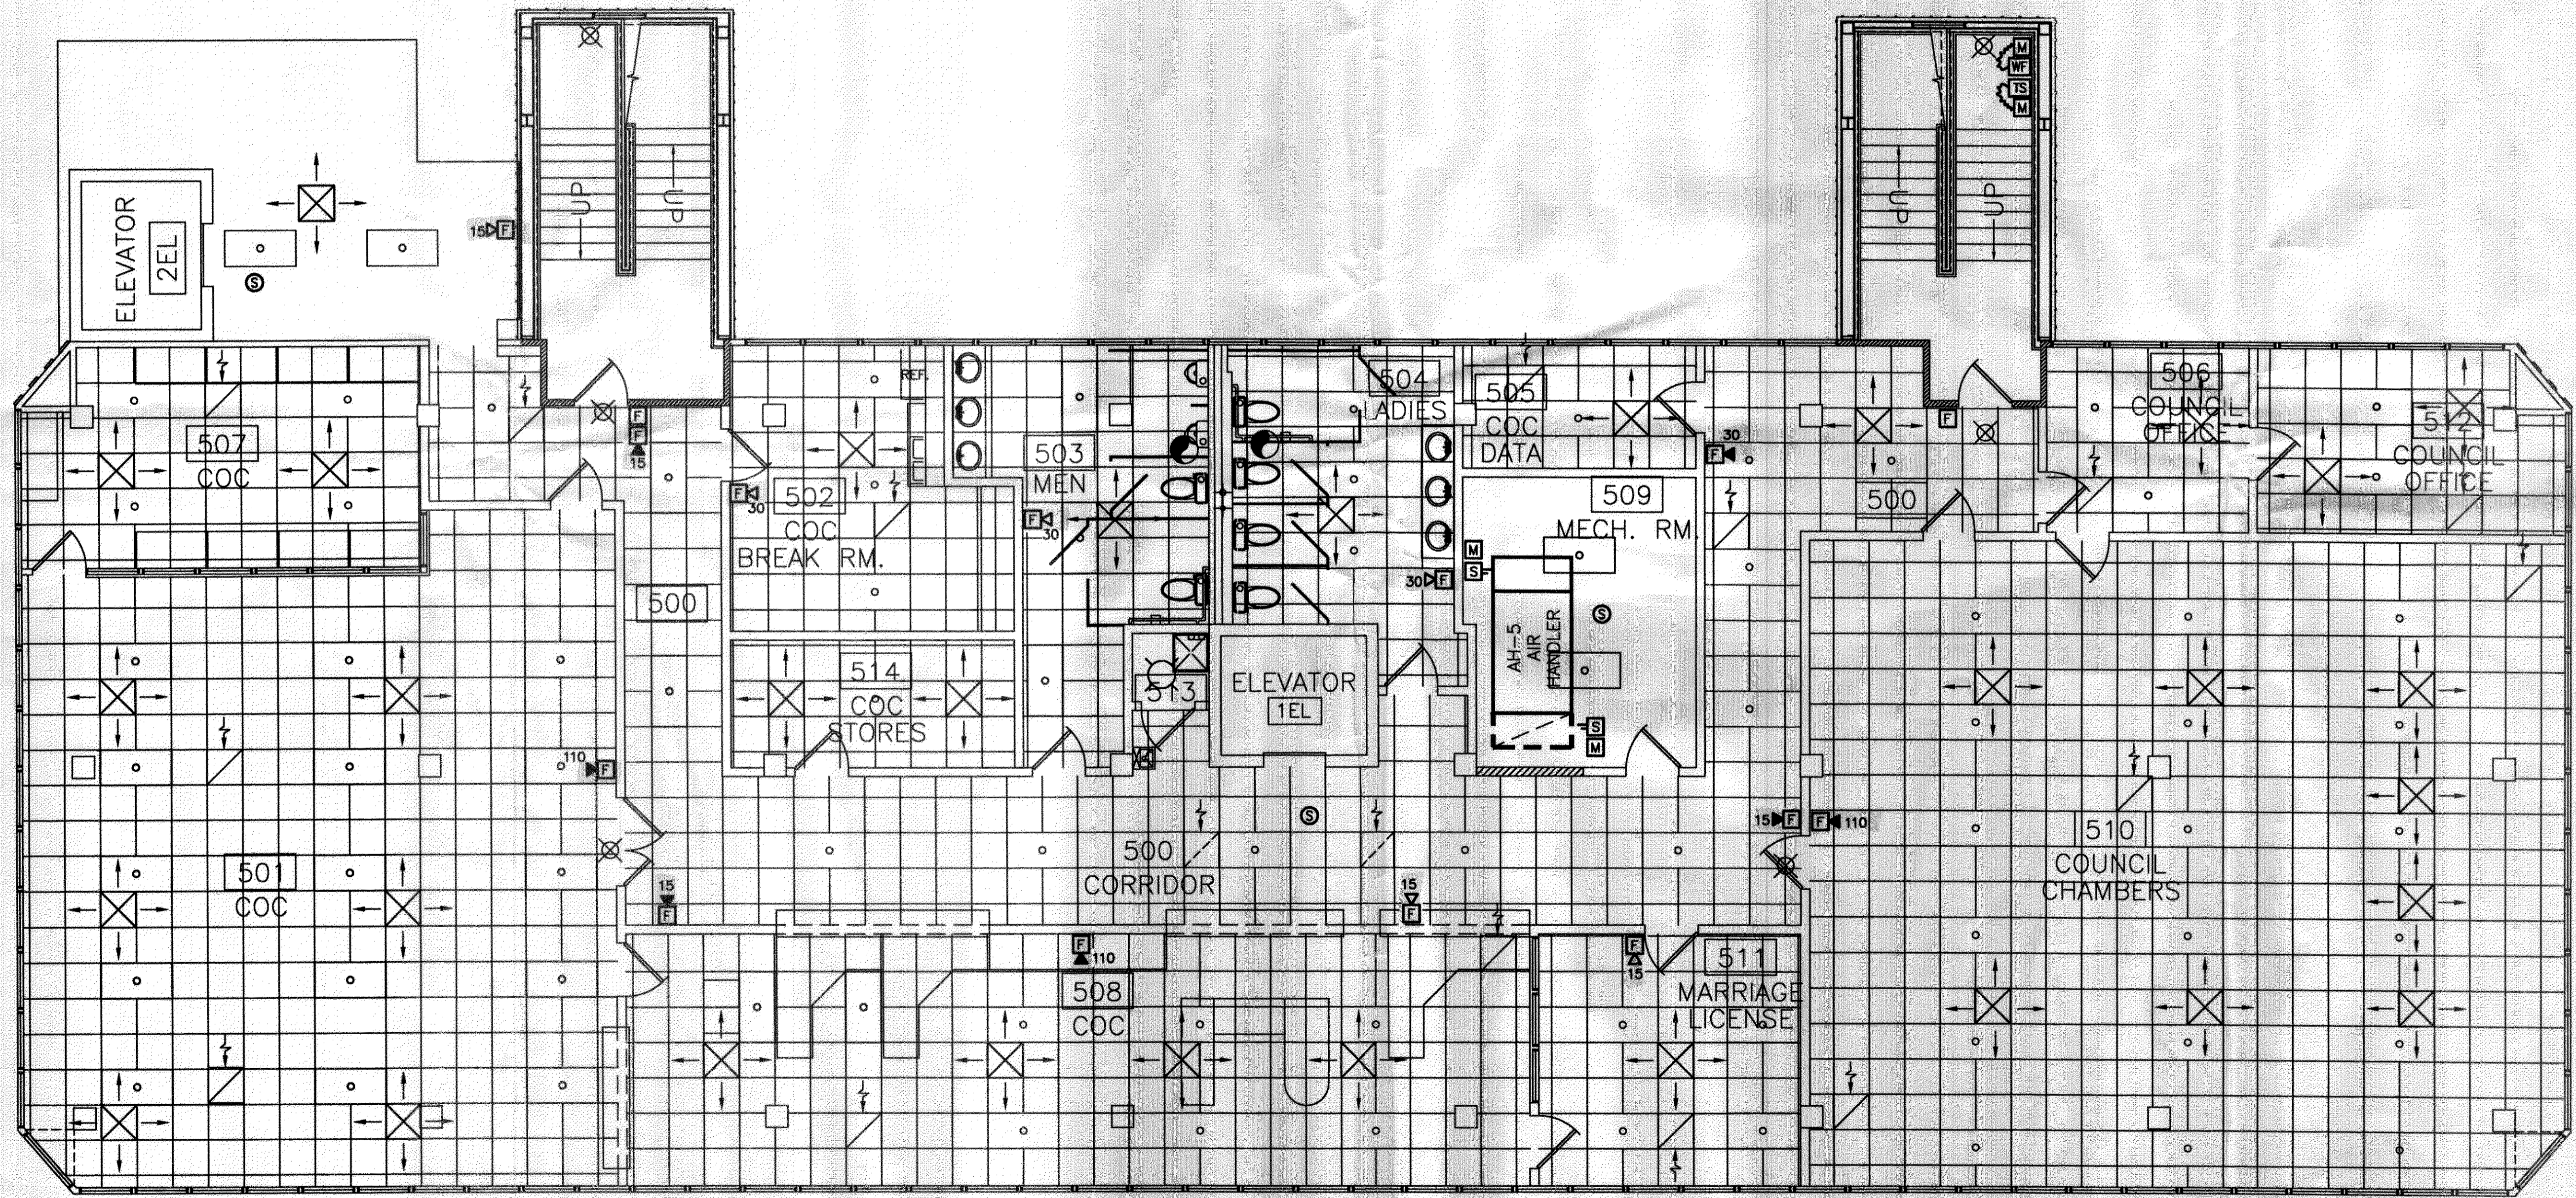

FIFTH FLOOR PLAN - FIRE DETECTION AND ALARM SYSTEM
SCALE 3/16" = 1'-0"

357110
REVIEWED FOR
STATE FIRE MARSHAL
AS PER REVIEW LETTER
BY WILLIAM D. JONES, ARCHITECT, CBO
William D. Jones

NOTE:
FIRE ALARM SYSTEM SMOKE DETECTORS
SHALL NOT BE INSTALLED WITHIN
3'-0" FROM AN A.H.U. AIR SUPPLY
DIFFUSER OR WITHIN 1'-0" OF A
LIGHT FIXTURE.

DESIGNED BY:	FRED FATH
DATE:	OCTOBER 2008
PROJ. NO.:	
SCALE:	3/16"=1'-0"