


FIRST FLOOR PLAN - FIRE DETECTION AND ALARM SYSTEM
 SCALE 3/16" = 1'-0"

357110
 REVIEWED FOR
 STATE FIRE MARSHAL
 AS PER REVIEW LETTER
 BY: WILLIAM D. JONES, ARCHITECT, CDO
William D. Jones

NOTE:
 FIRE ALARM SYSTEM SMOKE DETECTORS
 SHALL NOT BE INSTALLED WITHIN
 3'-0" FROM AN A.H.U. AIR SUPPLY
 DIFFUSER OR WITHIN 1'-0" OF A
 LIGHT FIXTURE.

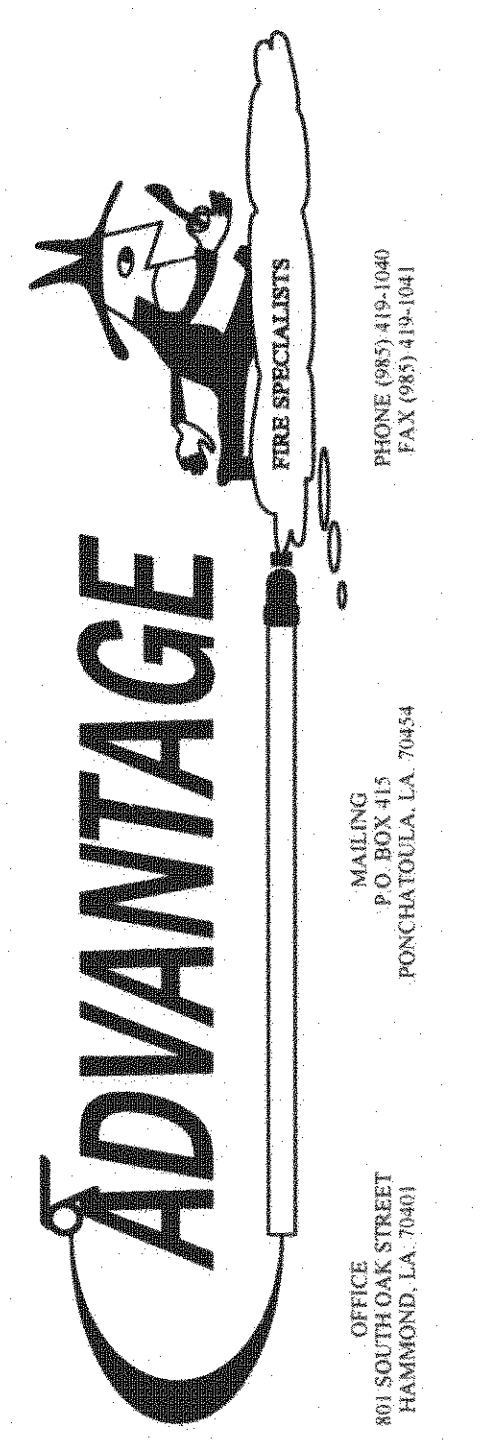

OFFICE
 801 SOUTH OAK STREET
 MONROE, LA 70501
 PHONE (850) 449-1000
 FAX (850) 449-1001
 MAILING
 P.O. BOX 115
 MONROE, LA 70504

ST. TAMMANY PARISH
 ADMINISTRATION COMPLEX RENOVATIONS

520 OLD SPANISH TRAIL
 SLIDELL, LOUISIANA

DESIGNED BY:	FRED FATH
DATE:	OCTOBER 2008
PROJ. NO.:	
SCALE:	3/16"=1'-0"