

SPLIT SYSTEM SCHEDULE																			
TAG	MAKE/MODEL	NOMINAL TONS	TOTAL CFM	AIR HANDLER				HEAT KW	CONDENSING UNIT								REMARKS		
				OACFM	Motor HP	ESP (" WC)	POWER				TAG	MAKE/MODEL	NOMINAL TONS	POWER					
							VAC		PH	MCA				MAX FUSE (AMPS)	VAC	PH		MCA	MAX FUSE (AMPS)
AHU-1	Trane TEM6A0C60	5	1890	460	3/4	0.4	7.6	240	1	44	45	CU-1	Trane 4TTZ6060	5	240	1	34	60	1, 2, 3

NOTES:  
 1. Provide condensate overflow switch & programmable 7/24 thermostat with lockable cover.  
 2. Install units in accordance with manufacturer's recommendations.  
 3. Provide new filters after commissioning and final acceptance.

DIFFUSER SCHEDULE					
TAG	SERVICE	NECK SIZE	DESCRIPTION		REMARKS
A	Supply Air	Ref. Plan	24"x 24" Adjustable Square Cone Diffuser, Price ASCDA w/ Insulated Back Panel		1, 2, 3
B	Supply Air	Ref. Plan	12"x 12" Adjustable Square Cone Diffuser, Price ASCDA w/ Insulated Back Panel		1, 2, 3
C	Return Air	Ref. Plan	24" X 24" Perforated, Ducted Return, Titus PAR		1, 2, 3
D	Return Air	Ref. Plan	12" X 12" Perforated, Ducted Return, Titus PAR		1, 2, 3

Notes:  
 1. Seal perimeter of diffusers/grilles to prevent moisture migration from attic space, as applicable  
 2. R value of insulated back panels/plenums to exceed R-6  
 3. Coordinate with owner / architect for color and finish

EXHAUST FAN SCHEDULE										
TAG	FAN				POWER		MAKE / MODEL	REMARKS		
	AIRFLOW (CFM)	TSP (" wc)	Watts	HP	TYPE	VAC			PH	HZ
EF-1	130	0.2	98		Ceiling Exhaust	120	1	60	Cook GC-148	1, 2
EF-2	1450	0.1		1/4	Attic Exhaust	120	1	60	Greenheck AE-12-433-A4X-QD	1, 3
EF-3	3480	0.1		1/3	Side Wall Exhaust	120	1	60	Greenheck S2-18-415-A3	1, 4
EF-4	100	0.1		5/7	Side Wall Exhaust	120	1	60	S&P SWF-100	1

1. Install per manufacturer's recommendations.  
 2. Furnish with inline aluminum grille.  
 3. Furnish with matching roof curb.  
 4. Furnish with OSHA motor guard, weatherhood and backdraft damper.

DEHUMIDIFIER SCHEDULE							
TAG	PART NUMBER	WATTS	PHASE	VOLTS	AMPS	DUCT SIZES	
						INLET	OUTLET
DH	ULTRA-AIRE-XT155H	920 @ 80°F & 60% RH	SINGLE	110-120	8	10" ROUND DUCT COLLAR 6" ROUND DUCT COLLAR	10" OVAL DUCT COLLAR

GAS FIRED HEATER SCHEDULE									
TAG	LOCATION	BTUH INPUT	CFM	HP	VOLTS	PHASE	RPM	FLUE DIA.	DESCRIPTION
GUH-1,2	ENGINE BAY	85000	1650	1/8	120	SINGLE	1550	3"	93% EFFICIENT CONDENSING FURNACE GAS HEATER WITH SEPARATE COMBUSTION, POWERED EXHAUST AND CONCENTRIC COMBUSTION/ EXHAUST KIT PROVIDED OPTONIC 409 SS HEAT EXCHANGER. MODINE PTC-85-SS-01








ELECTRIC WATER HEATER SCHEDULE								
TAG	GAL	RECOVERY 80°F RISE	KW	VOLT	PHASE	MOUNT	PIPE SIZE	DESCRIPTION
WH	47*	61	12	208	SINGLE	ATTIC	1"	RHEEM ELDS-52

\* PROVIDED HOLDRITE 50-SWHP-W WALL MOUNT KIT. MOUNT 6'-8" A.F.F.

VEHICLE EXHAUST SYSTEM			
DESCRIPTION	PART NUMBER	QTY	REMARKS
CONTROL PANEL	600627 - 01	1	
PHOTO EYES	600701	4	

AIR VAC EXHAUST			
PART NUMBER	MOTOR	ELECTRIC	QTY
AIR VAC 911 EXHAUST REMOVAL SYSTEM	3/4 HP	115VOLT, SINGLE PHASE, 13 FL AMPS	3

HVLS FAN SCHEDULE						
TAG	LOCATION	SIZE	RPM	HP	FR	DESCRIPTION
FTB	ENGINE BAY	8' DIA.	191	1	1	HVLS 8'Ø FAN WITH VFD AND WALL MOUNTED CONTROL PANEL BIG ASS FANS POWERFOL 8-08

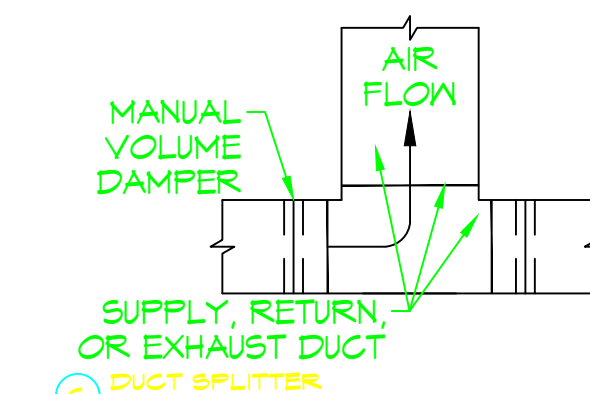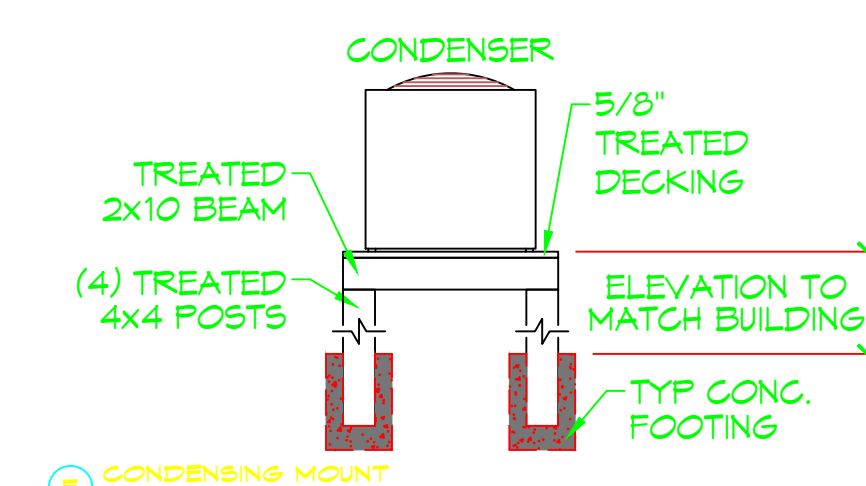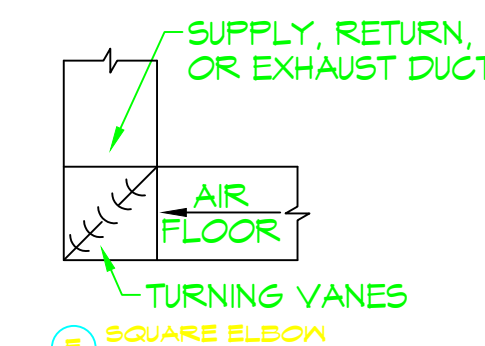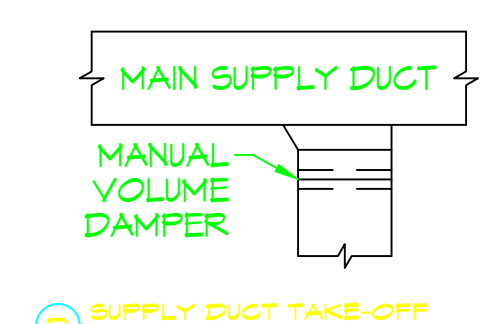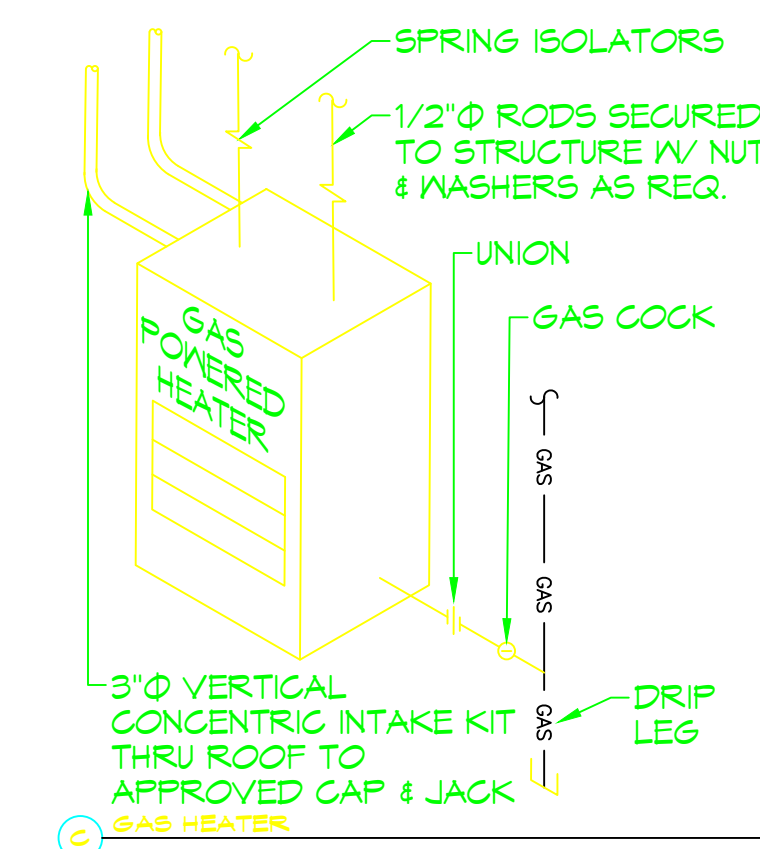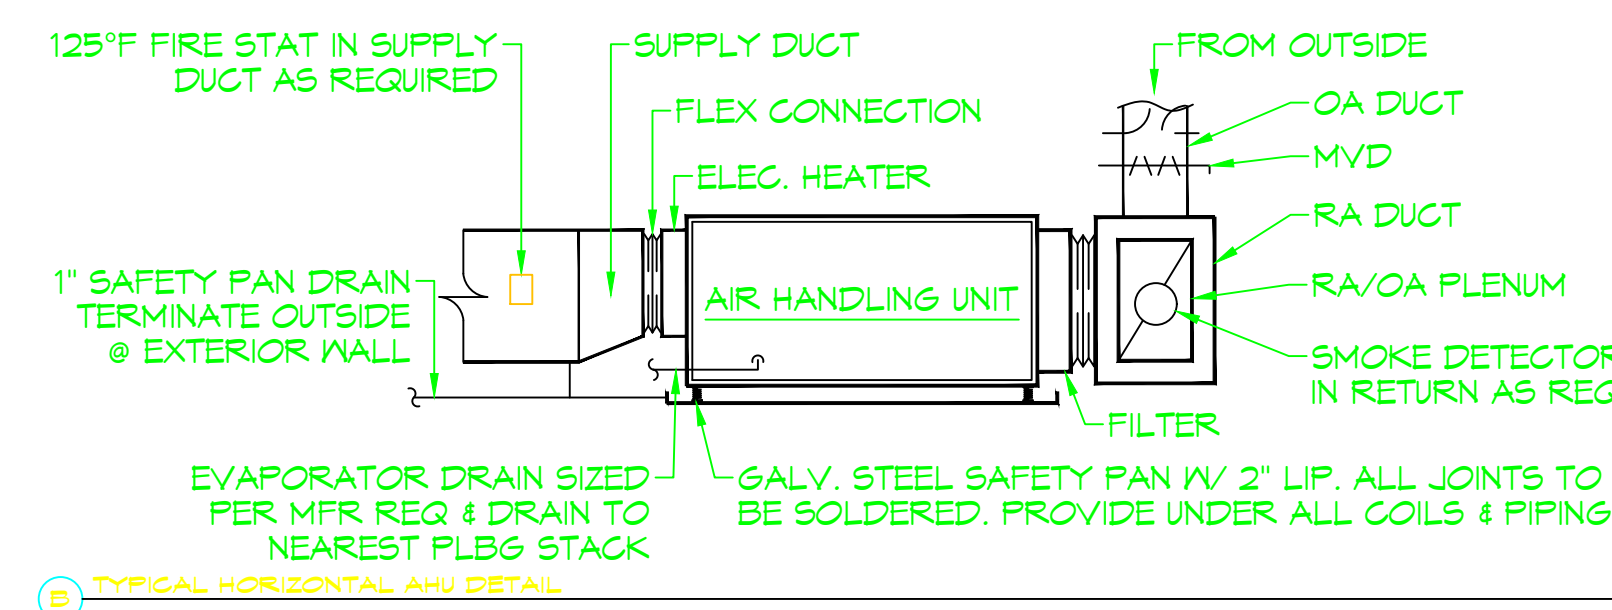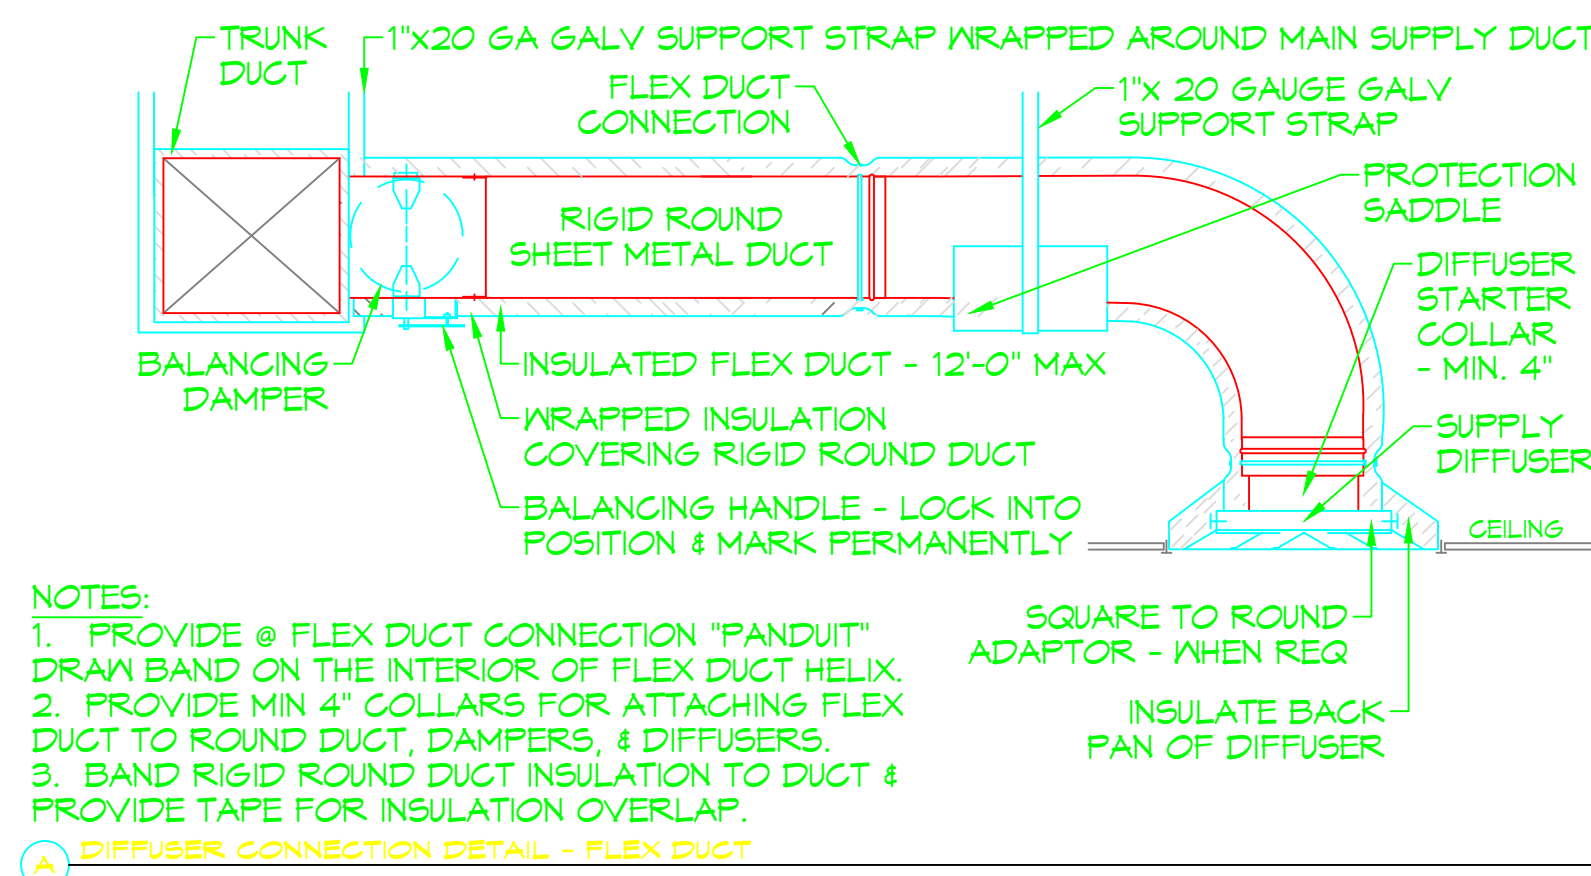

**TYPICAL DETAILS**  
SCALE: N.T.S.

**DAMMON ENGINEERING, INC.**  
 LOUISIANA & MISSISSIPPI  
 Chief Engineer: Brian Hatcher, PE  
 554 Old Spanish Trail  
 Slidell, LA 70458  
 Phone: 985.699.8832  
 Fax: 985.699.8832  
 Email: info@dammoneengineering.com

REVISIONS	DATE
DESCRIPTION	

SEAL:

ST. TAMMANY FIRE PROTECTION DISTRICT NO. 1  
**FIRE STATION 19**  
 57047 ALLEN ROAD  
 LAUREL, LOUISIANA 70461  
 JOB No.:  
 DATE: 04-07-2022  
 DRAWN BY: CKD  
 CHECKED BY: JMS

SHEET TITLE:  
 MECHANICAL DETAILS AND SCHEDULES  
 DRAWING NUMBER:  
**M102**  
 SHEET No: 10 of x