


PLUMBING ABBREVIATIONS

LAV LAVATORY
 WC WATER CLOSET
 CB CATCH BASIN
 W WASHER MACHINE
 WH WATER HEATER
 SH SHOWER

PLUMBING LEGEND

CLEAN OUT
 P-TRAP
 FLOOR DRAIN
 SEWAGE LINE
 VENT LINE
 GAS LINE
 WASTE LINE
 HOT WATER
 CATCH BASIN
 METER
 PLUG COCK
 COLD WATER
 GATE VALVE

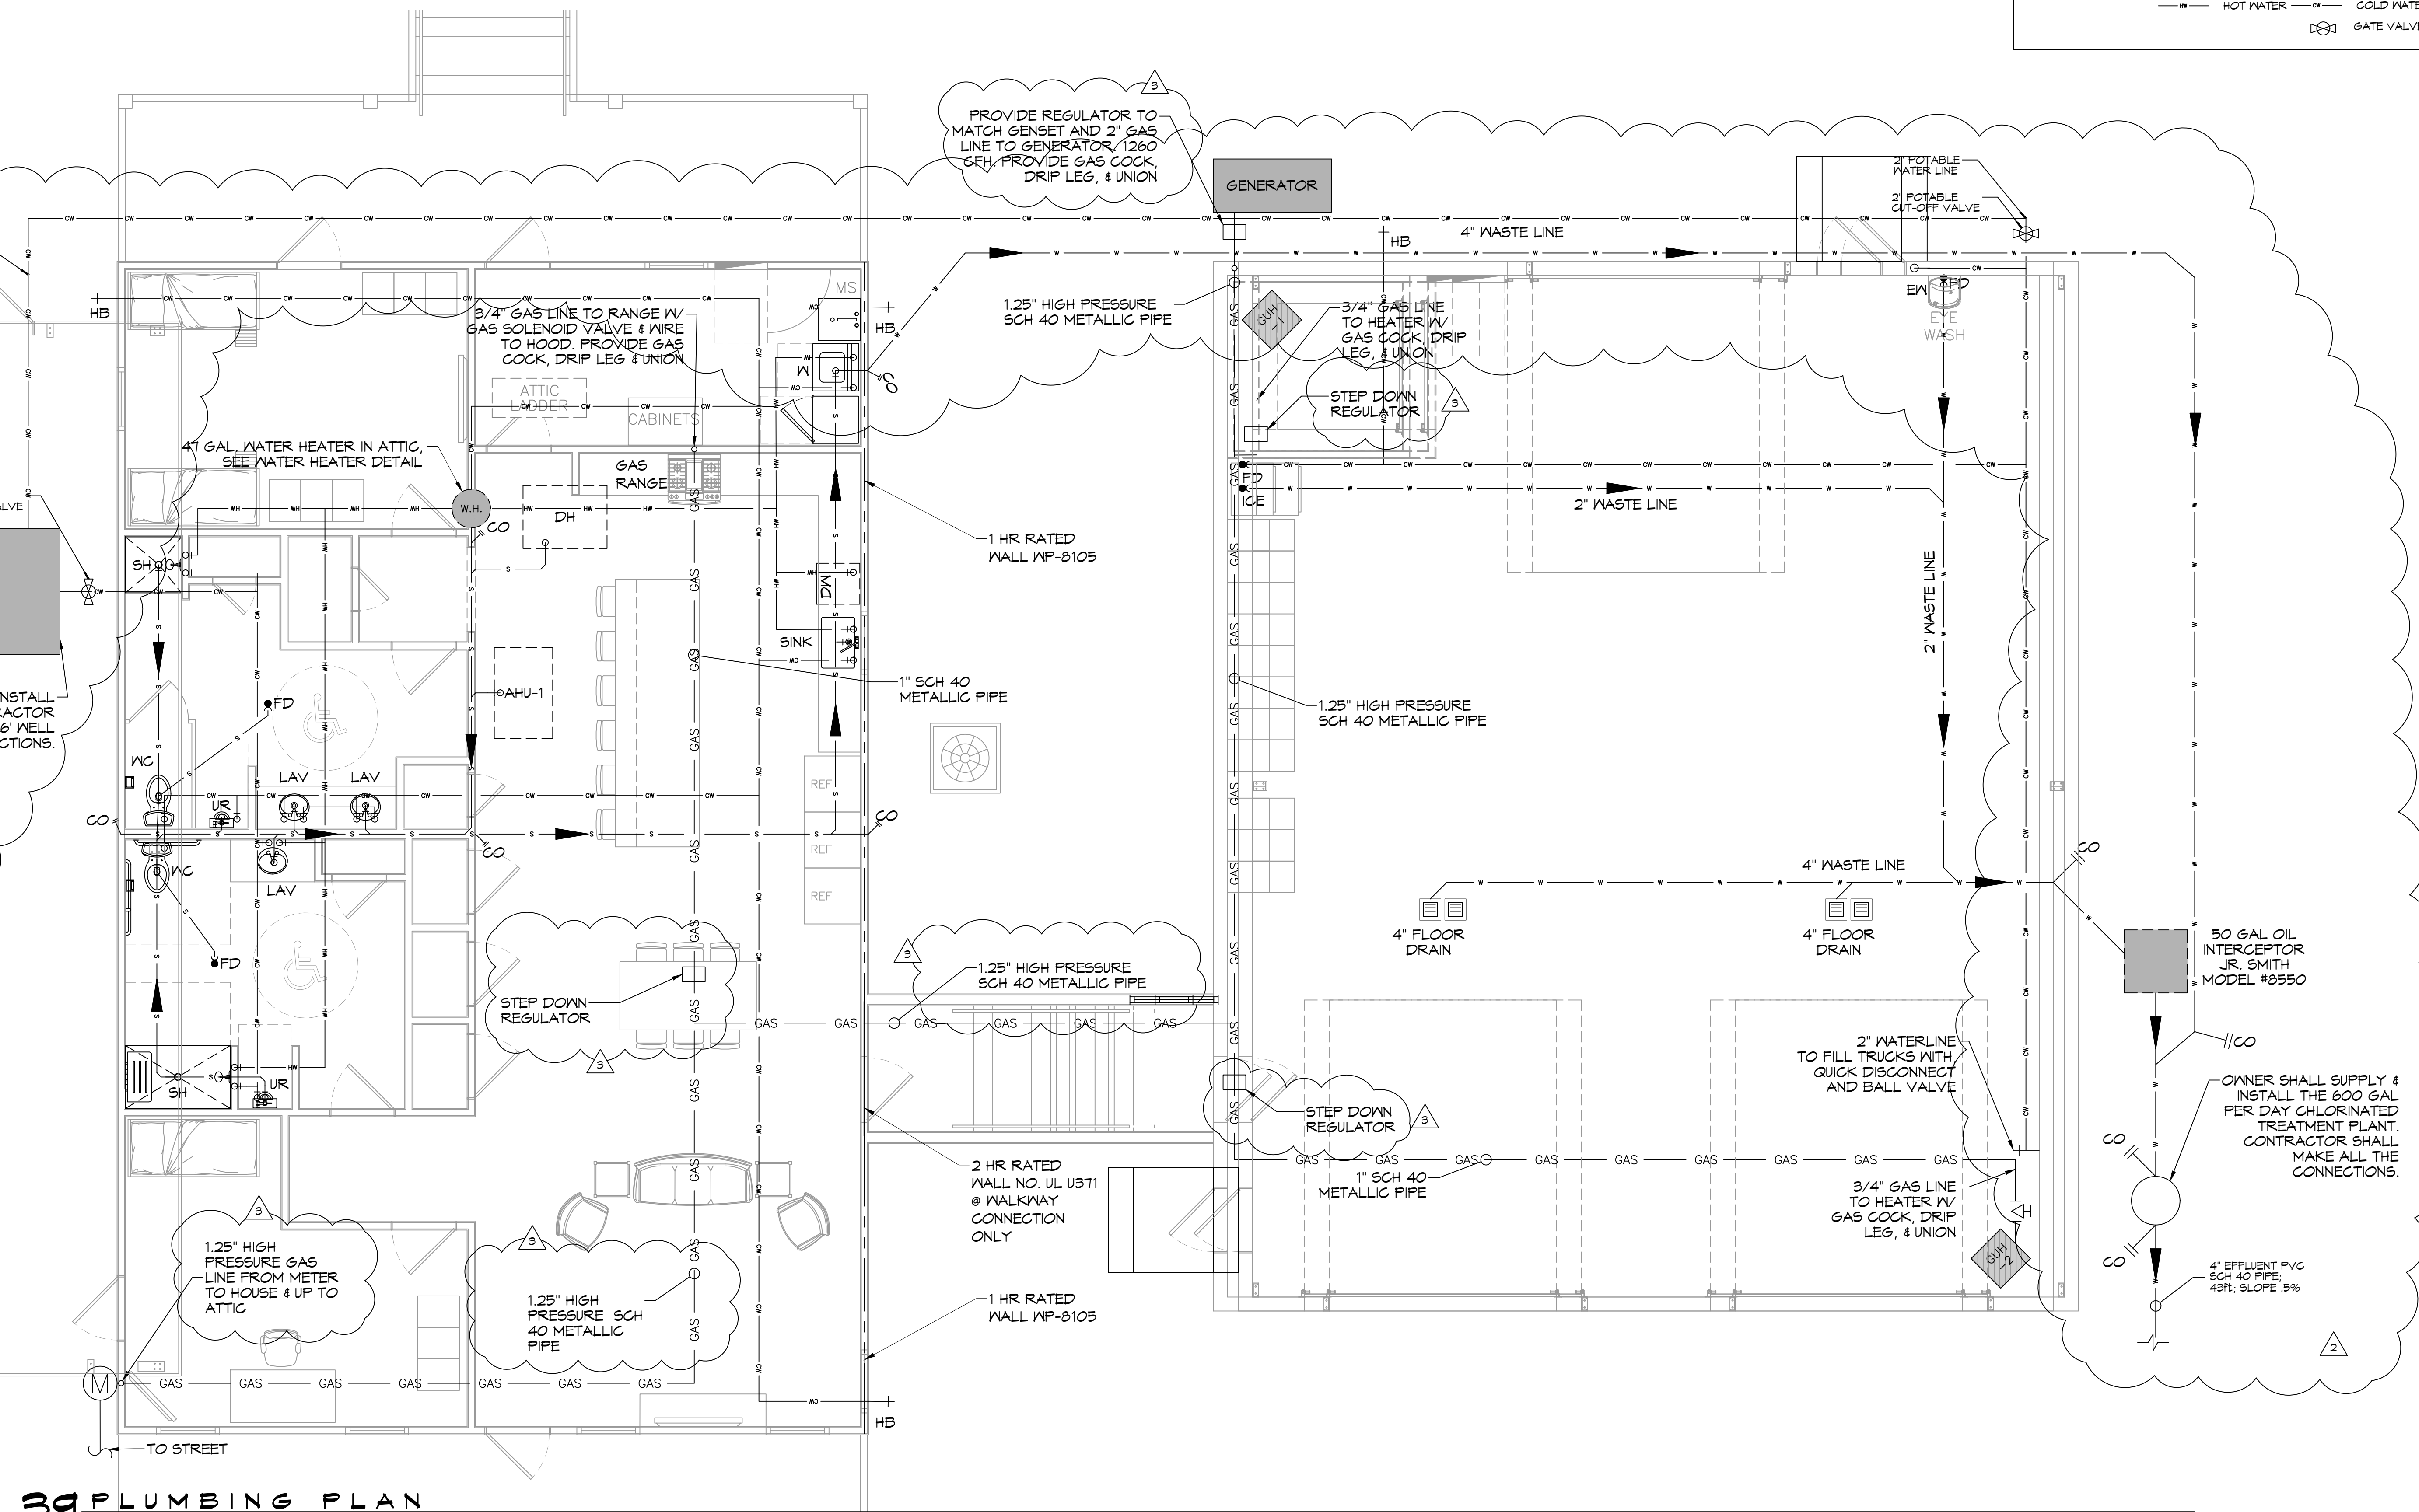

39 PLUMBING PLAN
 SCALE: 1/4" = 1'-0"

AS-BUILT
 1-31-24

DAMMON ENGINEERING, INC.
 LOUISIANA & MISSISSIPPI
 Chief Engineer: Brian Mistich, PE
 554 Old Spanish Trail
 Slidell, LA 70458
 www.dammonengineering.com
 info@dammonengineering.com
 PH: 985.649.8832

#	DESCRIPTION	DATE
1	OWNER SHALL FINISH WELL AND TREATMENT PLANT	07-28-22
2	RELOCATED TREATMENT PLANT AND WELL	04-08-22
3	REVISED GAS LINES FOR HIGH PRESSURE	4/19/2023



ST. TAMMANY FIRE PROTECTION DISTRICT NO. 1
FIRE STATION 19
 57047 ALLEN ROAD
 SLIDELL, LOUISIANA 70461
 JOB No: 2456
 DATE: 05-16-2022
 DRAWN BY: CKD
 CHECKED BY: JMS

SHEET TITLE:
 PLUMBING PLAN
 DRAWING NUMBER:
P101
 SHEET No: 23 of 30