


BOAT STORAGE BLDG. 2442 FLOOR PLAN
SCALE: 1/8" = 1'-0"

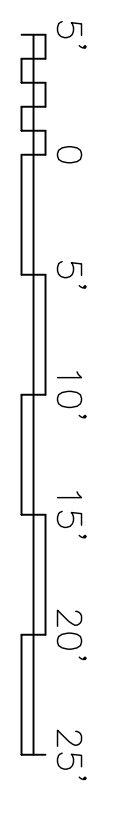

PLAN NORTH

- FIRE PROTECTION SYMBOLS**
- (WB) - FIRE EXTINGUISHER ON WALL BRACKET
 - (RC) - FIRE EXTINGUISHER IN RECESSED CABINET

RECORD DRAWING
LETTER DATED -
5-27-10



DEPARTMENT OF THE NAVY NAVAL FACILITIES ENGINEERING COMMAND SOUTHEAST NAVAL AIR STATION JACKSONVILLE JOHN C. STENNIS SPACE CENTER MISSISSIPPI SOF RIVERINE AND COMBATANT CRAFT OPERATIONS FACILITY - PRE-FINAL BOAT STORAGE BLDG. 2442 FLOOR PLAN		NAVAL FACILITIES ENGINEERING COMMAND MISSISSIPPI JOHN C. STENNIS SPACE CENTER MISSISSIPPI SOF RIVERINE AND COMBATANT CRAFT OPERATIONS FACILITY - PRE-FINAL BOAT STORAGE BLDG. 2442 FLOOR PLAN		DESIGNED BY: R. WITSE DRAWN BY: J. THERIAULT CHECKED BY: T. ARBIB IN CHARGE: P. DAMMON	EMMETT B. DAMMON LICENSED PROFESSIONAL ENGINEER STATE OF MISSISSIPPI LICENSE NO. 9662	DAMMON ENGINEERING, INC. 1000 W. WILSON BLVD. SUITE 200 MONROE, LA 70001 (985) 649-8312 (985) 649-8312	NAVFAC	AS-BUILT CONDITIONS SHOWN REVISED FOR FINAL REVISED AS PER URS COMMENTS 9 OCTOBER 2009	3-8-10 12-7-09 11-6-09	RW RW RW
SYM	DESCRIPTION	DATE	APPR							