


NOTE: WATER DISTRIBUTION MAINS TO BE PVC PRESSURE PIPE. PROVIDE DUCTILE IRON PIPE FOR DIAMETERS GREATER THAN 12" DEPTHS GREATER THAN 10', AND FLANGED DUCTILE IRON PIPE FOR ALL ABOVE GROUND LOCATIONS.

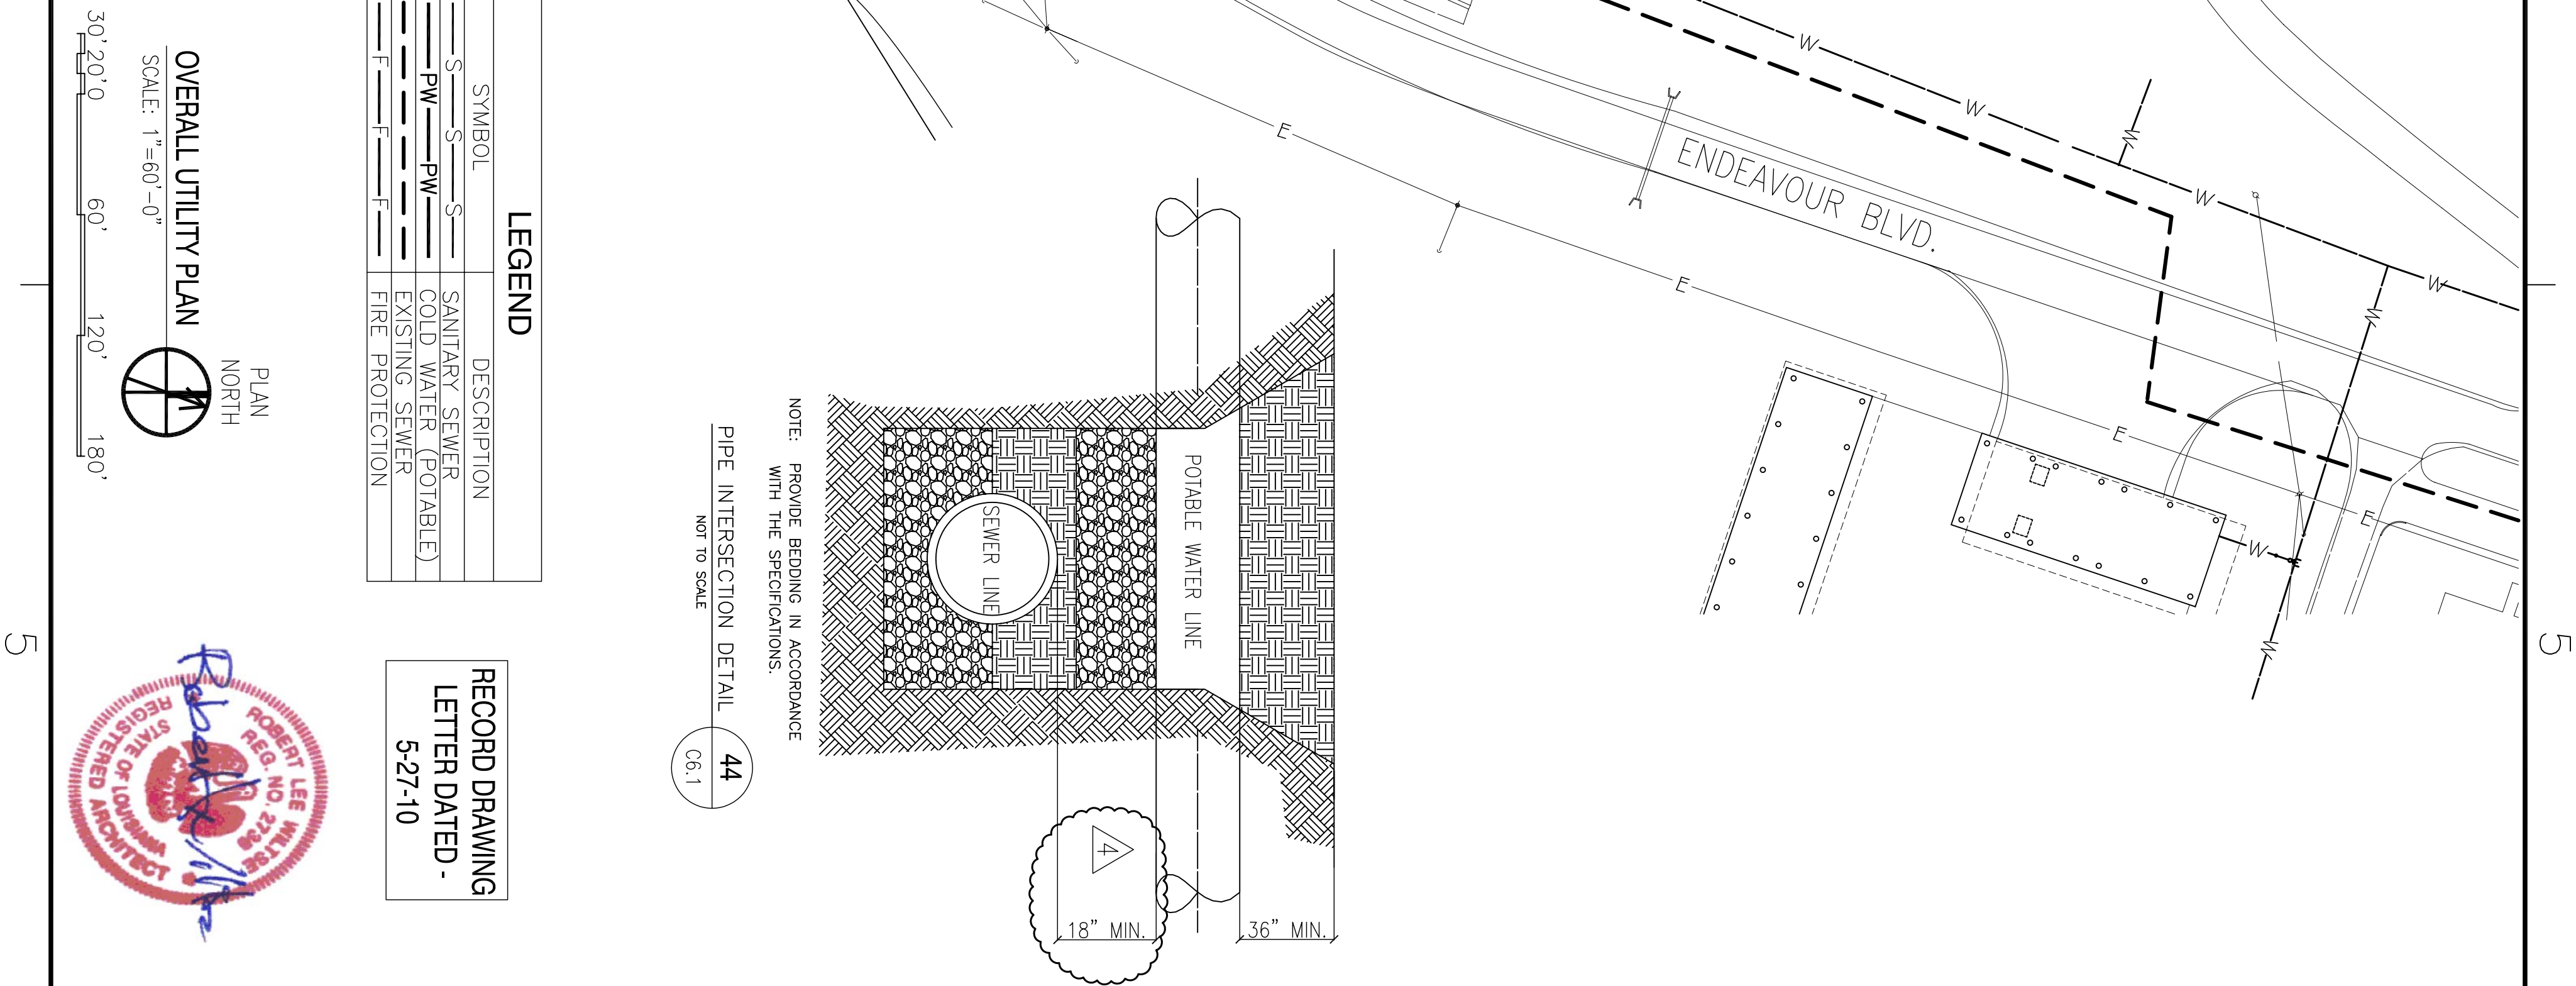

SYMBOL	DESCRIPTION
S	SANITARY SEWER
PW	COLD WATER (POTABLE)
---	EXISTING SEWER
---	FIRE PROTECTION

RECORD DRAWING
LETTER DATED -
5-27-10

OVERALL UTILITY PLAN
SCALE: 1"=60'-0"
PLAN NORTH



<p>DEPARTMENT OF THE NAVY NAVAL FACILITIES ENGINEERING COMMAND SOUTHEAST NAVAL AIR STATION JACKSONVILLE MISSISSIPPI</p> <p>JOHN C. STENNIS SPACE CENTER SOF OPERINE AND COMBATANT CRAFT OPERATIONS FACILITY - PRE-FINAL</p> <p>OVERALL UTILITY PLAN</p>	<p>RES: C. DAMMON, I. DEWE, C. DAMMON FORWARDED BY: R. WILSEY FW/INK: T. ARBIB CHIEF ENGINEER: P. DAMMON</p>	<p>EMMETT B. DAMMON REGISTERED PROFESSIONAL ENGINEER STATE OF MISSISSIPPI LICENSE NO. 9882</p>	<p>DAMMON ENGINEERING, INC. 1000 PINEAPPLE CHASE SUITE 100 DAMMON, LA 70504 SCHOOL, LA 70538 (985) 649-4332</p>	<p>NAVFAC</p>	<table border="1"> <thead> <tr> <th>SYM</th> <th>DESCRIPTION</th> <th>DATE</th> <th>APPR</th> </tr> </thead> <tbody> <tr> <td>△</td> <td>AS-BUILT CONDITIONS SHOWN</td> <td>3-12-10</td> <td>RW</td> </tr> <tr> <td></td> <td>REVISED FOR FINAL</td> <td>12-7-09</td> <td></td> </tr> <tr> <td></td> <td>REVISED FIRE PROTECTION WATER LINE PLACEMENT</td> <td>11-30-09</td> <td>RW</td> </tr> <tr> <td></td> <td>REVISED AS PER URS COMMENTS 9 OCTOBER 2009</td> <td>11-6-09</td> <td>RW</td> </tr> </tbody> </table>	SYM	DESCRIPTION	DATE	APPR	△	AS-BUILT CONDITIONS SHOWN	3-12-10	RW		REVISED FOR FINAL	12-7-09			REVISED FIRE PROTECTION WATER LINE PLACEMENT	11-30-09	RW		REVISED AS PER URS COMMENTS 9 OCTOBER 2009	11-6-09	RW
SYM	DESCRIPTION	DATE	APPR																						
△	AS-BUILT CONDITIONS SHOWN	3-12-10	RW																						
	REVISED FOR FINAL	12-7-09																							
	REVISED FIRE PROTECTION WATER LINE PLACEMENT	11-30-09	RW																						
	REVISED AS PER URS COMMENTS 9 OCTOBER 2009	11-6-09	RW																						