


LOWER GAINESVILLE RD.

LEGEND	
SYMBOL	DESCRIPTION
S	SANITARY SEWER
PW	COLD WATER (POTABLE)
—	EXISTING SEWER
F	FIRE PROTECTION

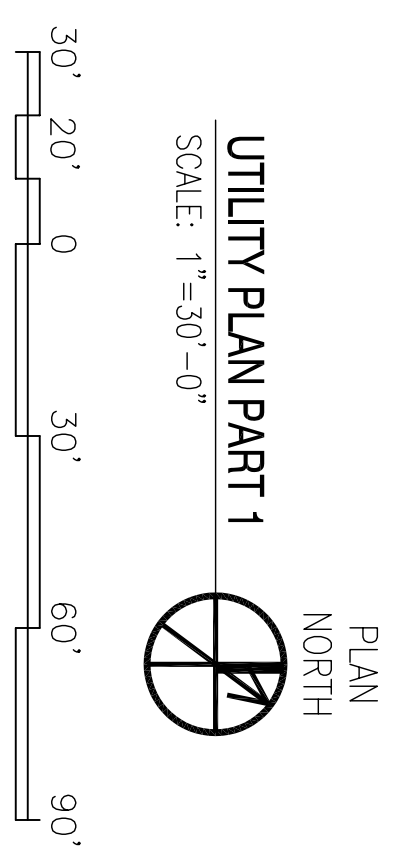

RECORD DRAWING
LETTER DATED -
5-27-10



DEPARTMENT OF THE NAVY NAVAL FACILITIES ENGINEERING COMMAND SOUTHEAST NAVAL AIR STATION JACKSONVILLE JOHN C. STENNIS SPACE CENTER MISSISSIPPI SOF RIVERINE AND COMBATANT CRAFT OPERATIONS FACILITY - PRE-FINAL UTILITY PLAN PART 1		DAMMON ENGINEERING, INC. ENGINEER CHEF ENGINEER DAMMON, P. C. (LIC. 14538) SIBOLL, L. A. (LIC. 7858) (985) 649-4312 SEPTEMBER 4, 2009				AS-BUILT CONDITIONS SHOWN REVISED FOR FINAL REVISED AS PER URS COMMENTS 9 OCTOBER 2009	3-12-10 12-7-09 11-6-09	RW RW
CODE ID NO. N4412 SCALE: AS SHOWN SHEET: 28 OF 132 CONSTR. CONTR. NO. N62467-05-0-0096 WORK ORDER NO. 510247 NAVFAC DRAWING NO. 15026673	PROJECT NO. P-210 SHEET NO. 510247	DESIGNED BY: R. WILSON DRAWN BY: J. HERRMAN CHECKED BY: T. ARBIB PROJECT MANAGER: P. DAMMON	REGISTERED PROFESSIONAL ENGINEER STATE OF LOUISIANA LICENSE NO. 2136 EXPIRES 5-27-10	REGISTERED PROFESSIONAL ENGINEER STATE OF MISSISSIPPI LICENSE NO. 9862 EXPIRES 5-27-10	DATE APPR	DESCRIPTION	DATE APPR	