

FY2008 MILCON P-210 N4412


SOF RIVERINE AND COMBATANT CRAFT OPERATIONS FACILITY

JOHN C. STENNIS SPACE CENTER MISSISSIPPI

FINAL SUBMITTAL

SEPTEMBER 4, 2009

RECORD DRAWING
LETTER DATED -
5-27-10

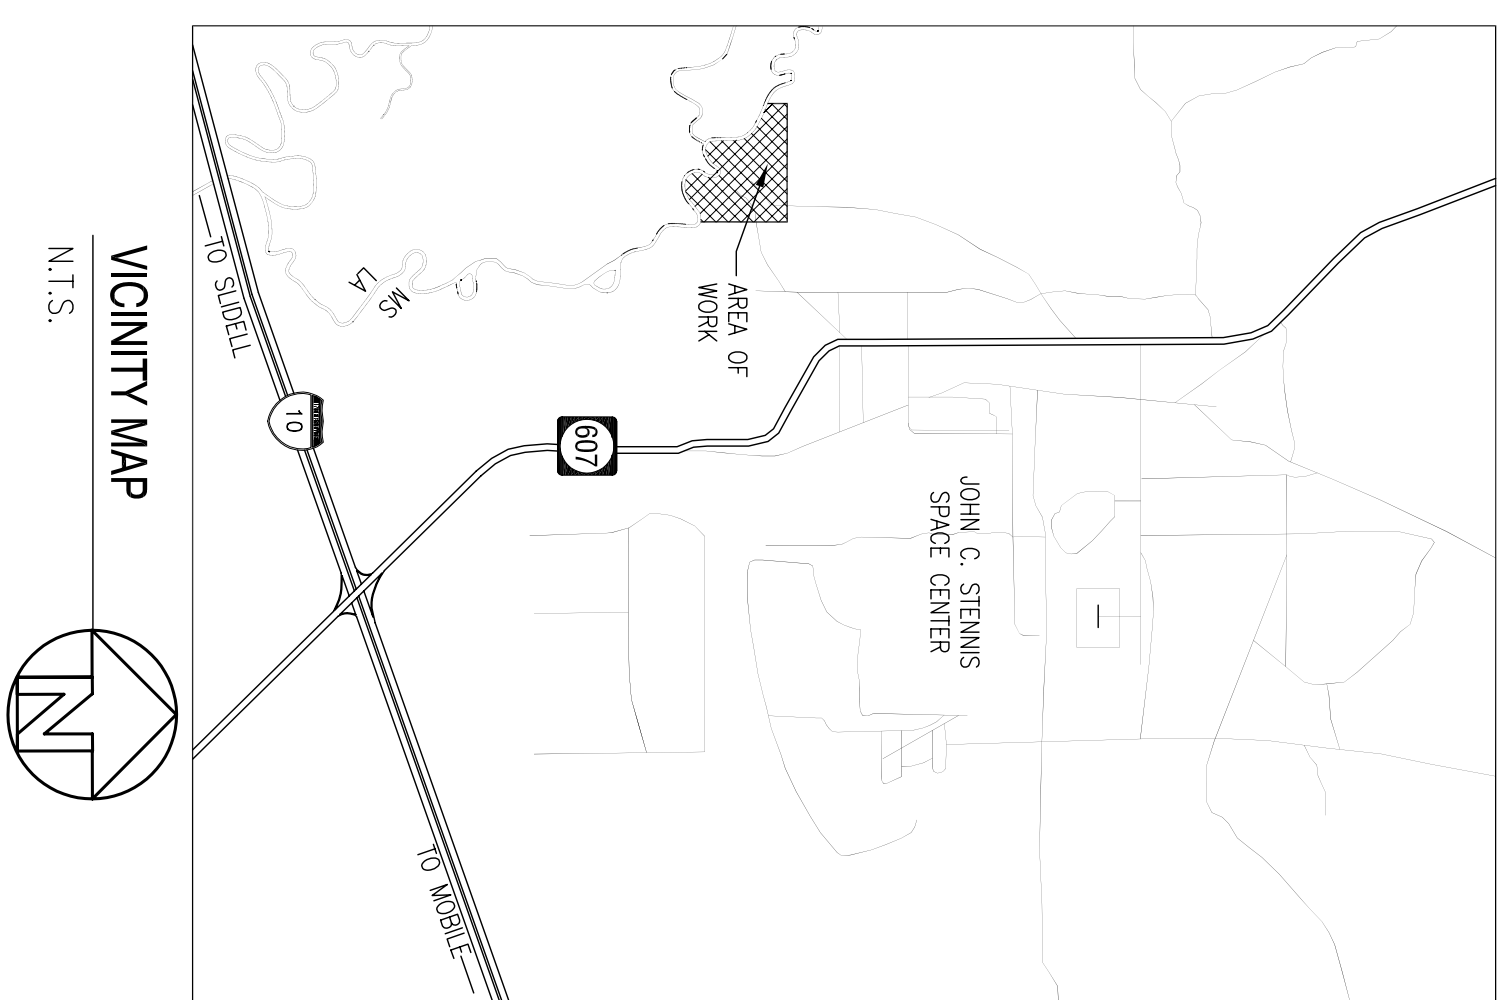

RECORD DRAWINGS INCLUDE AS-BUILT CONDITIONS AND MAY NOT MATCH THE ORIGINAL CONTRACT DRAWING SHEETS.

INDEX OF DRAWINGS


#	DAMCON DWG#	NAV/FAC DWG#	DRAWING NAME	REVISED
1	T-1	15026648	TITLE SHEET	
2	T-2	15026649	DRAWING INDEX	
3	T-3	15026650	IBC REVIEW	
4	LS-1	15026651	OPS. / MAINT. BLDG. FIRST & SECOND FLOOR LIFE SAFETY PLAN	
5	LS-2	15026652	BOAT STORAGE LIFE SAFETY PLAN	
6	C1.0	15026653	CIVIL GENERAL PROJECT NOTES & TITLE SHEET	
7	C1.1	15026654	OVERALL SITE PLAN	
8	C1.2	15026655	SITE PLAN PART 1	
9	C1.3	15026656	SITE PLAN PART 2	
10	C1.4	15026657	SITE CIVIL DETAILS	
11	C1.5	15026658	SITE CIVIL DETAILS	
12	C1.6	15026659	SITE CIVIL DETAILS	
13	C2.1	15026660	OVERALL DRAINAGE PLAN	
14	C2.2	15026661	DRAINAGE PLAN PART 1	
15	C2.3	15026662	DRAINAGE PLAN PART 2	
16	C2.4	15026663	DRAINAGE DETAILS	
17	C3.1	15026664	PAVING PLAN PART 1	
18	C3.2	15026665	PAVING PLAN PART 2	
19	C3.3	15026666	ENLARGED VEHICLE / PEDESTRIAN ENTRANCE	
20	C3.4	15026667	PAVING DETAILS	
21	C4.1	15026668	LANDSCAPING PLAN PART 1	
22	C4.2	15026669	LANDSCAPING PLAN PART 2	
23	C5.1	15026670	STORM WATER POLLUTION PREVENTION PLAN (SWPPP) PART 1	
24	C5.2	15026671	STORM WATER POLLUTION PREVENTION PLAN (SWPPP) PART 2	
25	C6.1	15026672	OVERALL UTILITY PLAN	
26	C6.2	15026673	UTILITY PLAN PART 1	
27	C6.3	15026674	UTILITY PLAN PART 2	
28	C6.4	15026675	UTILITY PLAN PART 3	
29	C6.5	15026676	UTILITY DETAILS	
30	A1.0	15026677	ARCHITECTURAL GENERAL NOTES & TITLE SHEET	
31	A1.1	15026678	OPS./MAINT. BLDG. 2440/2441 FIRST FLOOR PLAN	
32	A1.2	15026679	OPERATIONS BLDG. 2440 SECOND FLOOR PLAN	
33	A1.3	15026680	OPERATIONS BLDG. 2440 SECTION	
34	A1.4	15026681	OPERATIONS BLDG. 2440 SECTION	
35	A1.5	15026682	MAINTENANCE BLDG. 2441 SECTION	
36	A1.6	15026683	TYPICAL SECTIONS AND DETAILS	
37	A1.7	15026684	DOOR, WINDOW & FINISH SCHEDULES	
38	A1.8	15026685	OPS./MAINT. BLDG. 2440/2441 ELEVATIONS	
39	A1.9	15026686	OPS./MAINT. BLDG. 2440/2441 ELEVATIONS	
40	A1.10	15026687	OPS./MAINT. BLDG. 2440/2441 1ST FLOOR REFLECTED CEILING PLAN	
41	A1.11	15026688	OPERATIONS BLDG. 2440 2ND FLOOR REFLECTED CEILING PLAN	
42	A1.12	15026689	ENLARGED FLOOR PLAN MALE/FEMALE HEADS	
43	A1.13	15026690	ENLARGED INTERIOR STAIR & VESTIBULE PLAN	
44	A1.14	15026691	OPS./MAINT. BLDG. 2440/2441 ROOF PLAN	
45	A1.15	15026692	BLDG. 2440/2441 INTERIOR ELEVATIONS	
46	A1.16	15026693	BLDG. 2440/2441 INTERIOR ELEVATIONS	
47	A1.17	15026694	BLDG. 2440/2441 INTERIOR ELEVATIONS	
48	A1.18	15026695	BLDG. 2440/2441 DOOR ELEVATIONS	
49	A1.19	15026696	BLDG. 2440/2441 WINDOW/DOOR ELEVATIONS	
50	A1.20	15026697	BLDG. 2440/2441 DOOR DETAILS	

INDEX OF DRAWINGS

#	DAMCON DWG#	NAV/FAC DWG#	DRAWING NAME	REVISED
51	A1.21	15026698	BLDG. 2440/2441 DOOR DETAILS	
52	A1.22	15026699	BLDG. 2440/2441 WINDOW DETAILS	
53	A1.23	15026700	BLDG. 2440/2441 BLDG. DETAILS	
54	A2.1	15026701	BOAT STORAGE BLDG. 2442 FLOOR PLAN	
55	A2.2	15026702	BOAT STORAGE BLDG. 2442 SECTION	
56	A2.3	15026703	DOOR, WINDOW & FINISH SCHEDULES	
57	A2.4	15026704	BOAT STORAGE BLDG. 2442 ELEVATIONS	
58	A2.5	15026705	BOAT STORAGE BLDG. 2442 ELEVATIONS	
59	A2.6	15026706	BOAT STORAGE BLDG. 2442 ROOF PLAN	
60	A2.7	15026707	BLDG. 2442 DOOR/WINDOW ELEVATIONS	
61	A2.8	15026708	BLDG. 2442 BLDG. DETAILS	
62	CID-1	15026709	FIRST FLOOR FURNITURE PLAN	
63	CID-2	15026710	SECOND FLOOR FURNITURE PLAN	
64	CID-3	15026711	CAGE PLAN, DETAILS AND ELEVATIONS	
65	CID-4	15026712	INTERIOR ELEVATIONS	
66	SID-1	15026713	FIRST FLOOR SID PLAN	
67	SID-2	15026714	SECOND FLOOR SID PLAN, FINISH SCHEDULE	
68	SID-3	15026715	RESTROOM FLOOR FINISH PLAN, DETAILS	
69	SID-4	15026716	INTERIOR ELEVATIONS	
70	S1.0	15026717	STRUCTURAL TITLE SHEET	
71	S1.1	15026718	OPERATIONS BLDG. 2440 FOUNDATION PLAN	
72	S1.2	15026719	OPERATIONS BLDG. 2440 MODIFIED CAGE & PLUMBING LAYOUT	
73	S1.3	15026720	MAINTENANCE BLDG. 2441 FOUNDATION PLAN	
74	S1.4	15026721	MAINTENANCE BLDG. 2441 MODIFIED PLUMBING LAYOUT	
75	S2.1	15026722	STORAGE BLDG. 2442 FOUNDATION PLAN	
76	S2.2	15026723	BOAT STORAGE BLDG. 2442 CATHKAK FRAMING PLAN	
77	S3.1	15026724	ARMORY/EO. MEZZANINE STRUCTURAL FRAMING PLAN	
78	S3.2	15026725	OPS./MAINT. 2440/2441 MASONRY PLAN	
79	S3.3	15026726	MASONRY DETAILS	
80	S3.4	15026727	CONTROL WATCH WINDOW DETAILS	
81	S4.1	15026728	STRUCTURAL DETAILS	
82	S4.2	15026729	STRUCTURAL DETAILS	
83	S4.3	15026730	STRUCTURAL DETAILS	
84	M1.0	15026731	MECHANICAL LEGEND & SCHEDULES	
85	M1.1	15026732	OPERATIONS BUILDING FIRST FLOOR HVAC PLAN	
86	M1.2	15026733	OPERATIONS BUILDING SECOND FLOOR HVAC PLAN	
87	M2.1	15026734	BOAT STORAGE BUILDING HVAC PLAN	
88	M3.0	15026735	MECHANICAL DETAILS	
89	M3.1	15026736	ENLARGED MECHANICAL PLANS	
90	M4.1	15026737	CONTROL SYSTEM DRAWINGS	
91	M4.2	15026738	CONTROL SYSTEM DRAWINGS	
92	M4.3	15026739	CONTROL SYSTEM DRAWINGS	
93	M4.4	15026740	CONTROL SYSTEM DRAWINGS	
94	P1.0	15026741	PLUMBING LEGEND, SCHEDULES, AND DETAILS	
95	P1.1	15026742	OPERATIONS BUILDING FIRST FLOOR PLUMBING PLAN	
96	P1.2	15026743	OPERATIONS BUILDING SECOND FLOOR PLUMBING PLAN	
97	P2.1	15026744	BOAT STORAGE BUILDING PLUMBING PLAN	
98	E1.0	15026745	ELECTRICAL TITLE SHEET	
99	E1.1	15026746	ONE-LINE DIAGRAM	
100	E1.2	15026747	PANEL SCHEDULES	

INDEX OF DRAWINGS

#	DAMCON DWG#	NAV/FAC DWG#	DRAWING NAME	REVISED
101	E1.3	15026748	PANEL SCHEDULES	
102	E1.4	15026749	PANEL SCHEDULES	
103	E1.5	15026750	ELECTRICAL DETAILS	
104	E1.6	15026751	ELECTRICAL DETAILS	
105	E1.7	15026752	ELECTRICAL DETAILS	
106	E2.1	15026753	SITE PLAN - LIGHTING	
107	E2.2	15026754	SITE PLAN - POWER	
108	E2.3	15026755	SITE PLAN - SPECIAL SYSTEMS	
109	E2.4	15026756	SITE PLAN - INFRASTRUCTURE	
110	E3.1	15026757	BLDG. 2440/2441 1ST FLOOR - LIGHTING	
111	E3.2	15026758	BLDG. 2440 2ND FLOOR - LIGHTING	
112	E3.3	15026759	BLDG. 2442 FLOOR PLAN - LIGHTING	
113	E4.1	15026760	BLDG. 2440/2441 1ST FLOOR PLAN - POWER	
114	E4.2	15026761	BLDG. 2440 2ND FLOOR PLAN - POWER	
115	E4.3	15026762	BLDG. 2442 FLOOR PLAN - POWER	
116	E5.1	15026763	BLDG. 2440/2441 1ST FLOOR - TELECOMMUNICATIONS	
117	E5.2	15026764	BLDG. 2440 2ND FLOOR PLAN - TELECOMMUNICATIONS	
118	E5.3	15026765	BLDG. 2442 FLOOR PLAN - TELECOMMUNICATIONS	
119	E5.4	15026766	TELECOMMUNICATIONS RISER DIAGRAM	
120	E6.1	15026767	BLDG. 2440/2441 1ST FLOOR - SECURITY	
121	E6.2	15026768	BLDG. 2440 2ND FLOOR PLAN - SECURITY	
122	E6.3	15026769	BLDG. 2442 FLOOR PLAN - SECURITY	
123	E6.4	15026770	SECURITY RISER DIAGRAMS	
124	FP-1	15026771	UNDERGROUND & KEY PLAN GENERAL NOTES	
125	FP-2	15026772	BOAT STORAGE BLDG. 2442 PLAN	
126	FP-3	15026773	OPERATIONS BLDG. 2440 / 2441 1ST FLOOR PLAN	
127	FP-4	15026774	OPERATIONS/MAINTENANCE BLDG. 2440 / 2441 2ND FLOOR PLAN	
128	FP-5	15026775	RISER DETAIL FOR BUILDING 2440/2441 & SEMIC DETAILS & NOTES	
129	FA1.0	15026776	FIRE ALARM RISER DIAGRAMS AND SCHEDULES	
130	FA1.1	15026777	BLDG. 2440/2441 1ST FLOOR - FIRE ALARM	
131	FA1.2	15026778	BLDG. 2440 2ND FLOOR PLAN - FIRE ALARM	
132	FA1.3	15026779	BLDG. 2442 FLOOR PLAN - FIRE ALARM	
133		15026780		
134		15026781		
135		15026782		
136		15026783		
137		15026784		
138		15026785		
139		15026786		
140		15026787		
141		15026788		
142		15026789		
143		15026790		
144		15026791		
145		15026792		
146				
147				
148				
149				
150				

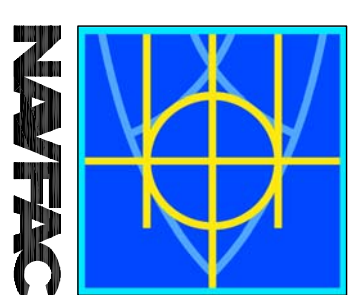

DAMCON
ENGINEERING, INC.
CHIEF ENGINEER: CHRIS WILSE
DAMCON, P.E., 800 AIRSIDE
SUITE 111, LA 70538
(985) 649-5552
SEPTEMBER 4, 2009



DES. R. WILSE / PROJ. J. FRANK
REVIEWED BY: R. WILSE
PROJECT: T. ARBER
CHIEF ENGINEER: P. DAMCON

DEPARTMENT OF THE NAVY NAVAL FACILITIES ENGINEERING COMMAND SOUTHEAST 1FT GULF COAST	NAVAL FACILITIES ENGINEERING COMMAND NAVAL AIR STATION JACKSONVILLE MISSISSIPPI
JOHN C. STENNIS SPACE CENTER	
SOF RIVERINE AND COMBATANT CRAFT OPERATIONS FACILITY - PRE-FINAL	
DRAWING INDEX	
DATE: 01 JAN 2009	SHEET: 2 OF 132