
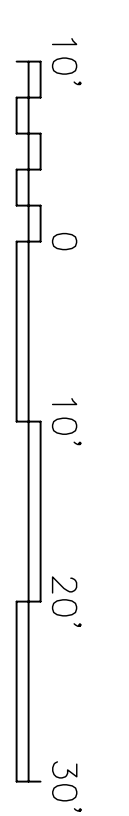


**OPS. / MAINT. BLDG.  
2440/2441 FIRST FLOOR PLAN**  
SCALE: 3/32" = 1'-0"  
PLAN NORTH

- KEY NOTES:**
- 1 COLUMN BY METAL BLDG. MFGR.
  - 2 SEE ENLARGED FLOOR PLANS OF MALE AND FEMALE HEADS ON SHIT. A1.12.
  - 3 SEE ENLARGED DETAIL OF STAIR 115 AND VESTIBULE 116 ON SHIT A1.13.
  - 4 PASSAGE LOCKS FOR SHOWER AND HEADS. PROVIDE PRIVACY LOCKS FOR ROOMS 108, 109 AND 212.
- FIRE PROTECTION SYMBOLS**
- (WB) - FIRE EXTINGUISHER ON WALL BRACKET
  - (FC) - FIRE EXTINGUISHER IN RECESSED CABINET

**NOTE:**  
SEE TYP. INT. WALL SECTIONS, SHIT A1.6

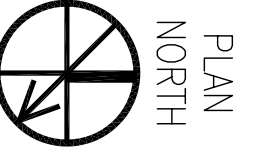


ROOM #	ROOM NAME	SQ. FT.
100	CANOPY ENTRANCE	NA/44'
101	REAR ENTRY	NA/20'
102	ENTRY	1207/114'
103	LOBBY	NA/315'
104	SIDE ENTRY	NA/45'
105	CAGES	3825/4516'
106	CSS	1207/220'
107	ARMORY	1500/1484'
108	SHOWER	51/77'
109	HEAD	37/66'
110	JANITOR	32/100'
111	MALE HEAD	2707/204'
112	MALE SHOWER	1807/191'
113	ELECTRICAL	1497/158'
114	MECHANICAL	1207/130'
115	STAIRS	400/267'
116	VESTIBULE	NA/66'
200	CORRIDOR	NA/983'
201	TEL. COMM.	1207/148'
202	RADIO ROOM	2027/197'
203	BRIEFING	9787/1025'
204	RUOC	3607/395'
205	RUOC	6607/339'
206	RUOC	6607/339'
207	RIVER OPS CONTROL WATCH	3007/205'
208	SITUCO	3607/389'
209	RUCO	4807/855'
210	RUOC	3607/399'
211	RUOC	6607/324'
212	MALE HEAD	2707/197'
213	FEMALE HEAD	367/327'
214	MECHANICAL/ELECTRICAL ROOM	1207/327'
215	JANITOR	357/311'
216	STAIRS	4007/267'
217	COPY AREA	NA/74'
218	CHART ROOM	NA/122'

DEPARTMENT OF THE NAVY  
NAVAL FACILITIES ENGINEERING COMMAND SOUTHEAST  
NAVAL AIR STATION JACKSONVILLE  
MISSISSIPPI  
JOHN C. STENNIS SPACE CENTER  
**SOF RIVERINE AND COMBATANT CRAFT OPERATIONS FACILITY - PRE-FINAL**  
OPS./MAINT. BLDG. 2440/2441 1ST FLR. PLAN

DESIGNED BY: R. WITTE  
DRAWN BY: J. JEFFREY  
CHECKED BY: R. WITTE  
DATE: SEPTEMBER 4, 2008

**DAMMON ENGINEERING, INC.**  
REGISTERED PROFESSIONAL ENGINEER  
STATE OF MISSISSIPPI  
NO. 44382  
1000 N. WILSON AVE.  
SUITE 100  
MOBILE, LA 70002  
(980) 649-8332

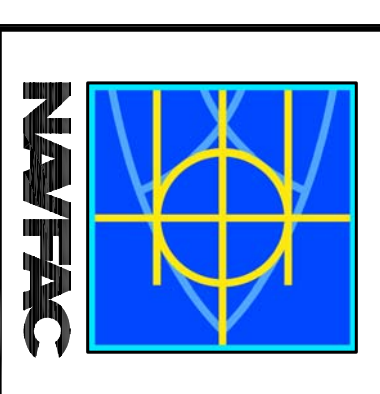

SYM	DESCRIPTION	DATE	APPR



STATE OF LOUISIANA  
REGISTERED PROFESSIONAL ENGINEER  
ROBERT LEE WALTER  
LICENSE NO. 2988  
NO. 210  
P-210  
510247  
NAVFAC DRAWING NO. 15006678  
DATE: 31 OCT 132