



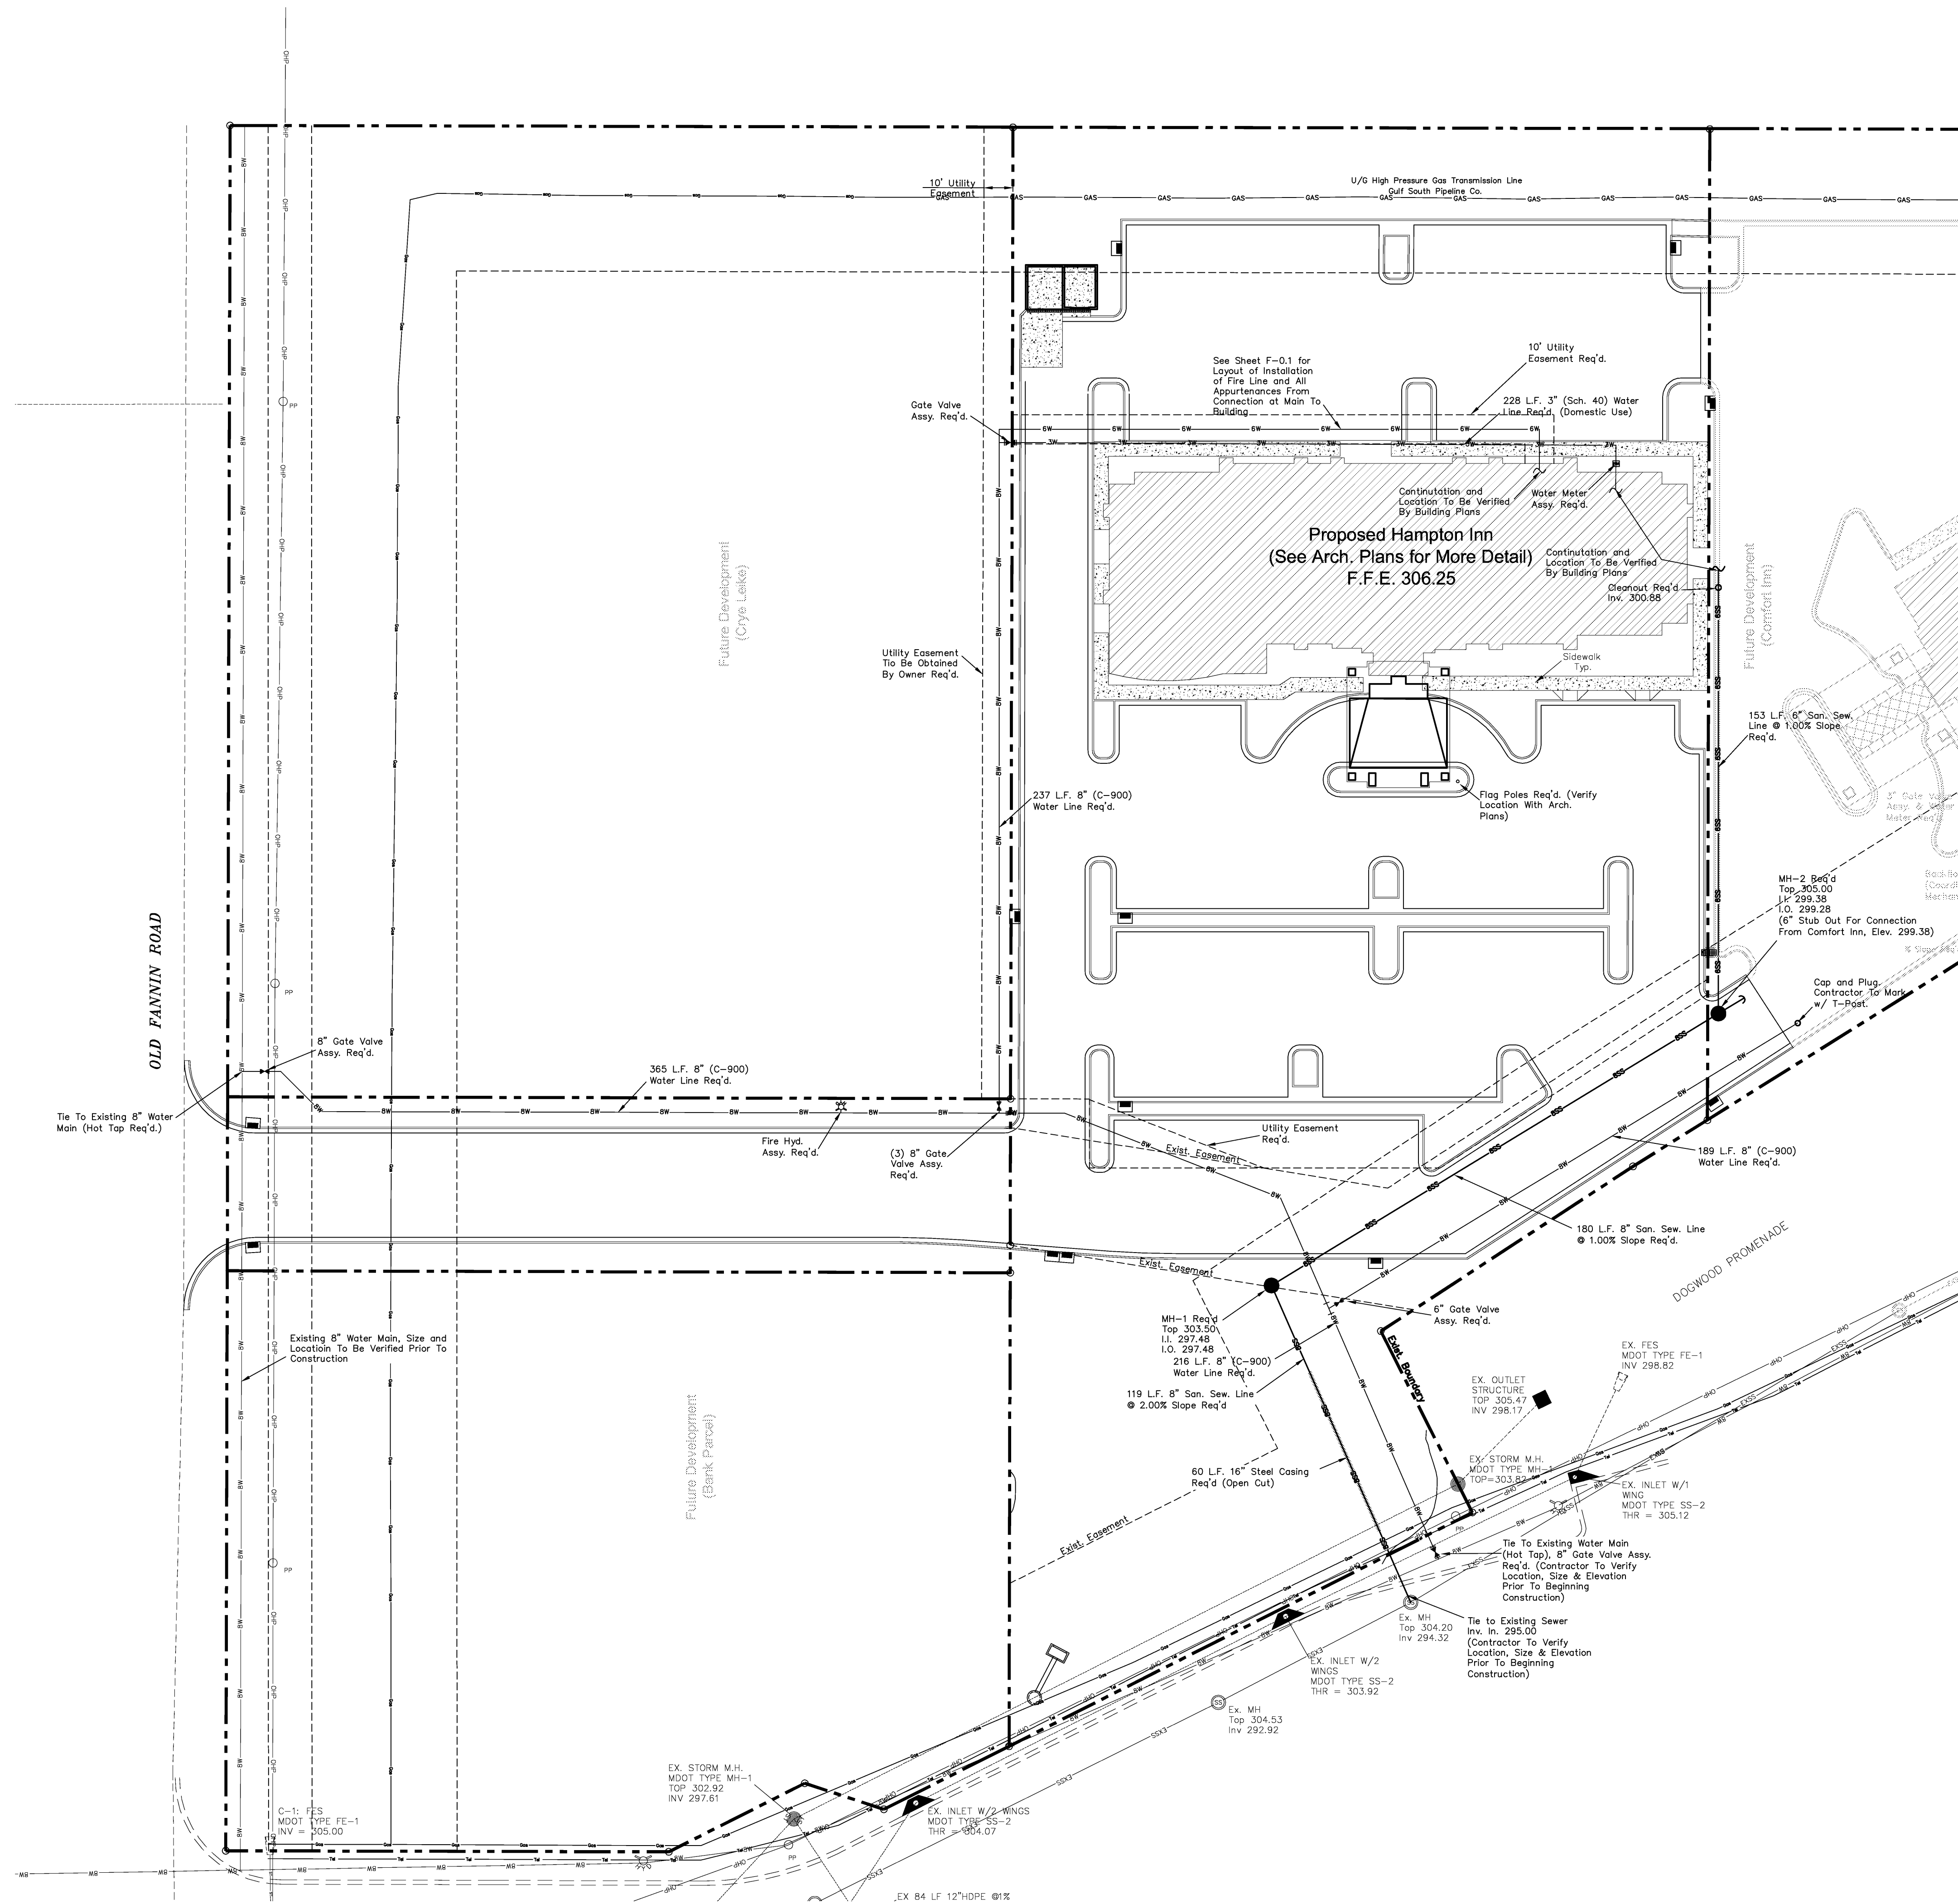

- LEGEND**
- PROPOSED SEWER MANHOLE
PROPOSED CURB INLET, DBL. INLET, GRATE INLET
PROPOSED FIRE HYDRANT ASSEMBLY
PROPOSED GATE VALVE ASSEMBLY
PROPOSED 8" WATER MAIN
PROPOSED 8" SANITARY SEWER MAIN
PROPOSED STORM DRAIN CULVERT
EXISTING WATER MAIN
EXISTING SANITARY SEWER MAIN
EXISTING STORM DRAIN CULVERT
EXISTING SEWER MANHOLE
EXISTING CURB INLET, DBL. INLET, GRATE INLET
EXISTING FIRE HYDRANT ASSEMBLY
EXISTING GATE VALVE ASSEMBLY

--- : PROPERTY LINE
--- : EXISTING EASEMENT

- NOTES:
- SEE NOTES ON SHEET C1.1 FOR MORE INFORMATION.
 - CONTRACTOR TO COORDINATE UTILITY CROSSINGS WITH UTILITY COMPANIES.
 - CONTRACTOR TO COORDINATE WATER AND SEWER SERVICE LOCATIONS WITH THE BLDG. PLANS AND TO CONFIRM THE WATER MAIN SIZE & SERVICE LINES WITH THE BLDG. PLANS.
 - CONTRACTOR TO COORDINATE WATER AND SEWER CONNECTIONS TO MAIN LINES WITH THE CITY OF FLOWOOD.
 - FIRE PROTECTION AND IRRIGATION AND ANY APPURTENANCES REQUIRED BY EITHER SYSTEM TO BE DESIGNED BY OTHERS (i.e. SPRINKLER SYSTEM, SIAMESE CONNECTIONS, ETC.).
 - LOCATIONS OF WATER AND SEWER STUB OUTS FOR THE PROPOSED ADJACENT COMFORT INN TO BE COORDINATED WITH THE UTILITY/PLUMBING PLANS FOR THAT SITE.
 - ALL UTILITY LINES THAT ARE SHOWN IN EASEMENTS OR RIGHT-OF-WAY ARE TO BE PUBLIC WITH THE EXCEPTION OF THE DOMESTIC WATER LINE WHICH WILL BE PRIVATE FROM THE POINT OF CONNECTION WITH THE MAIN LINE TO THE BUILDING. ALL UTILITY LINES THAT ARE NOT SHOWN IN EASEMENTS ARE TO BE PRIVATE.

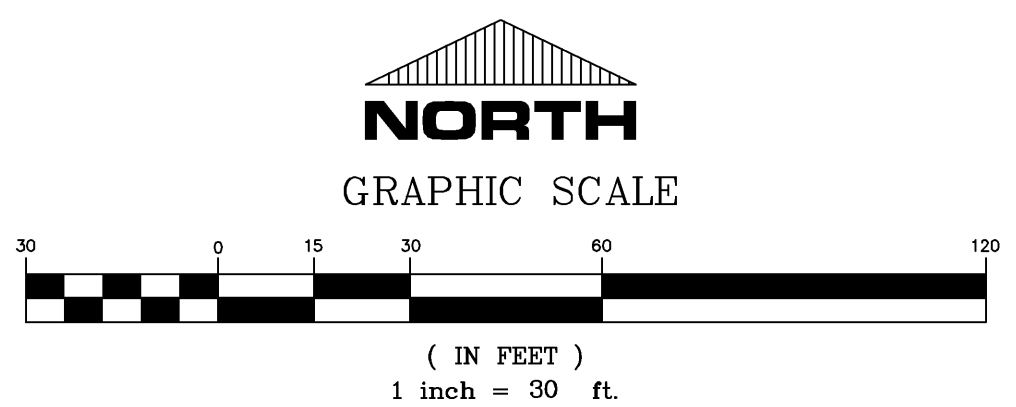

THE DRAWING AND SPECIFICATIONS SHALL BE THE PROPERTY OF BENCHMARK ENGINEERING & SURVEYING, LLC. NO PART OF THIS DRAWING OR SPECIFICATIONS IS TO BE REPRODUCED OR TRANSMITTED IN ANY FORM OR BY ANY MEANS, ELECTRONIC OR MECHANICAL, INCLUDING PHOTOCOPYING, RECORDING, OR BY ANY INFORMATION STORAGE AND RETRIEVAL SYSTEM, WITHOUT THE WRITTEN PERMISSION OF BENCHMARK ENGINEERING & SURVEYING, LLC. ANY UNAUTHORIZED REPRODUCTION OR TRANSMISSION OF THIS DRAWING OR SPECIFICATIONS IS PROHIBITED AND WILL BE CONSIDERED A VIOLATION OF THE COPYRIGHT LAWS OF THE UNITED STATES OF AMERICA.

BENCHMARK
Engineering & Surveying, LLC
132-B Northside Drive
Bogalusa, Mississippi 39042
Office: 601-225-8577 • Fax: 601-225-8577
e-mail: benchmarkms@earthlink.net

DATE: 10/11/07
DRAWN: DTS
ALIGN:
REVISED:

PROJECT: **HAMPTON INN**
FLOWOOD, MS

CONTENTS: **UTILITY LAYOUT**

16335

STATE OF MISSISSIPPI
REGISTERED PROFESSIONAL ENGINEER

SHEET NUMBER
C3.1
PROJECT NUMBER
B-1347