


FIRST FLOOR REFLECTED CEILING PLAN
SCALE: 1/8"=1'-0"

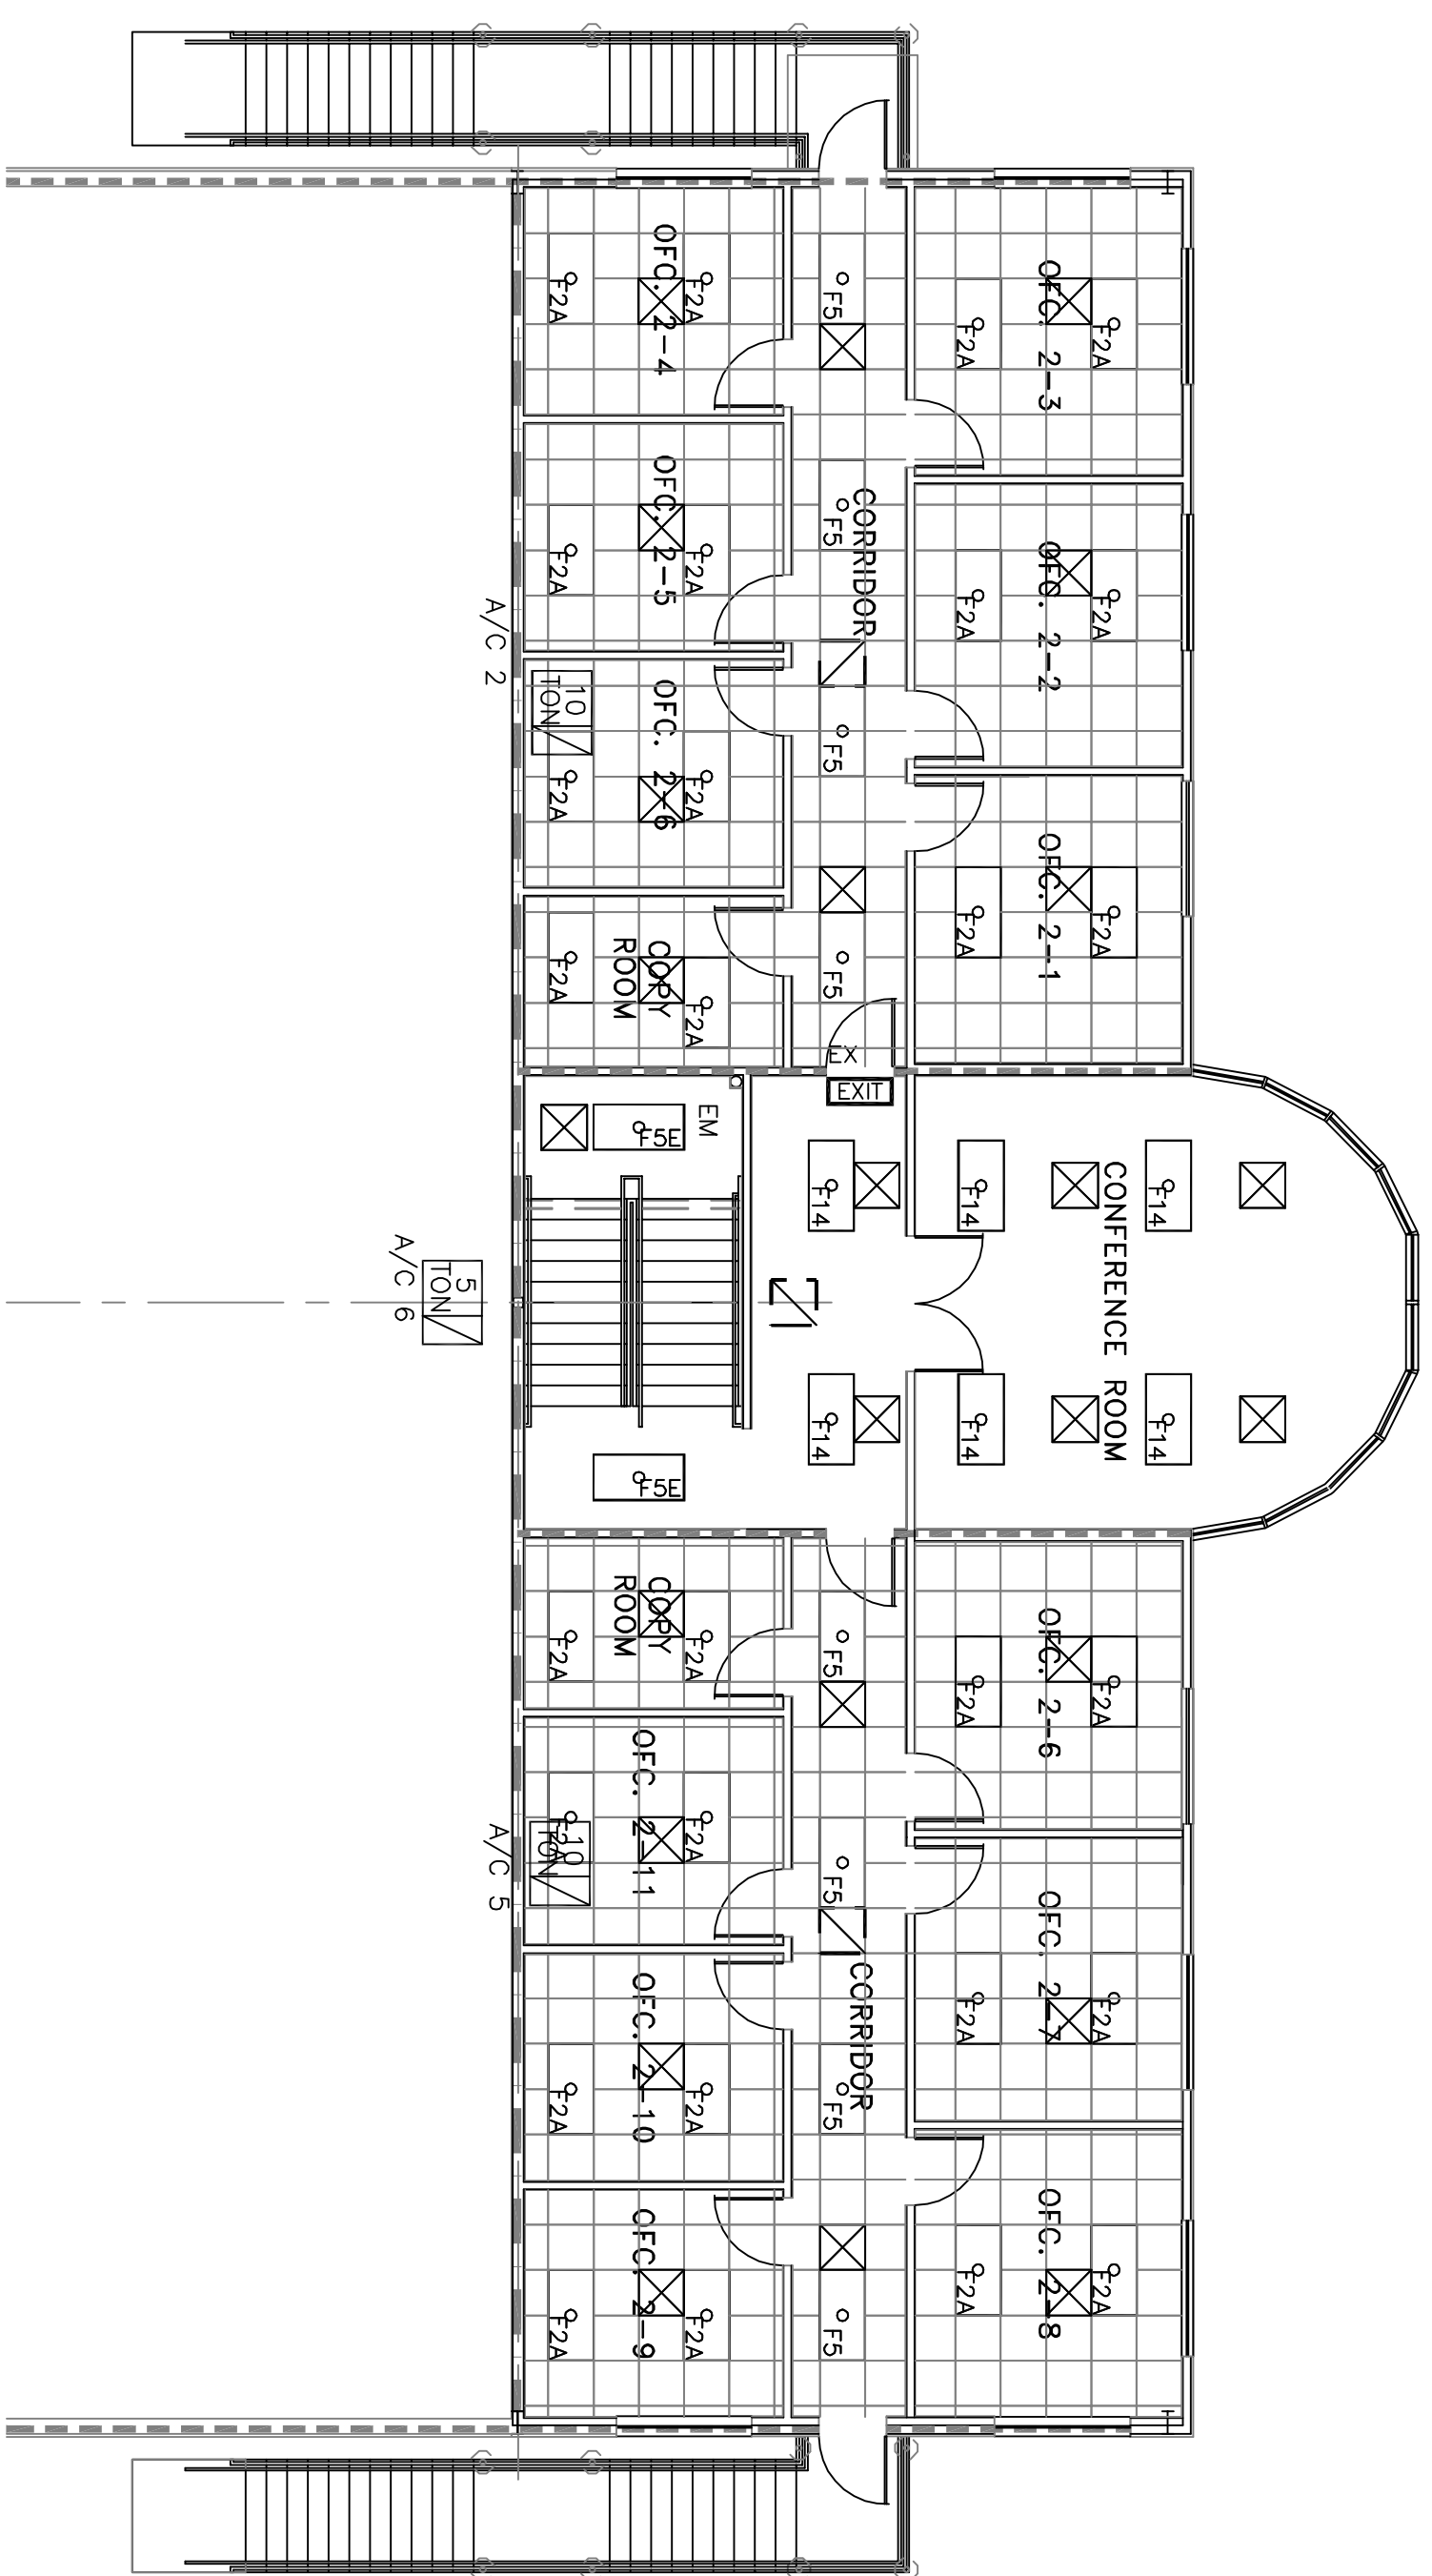

SECOND FLOOR REFLECTED CEILING PLAN
SCALE: 1/8"=1'-0"

NOTE:
CONTRACTOR/OWNER TO VERIFY EQUIPMENT,
UTILITY TIE-INS AND ELECTRICAL LOCATIONS
PRIOR TO START OF CONSTRUCTION

LEGEND

- - 2 X 2 CEILING GRID
- F2 - 2 X 4 FLUORESCENT LIGHT FIXTURE
- ⊠ - 2 X 2 SUPPLY AIR DUCT
- F/A - 2 X 2 RETURN AIR DUCT

REFLECTED CEILING PLAN

PLATFORM CRANE SERVICE
DOSS DRIVE
SLIDELL, LOUISIANA

OFFICE/WAREHOUSE

DAMMON ENGINEERING, INC.

1095 FLORIDA AVENUE 985-649-5832 SLIDELL, LA. 70458
DAMMONENGINEERING.COM

SCALE:AS NOTED

FILE:

JOB NO.1842

DATE:03-14-07

SHEET

A-4

OF