



FILE NAME: J:\1 - 2023\101 - Main - 01.dwg Plot Date: 3/16/2023 11:30:05

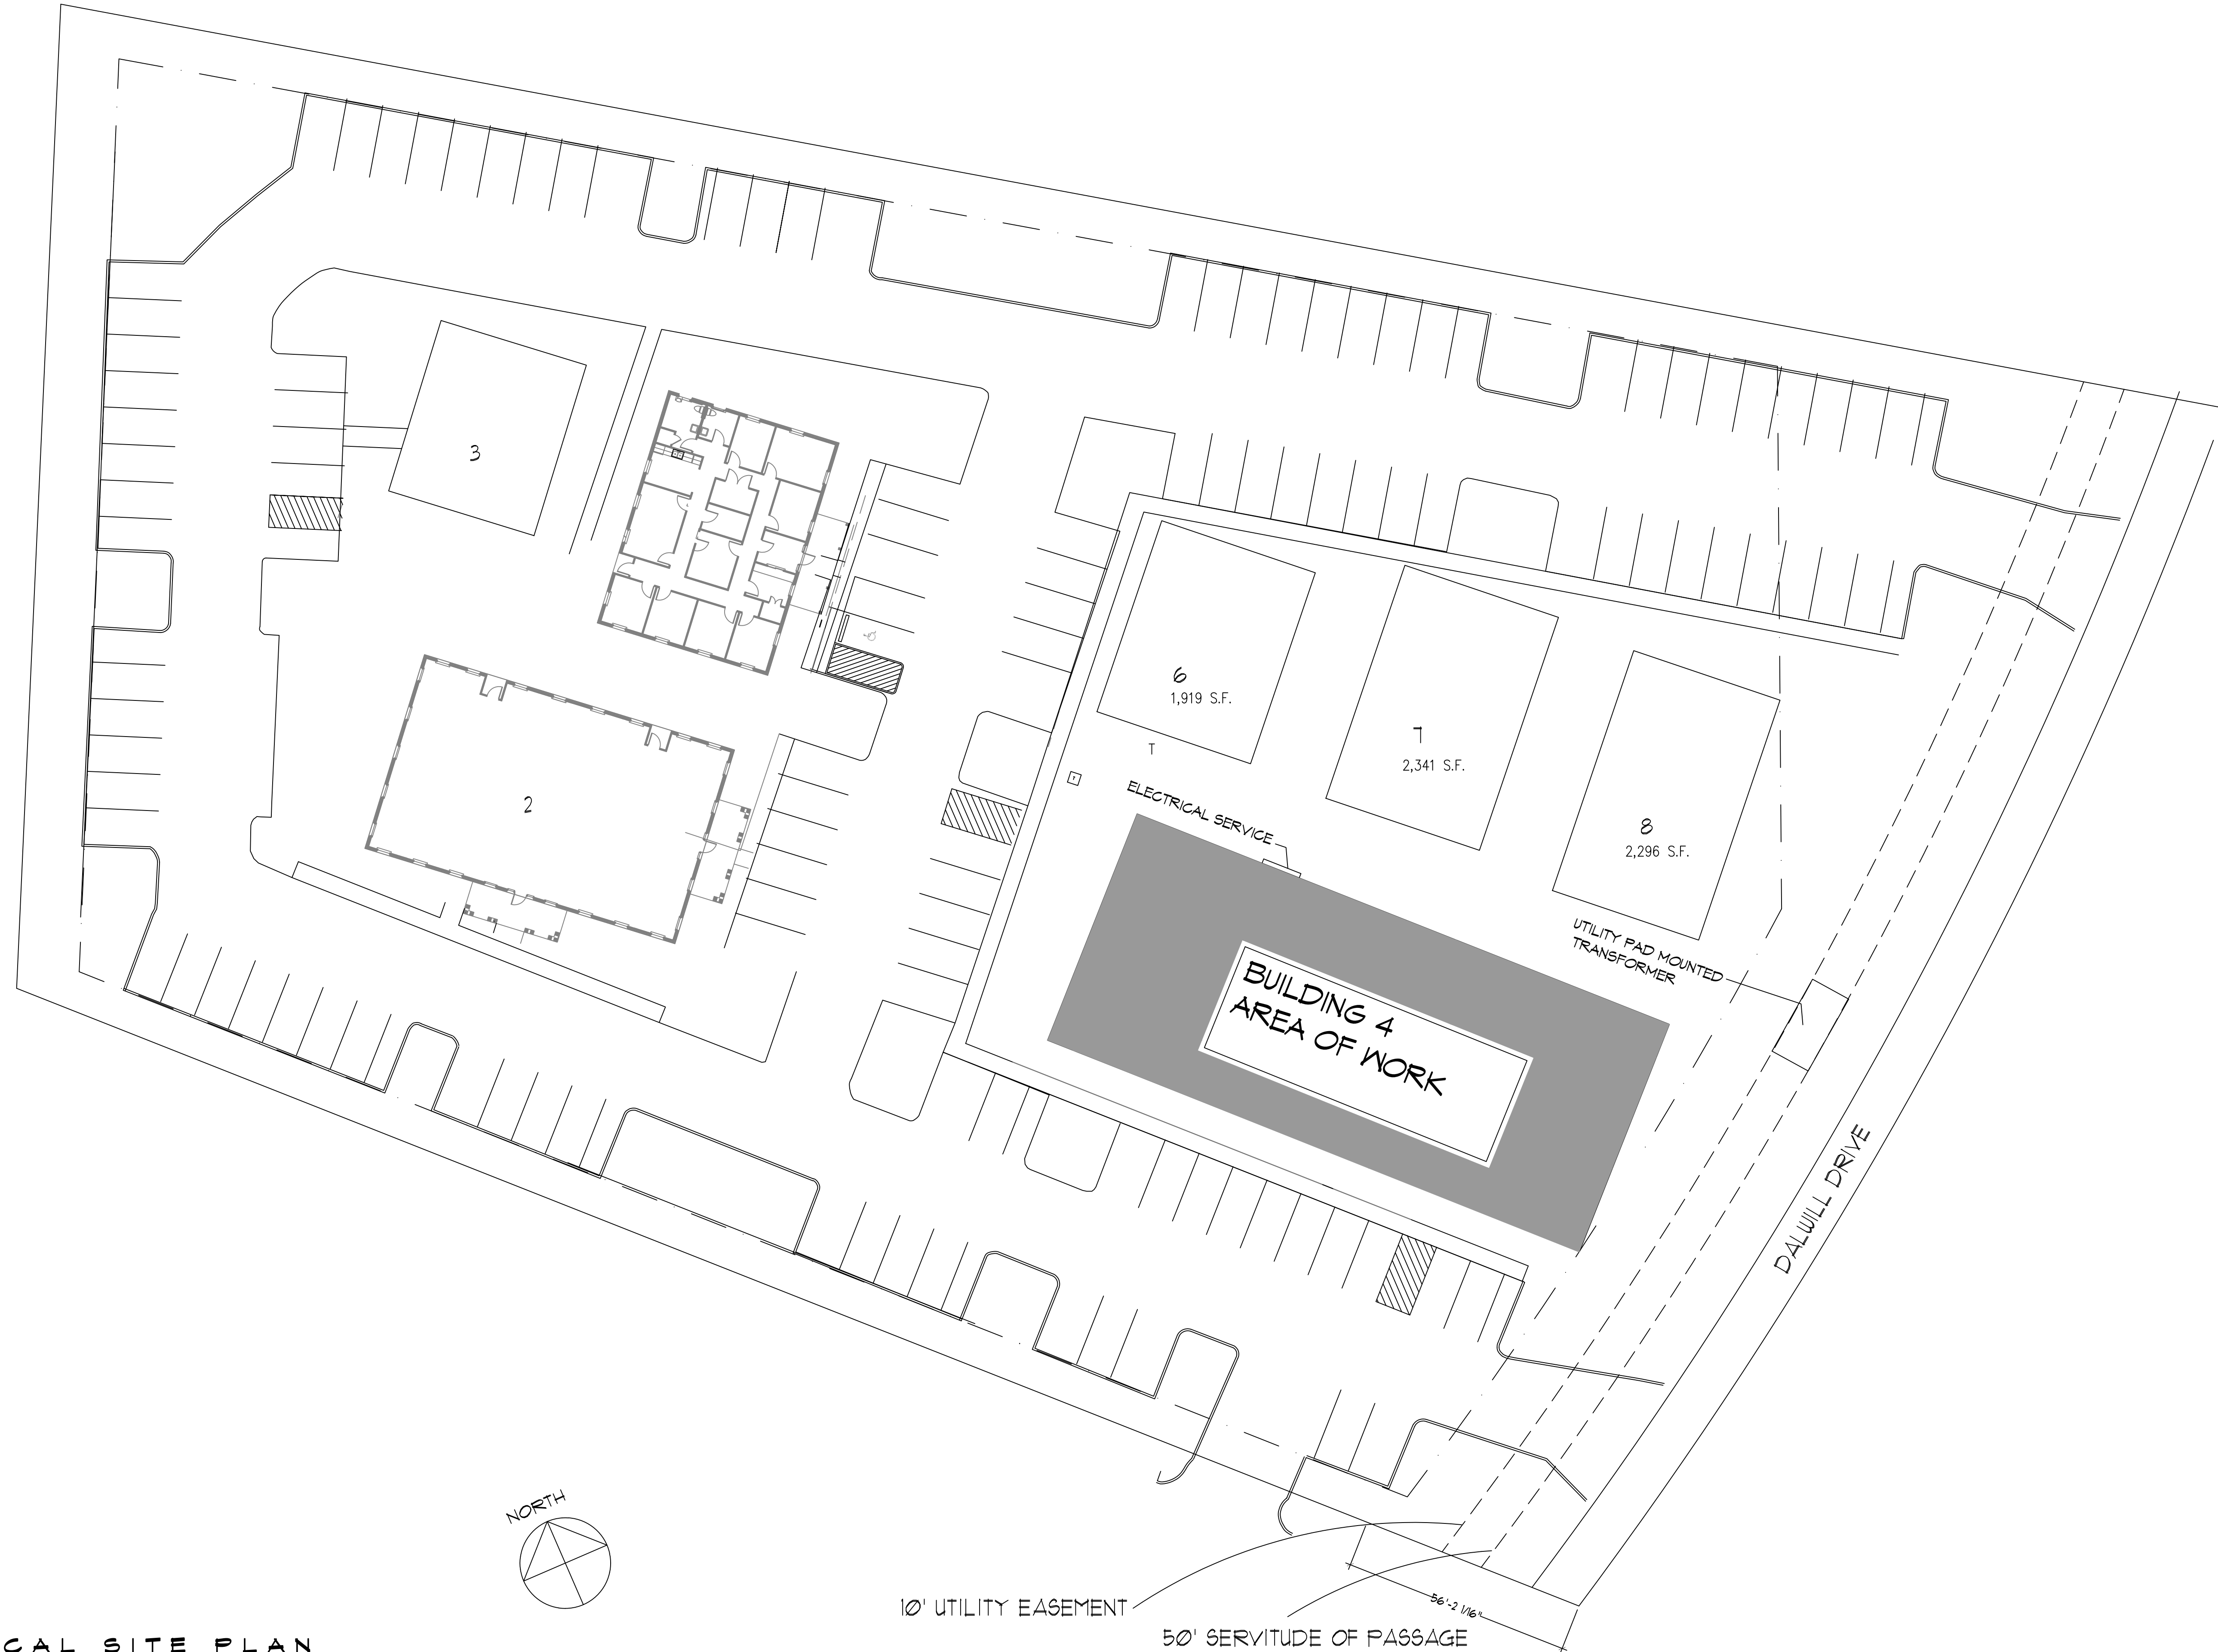

1 ELECTRICAL SITE PLAN
SCALE: 1" = 20'-0"

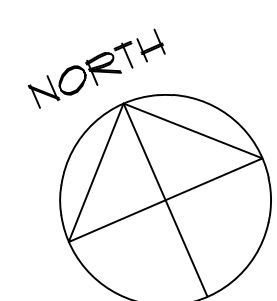

10' UTILITY EASEMENT
50' SERVITUDE OF PASSAGE
56'-2 1/16"

DAMMON
ENGINEERING, INC.
LOUISIANA & MISSISSIPPI

Chief Engineer: Brian Mistich, PE
554 Old Spanish Trail
Slidell, LA 70458
www.dammonengineering.com
info@dammonengineering.com
PH: 985.649.5832

#	DESCRIPTION	REVISIONS	DATE



NEW OFFICE BUILDING
TRU WEARS LLC
ADVISORS LLC

Dalwill Drive
Merden, LA

JOB No: 2479 DATE: 3-11-2023
DRAWN BY: TT CHECKED BY: PFP

SHEET TITLE:
ELECTRICAL SITE PLAN

DRAWING NUMBER:
E101

SHEET No: