

894 ROBERT BOULEVARD
SLIDELL, LOUISIANA 70458
PH. 504-643-2427
FAX 504-643-2691
ROTLO@ROTLOCONSULTANTS.COM

THE WOODLANDS APT. HOMES
PROVIDENT REALTY ADVISORS
CHALMETTE, LA

Copyright 2011 Rotolo Consultants Inc.
These drawings or parts thereof, may not be reproduced in any form, by any method, for any purpose, without prior written consent from Rotolo Consultants Inc.
Contact: Rod Rotolo 985.643.2427
Project No:

Revisions:		
No.	Date	Description


Date: 05/31/2011
Drawn: BCF
Checked:
Sheet Title:

POOL PLUMBING PLAN

Drawing No.

PL1.2


Sheet No.
Of:

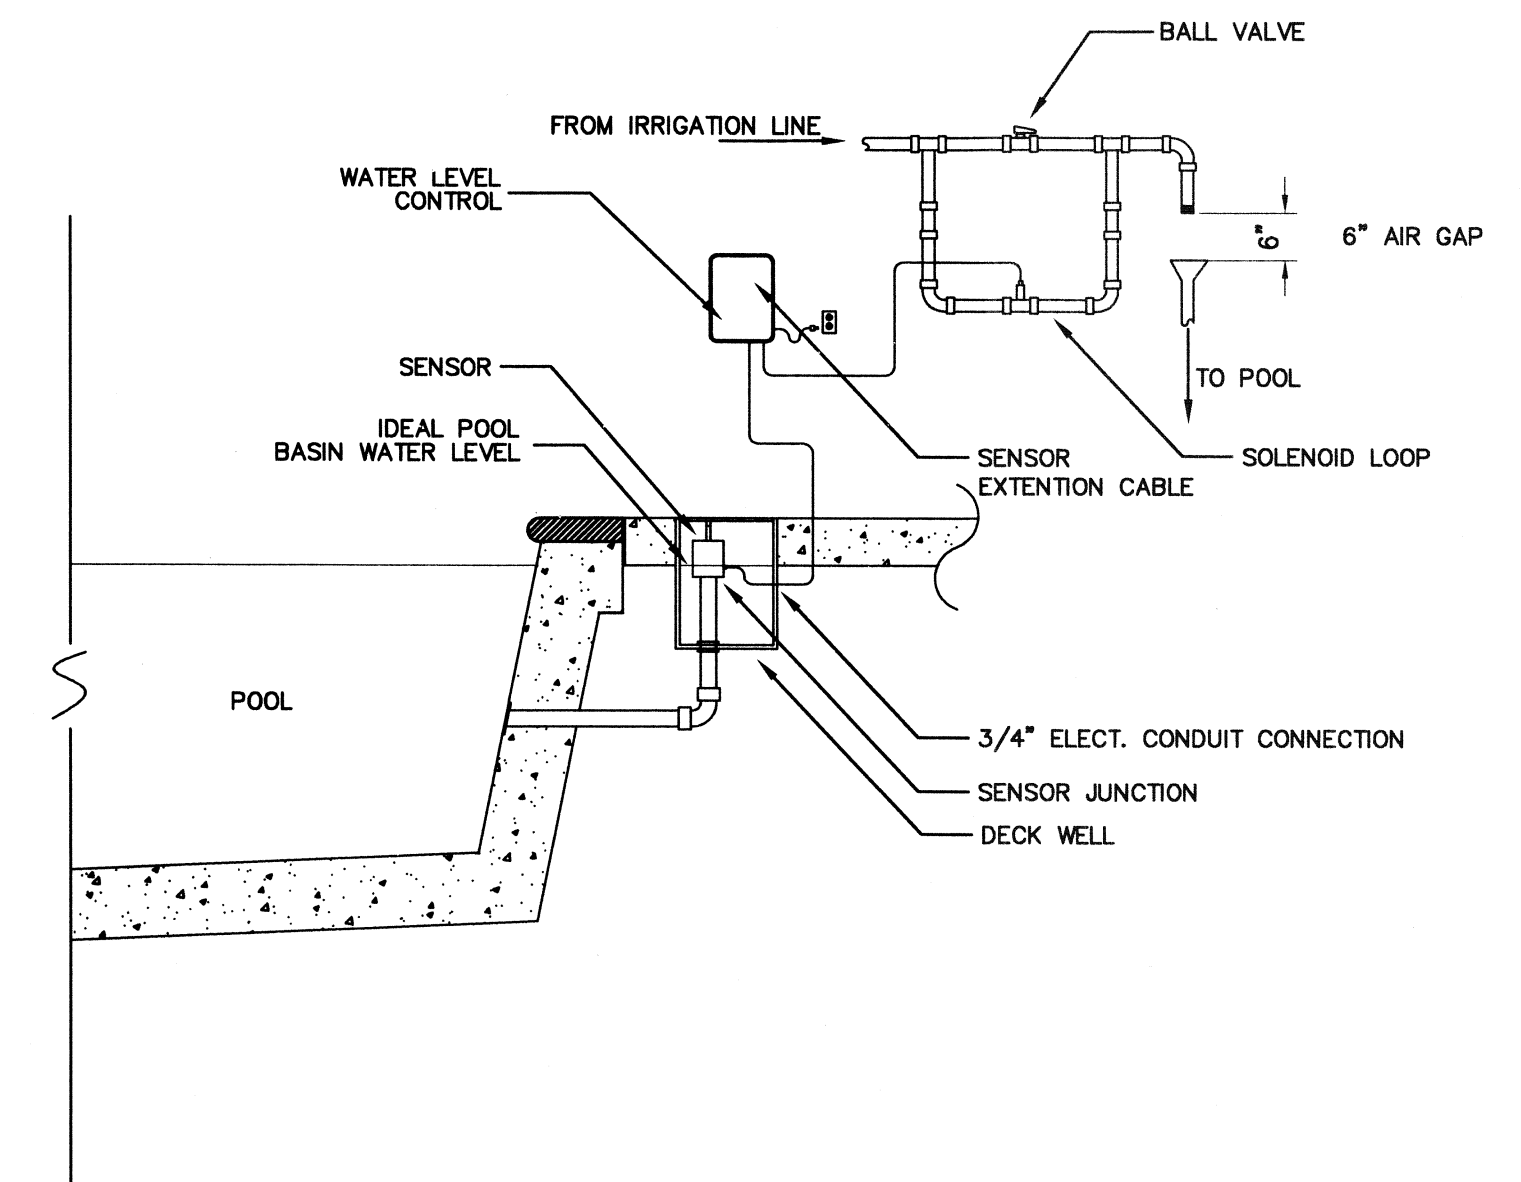

1 WATER LEVEL CONTROLLER
PL1.2 SCALE: 1/8" = 1'-0"

POOL EQUIPMENT & FITTINGS

- 3-WAY VALVE
- 2-WAY VALVE
- CHECK VALVE
- SKIMMER
- POOL RETURN OUTLET
- 9"x9" MAIN DRAIN
- 500w LIGHT
- 2HP POOL PUMP
- TR100 POOL FILTER

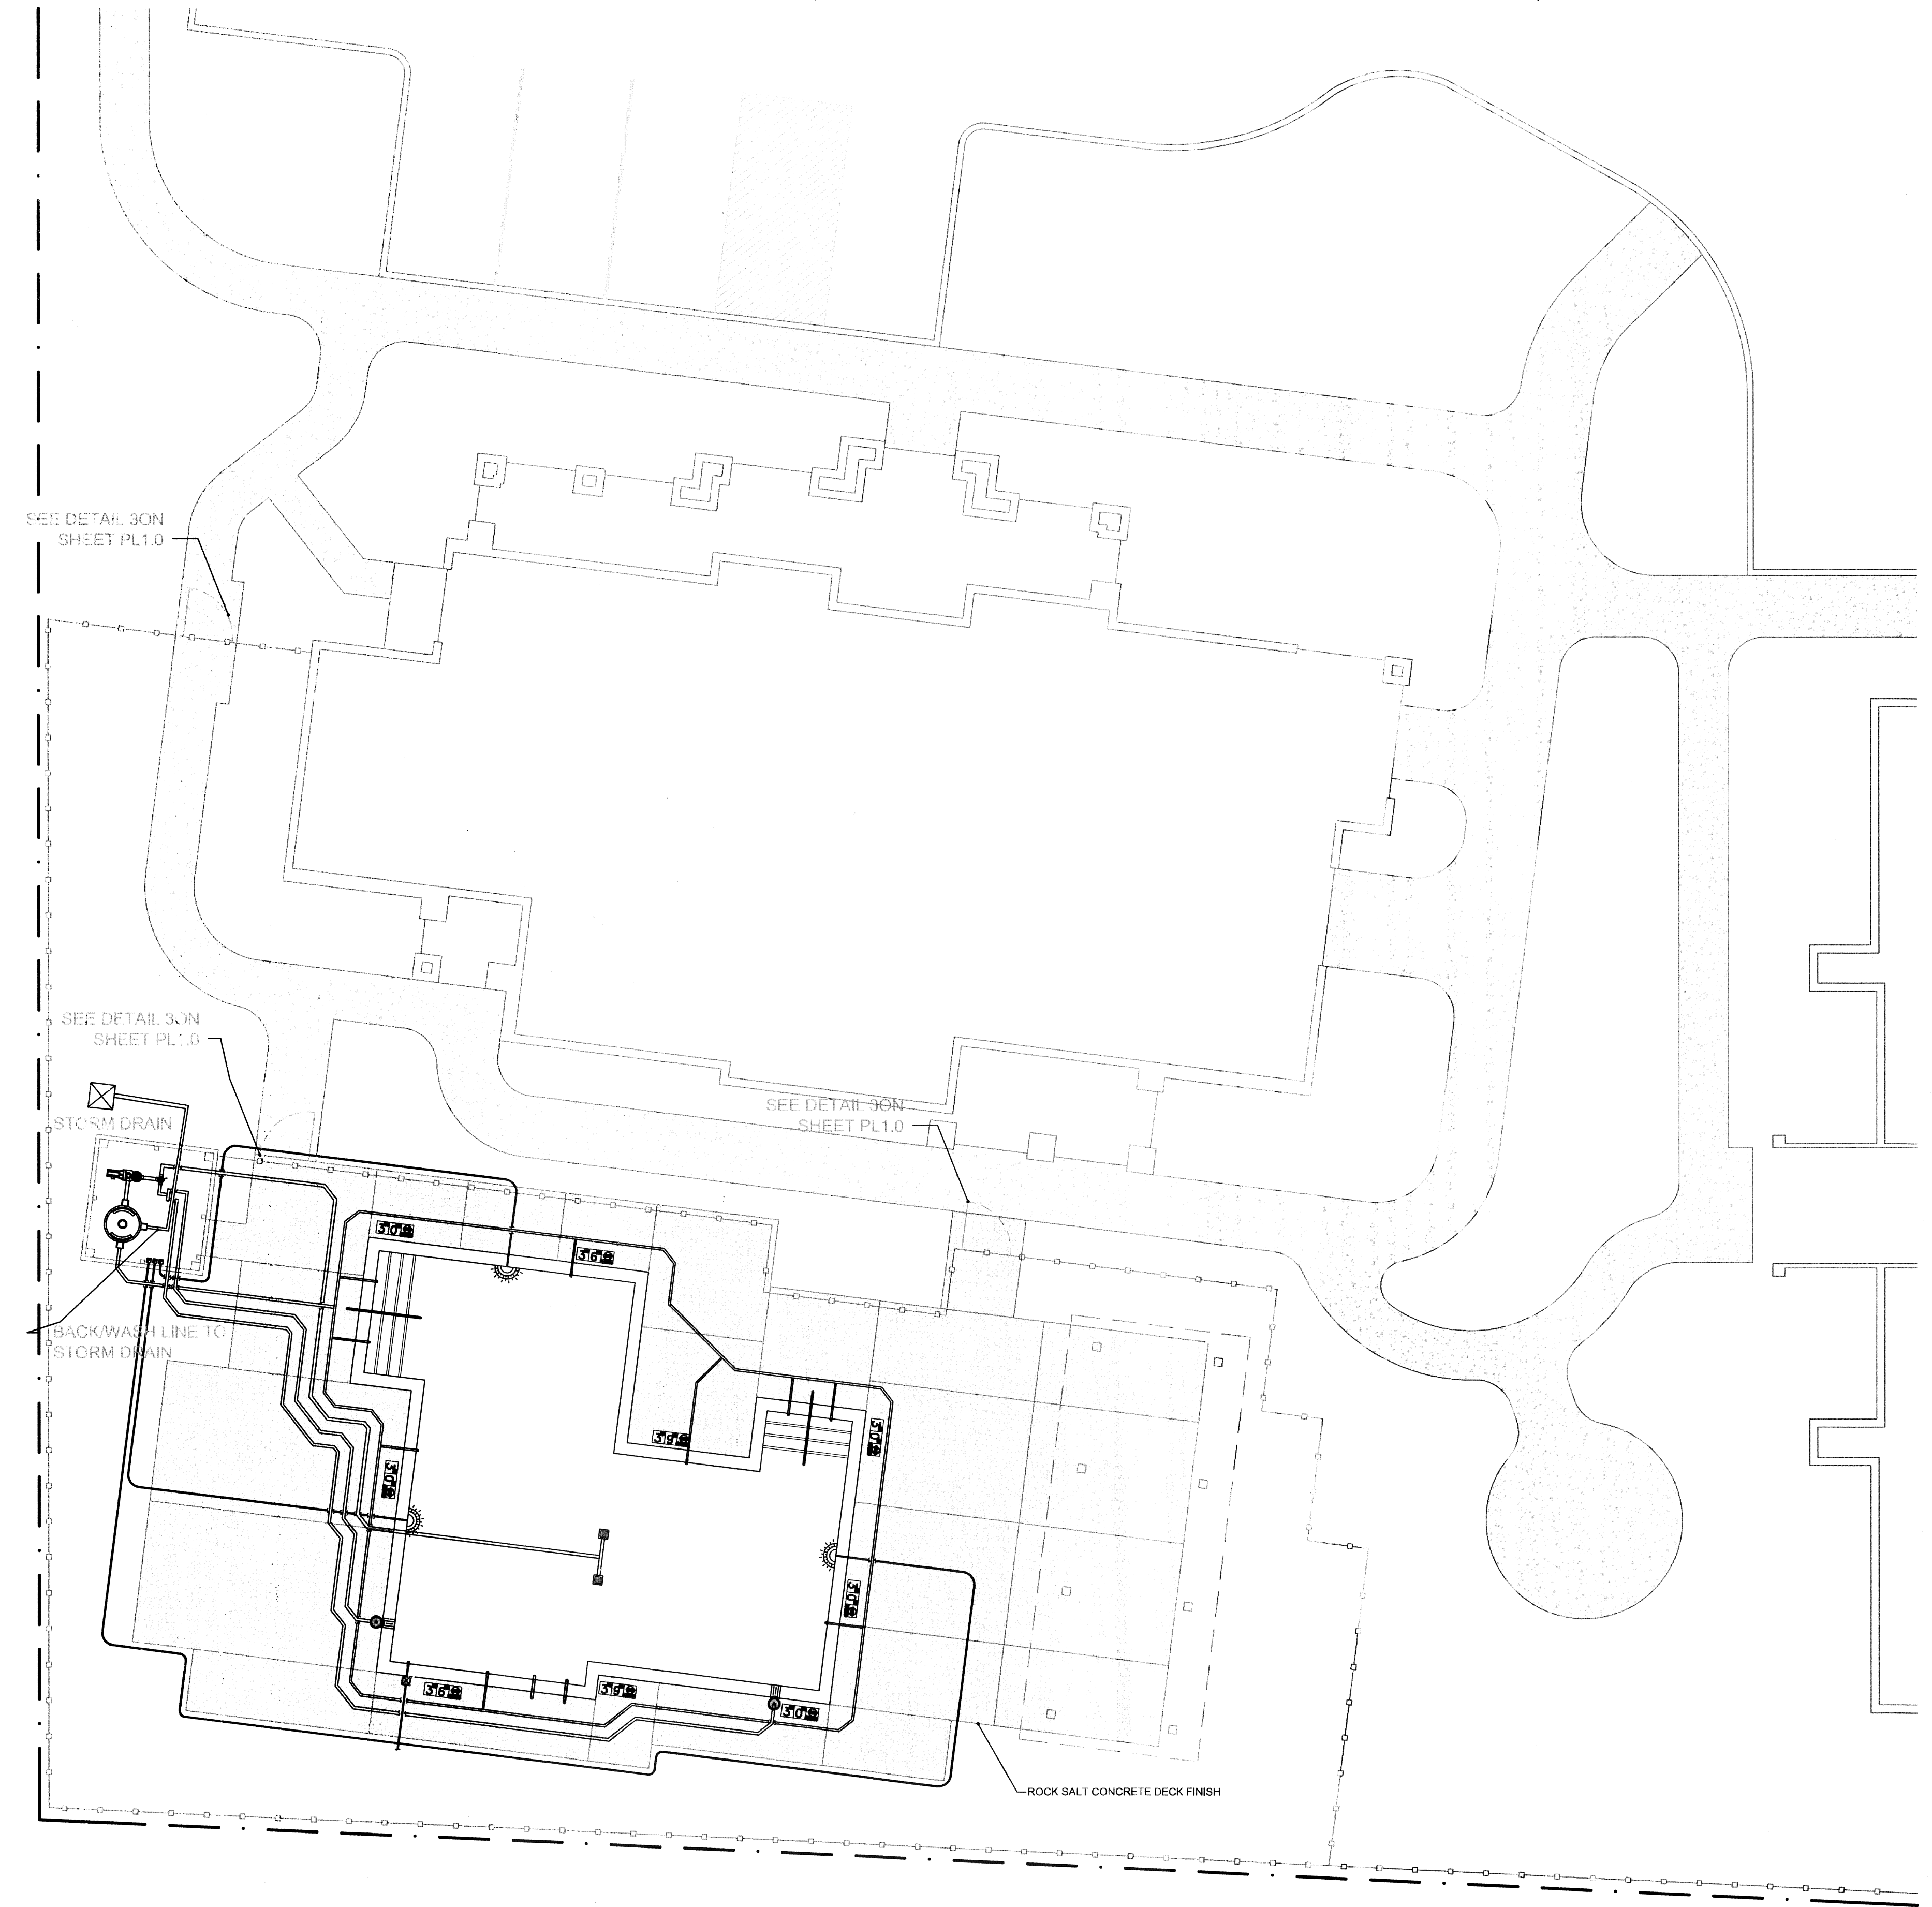

1 POOL PLUMBING PLAN
PL1.2 SCALE: 1/8" = 1'-0"