



**1 POOL PLUMBING PLAN**  
 PL1.2 SCALE: 1/8" = 1'-0"

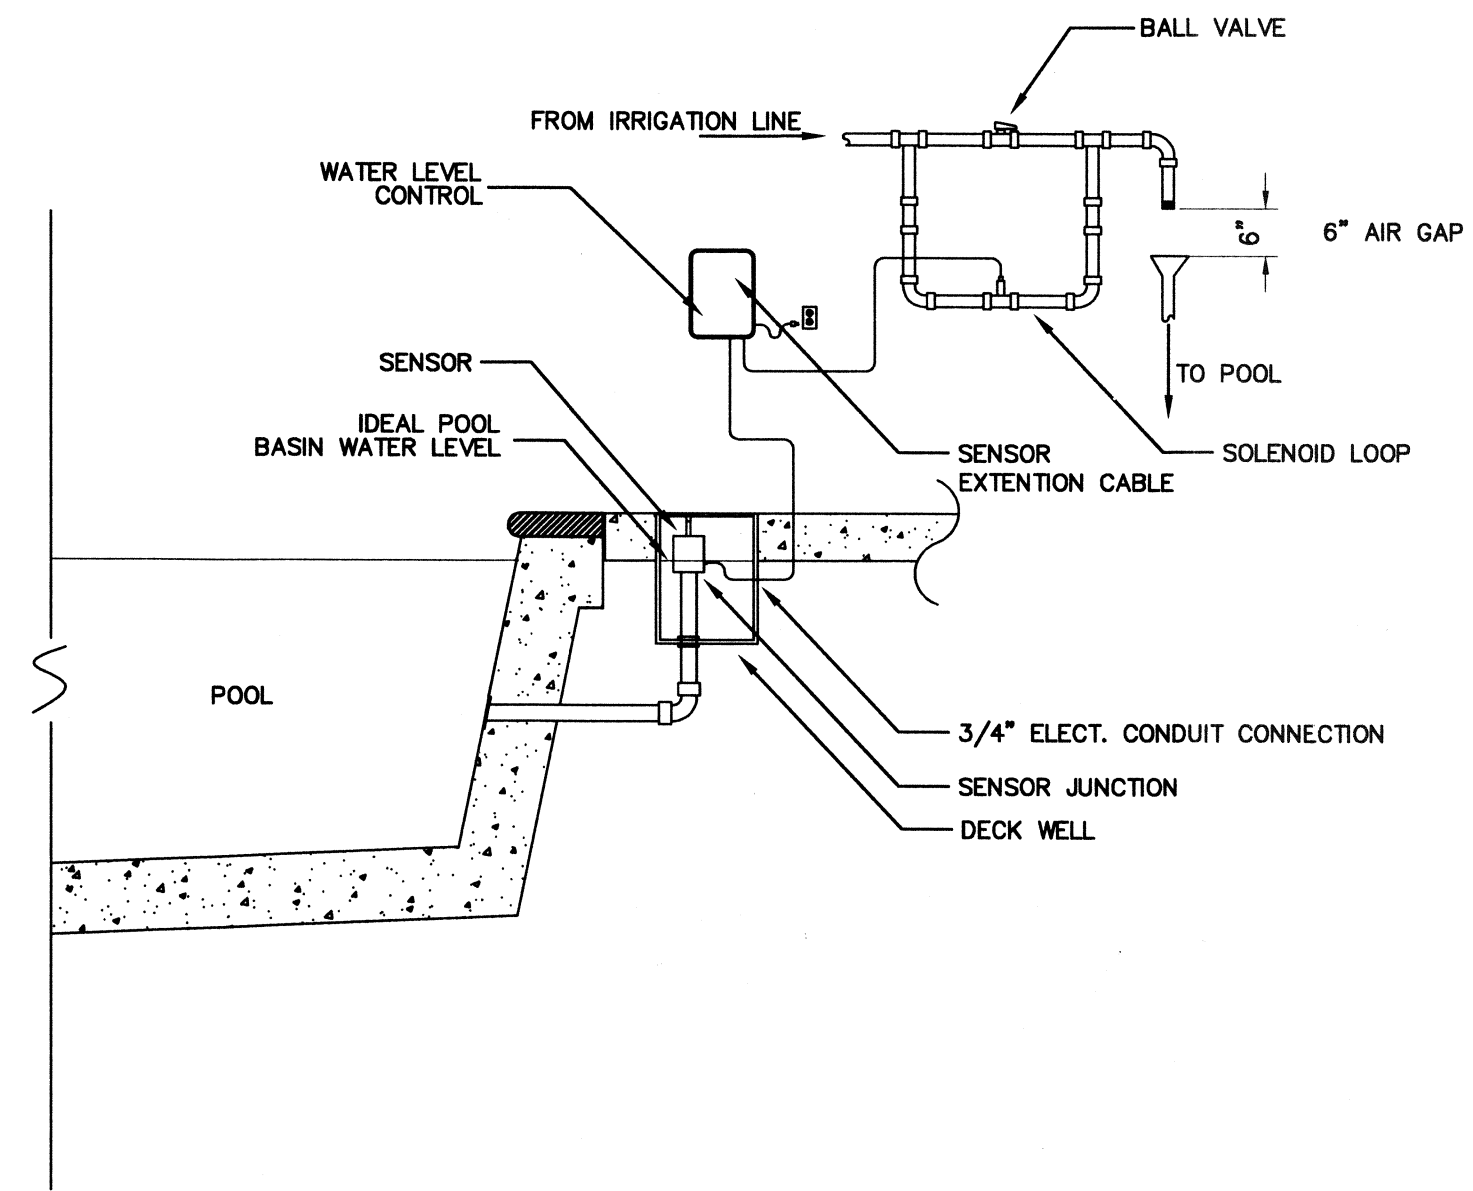

**2 WATER LEVEL CONTROLLER**  
 PL1.2 SCALE: 1/2" = 1'-0"

**POOL EQUIPMENT & FITTINGS**

- 3-WAY VALVE
- 2-WAY VALVE
- CHECK VALVE
- SKIMMER
- POOL RETURN OUTLET
- 9"x9" MAIN DRAIN
- 500w LIGHT
- 2HP POOL PUMP
- TR100 POOL FILTER

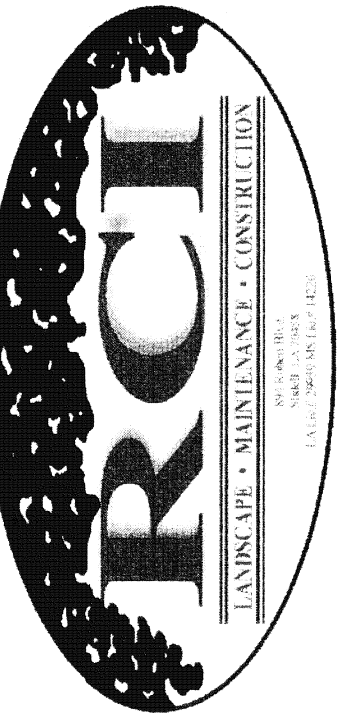

894 ROBERT BOULEVARD  
 SLIDELL, LOUISIANA 70458  
 PH. 504-643-2427  
 FAX 504-643-2691  
 RROTOLO@ROTOLOCONSULTANTS.COM

**PARC PLACE APARTMENT HOMES**  
 PROVIDENT REALTY ADVISORS  
 CHALMETTE, LA

Copyright 2011 © Rotolo Consultants Inc.  
 These drawings or parts thereof, may not be reproduced in any form, by any method, for any purpose, without prior written consent from Rotolo Consultants Inc.  
 Contact: Rod Rotolo 985.643.2427  
 Project No:

Revisions:		
No.	Date:	Description:

Date: 06/07/2011  
 Drawn: BCF  
 Checked:  
 Sheet Title:



**POOL PLUMBING PLAN**

Drawing No.

**PL1.2**

Sheet No.  
 Of: