



COMMUNITY CHRISTIAN CONGREGIN

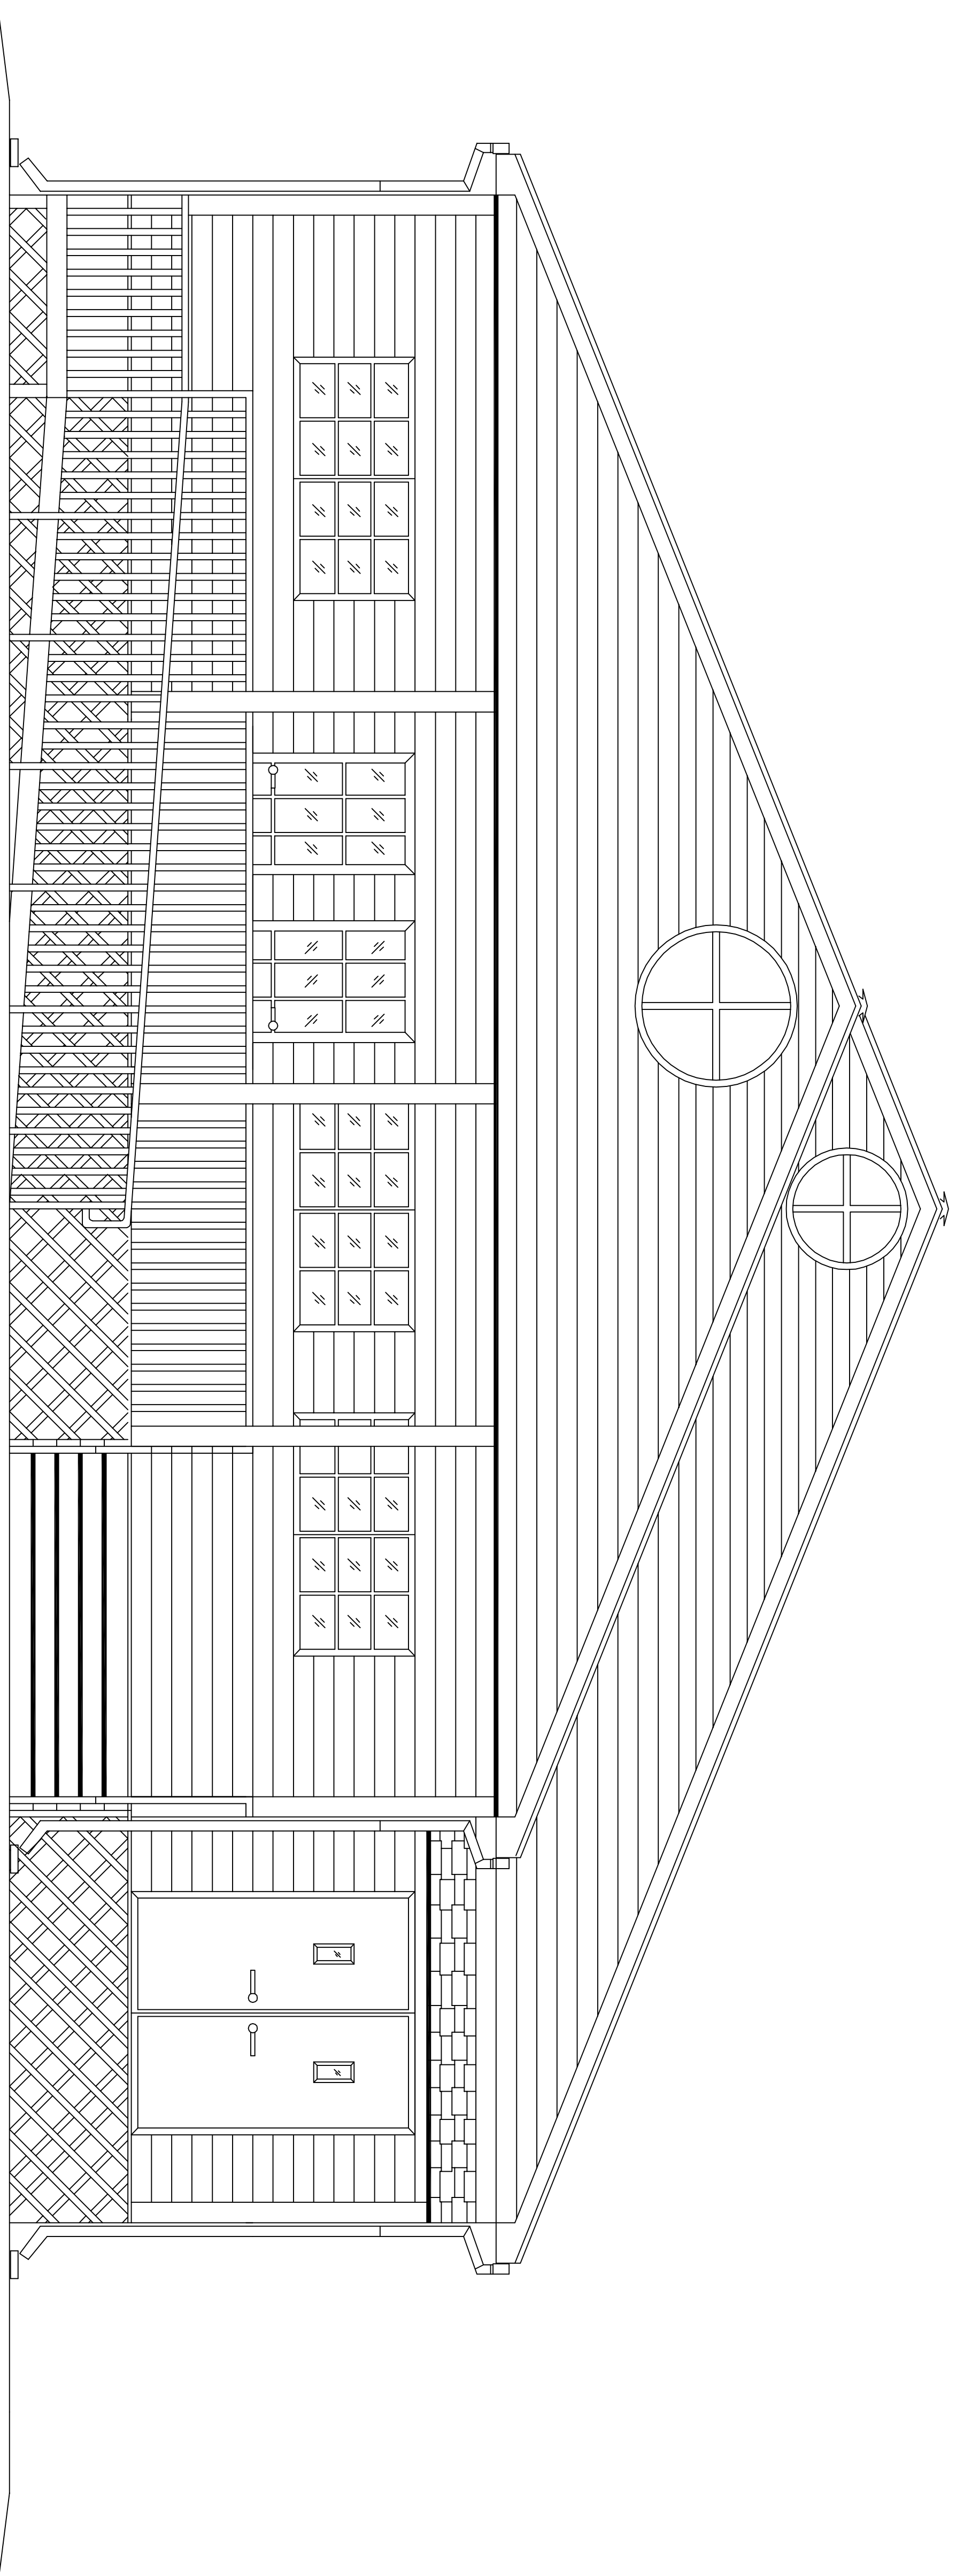

INDEX OF DRAWINGS	
DWG.#	DRAWING NAME
C-1	SITE PLAN
F-1	FLOOR FRAMING PLAN
A-1	FLOOR PLAN
A-2	ELEVATIONS
A-3	CEILING FRAMING PLAN
A-4	SECTION
H-1	HANDICAPPED NOTES
H-2	HANDICAPPED NOTES
E-1	ELECTRICAL PLAN
E-2	REFLECTED CEILING PLAN
M-1	MECHANICAL PLAN
P-1	PLUMBING PLAN

2228 SECOND STREET
SLIDELL, LOUISIANA

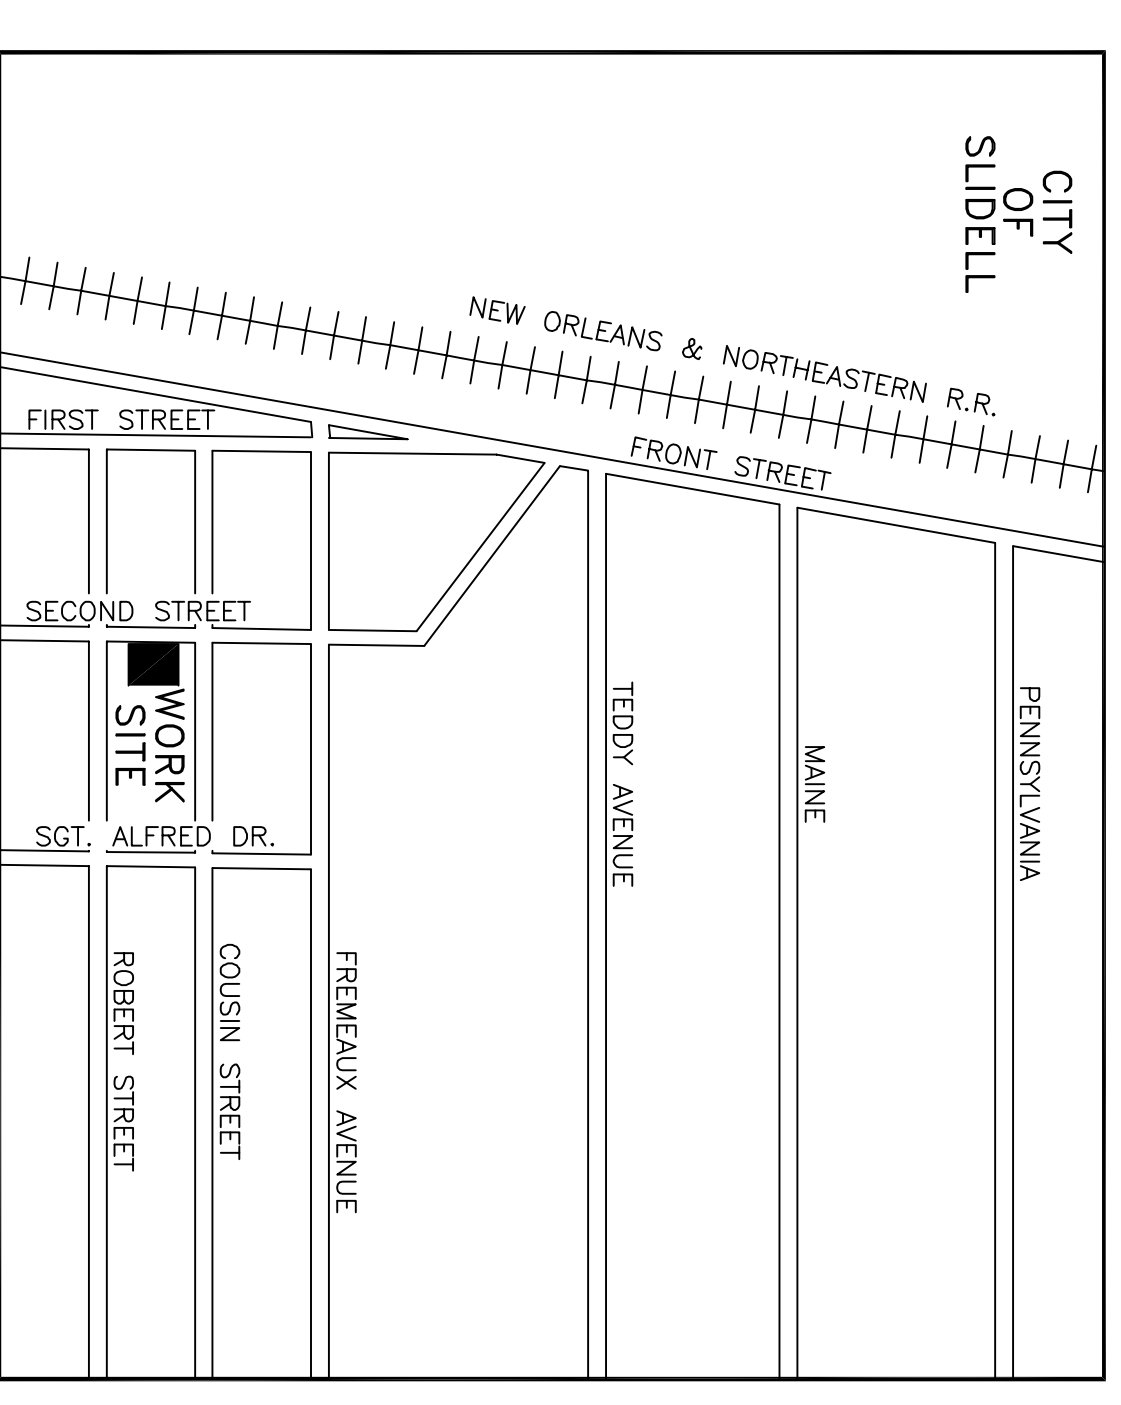

VICINITY MAP
N.T.S.

DAMMON ENGINEERING, INC.

ARCHITECTS - ENGINEERS

2000 OLD SPANISH TRAIL STE. 100

WEB-DAMMONENGINEERING.COM

985-649-5832

E-MAIL--DAMMON@MAILCITY.COM

SLIDELL, LA. 70458