



1
BATHROOM LAYOUT
SCALE: 1/2" = 1'-0"

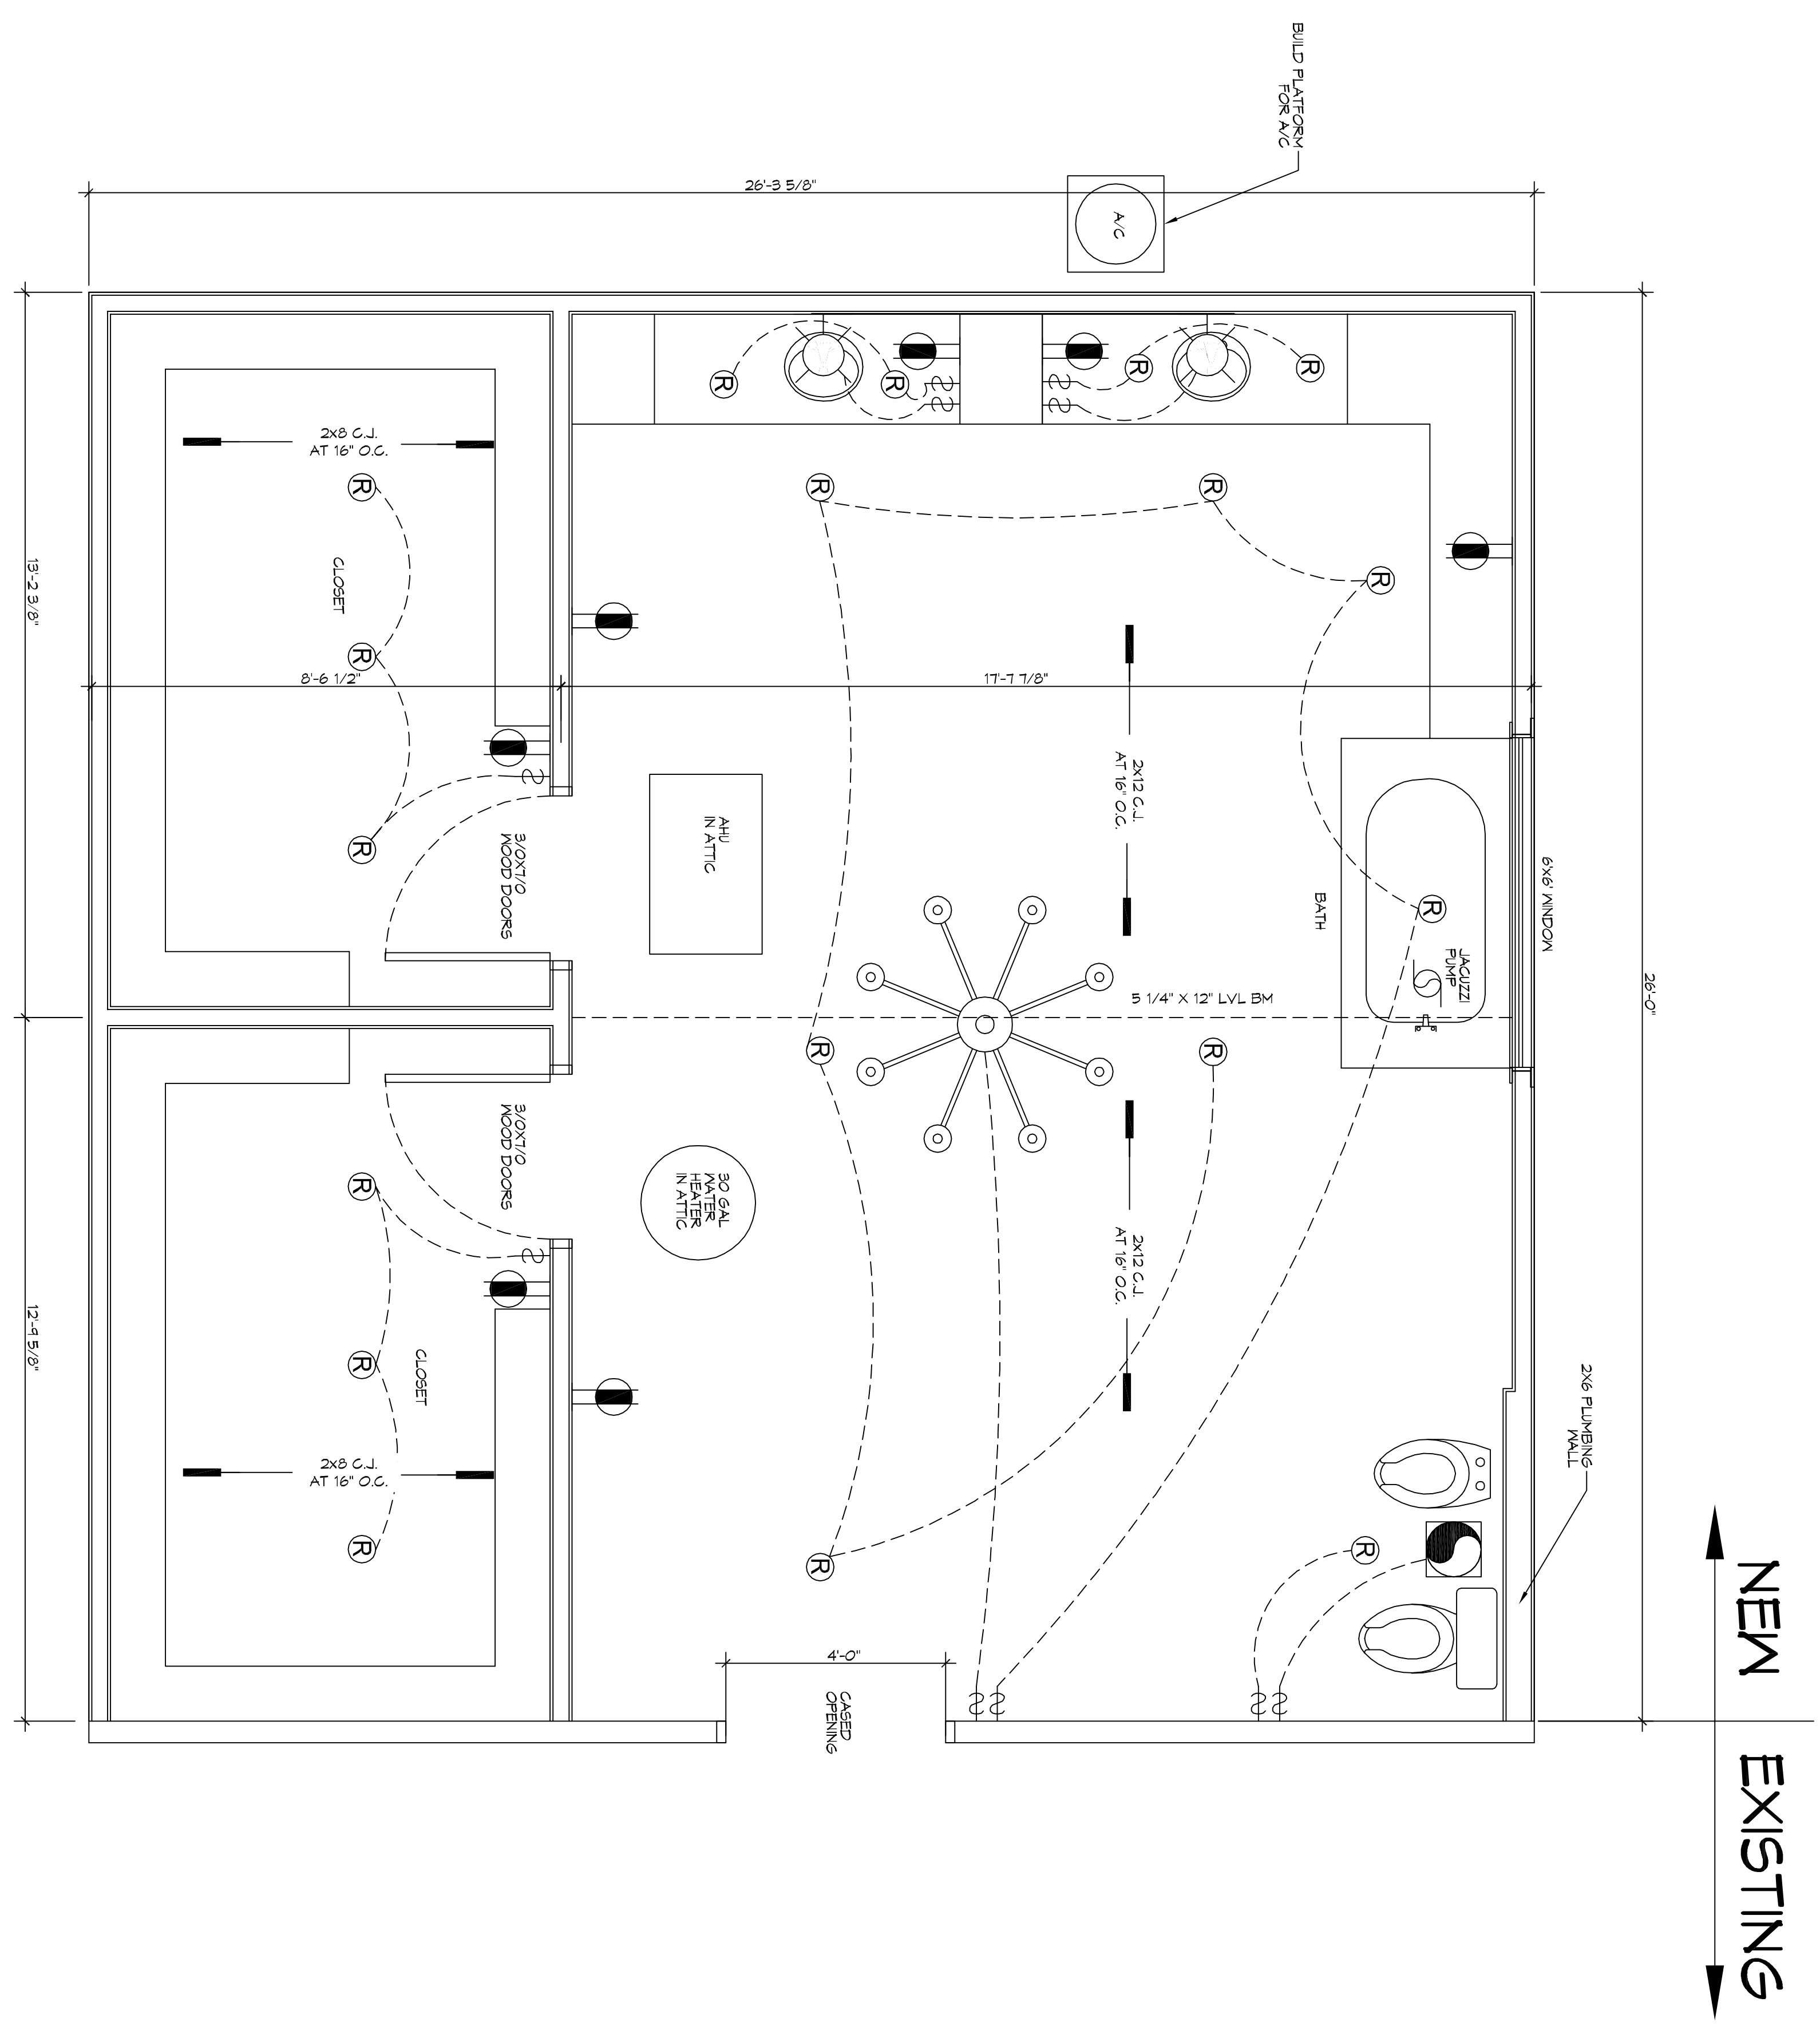

NEW
EXISTING

2
PLUMBING LAYOUT
SCALE: 1/4" = 1'-0"

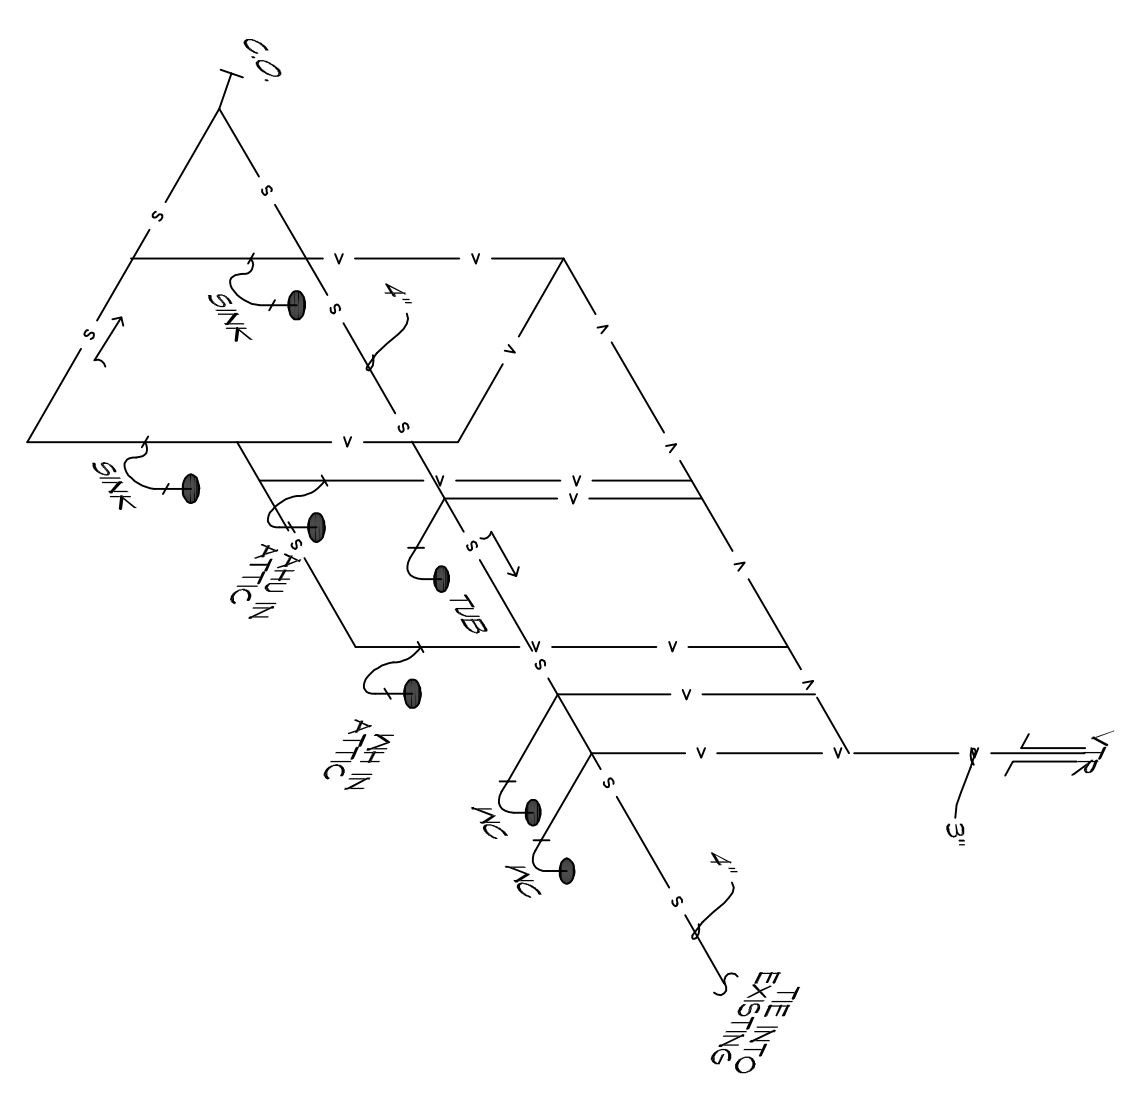

NOTE
VERIFY WITH OWNER ALL PLUMBING FIXTURE TYPES, ELECTRICAL FIXTURE TYPES AND SINK MATERIALS PRIOR TO CONSTRUCTION.

ARCHITECTURAL

BATHROOM ADDITION
THE CLEMENTS
130 CHAMALE DRIVE
SLIDELL, LA, 70458
JOB No: 2018 DATE: 05-04-2018
DRAWN BY: CKD CHECKED BY: BAM



REVISIONS		
#	DESCRIPTION	DATE

DAMMON ENGINEERING, INC.
LOUISIANA & MISSISSIPPI
Chief Engineer: Brian Mstich, PE
554 Old Spanish Trail
Slidell, LA 70458
www.dammonengineering.com
info@dammonengineering.com
PH: 985.649.5832

SHEET No: **A101**
DRAWING NUMBER:
SHEET TITLE:
FLOOR PLAN
4 of 5