





N
1
ADOPTED
SCALE: 1/4" = 1'-0"
SECOND LEVEL MECHANICAL PLAN
ARCHITECTURAL

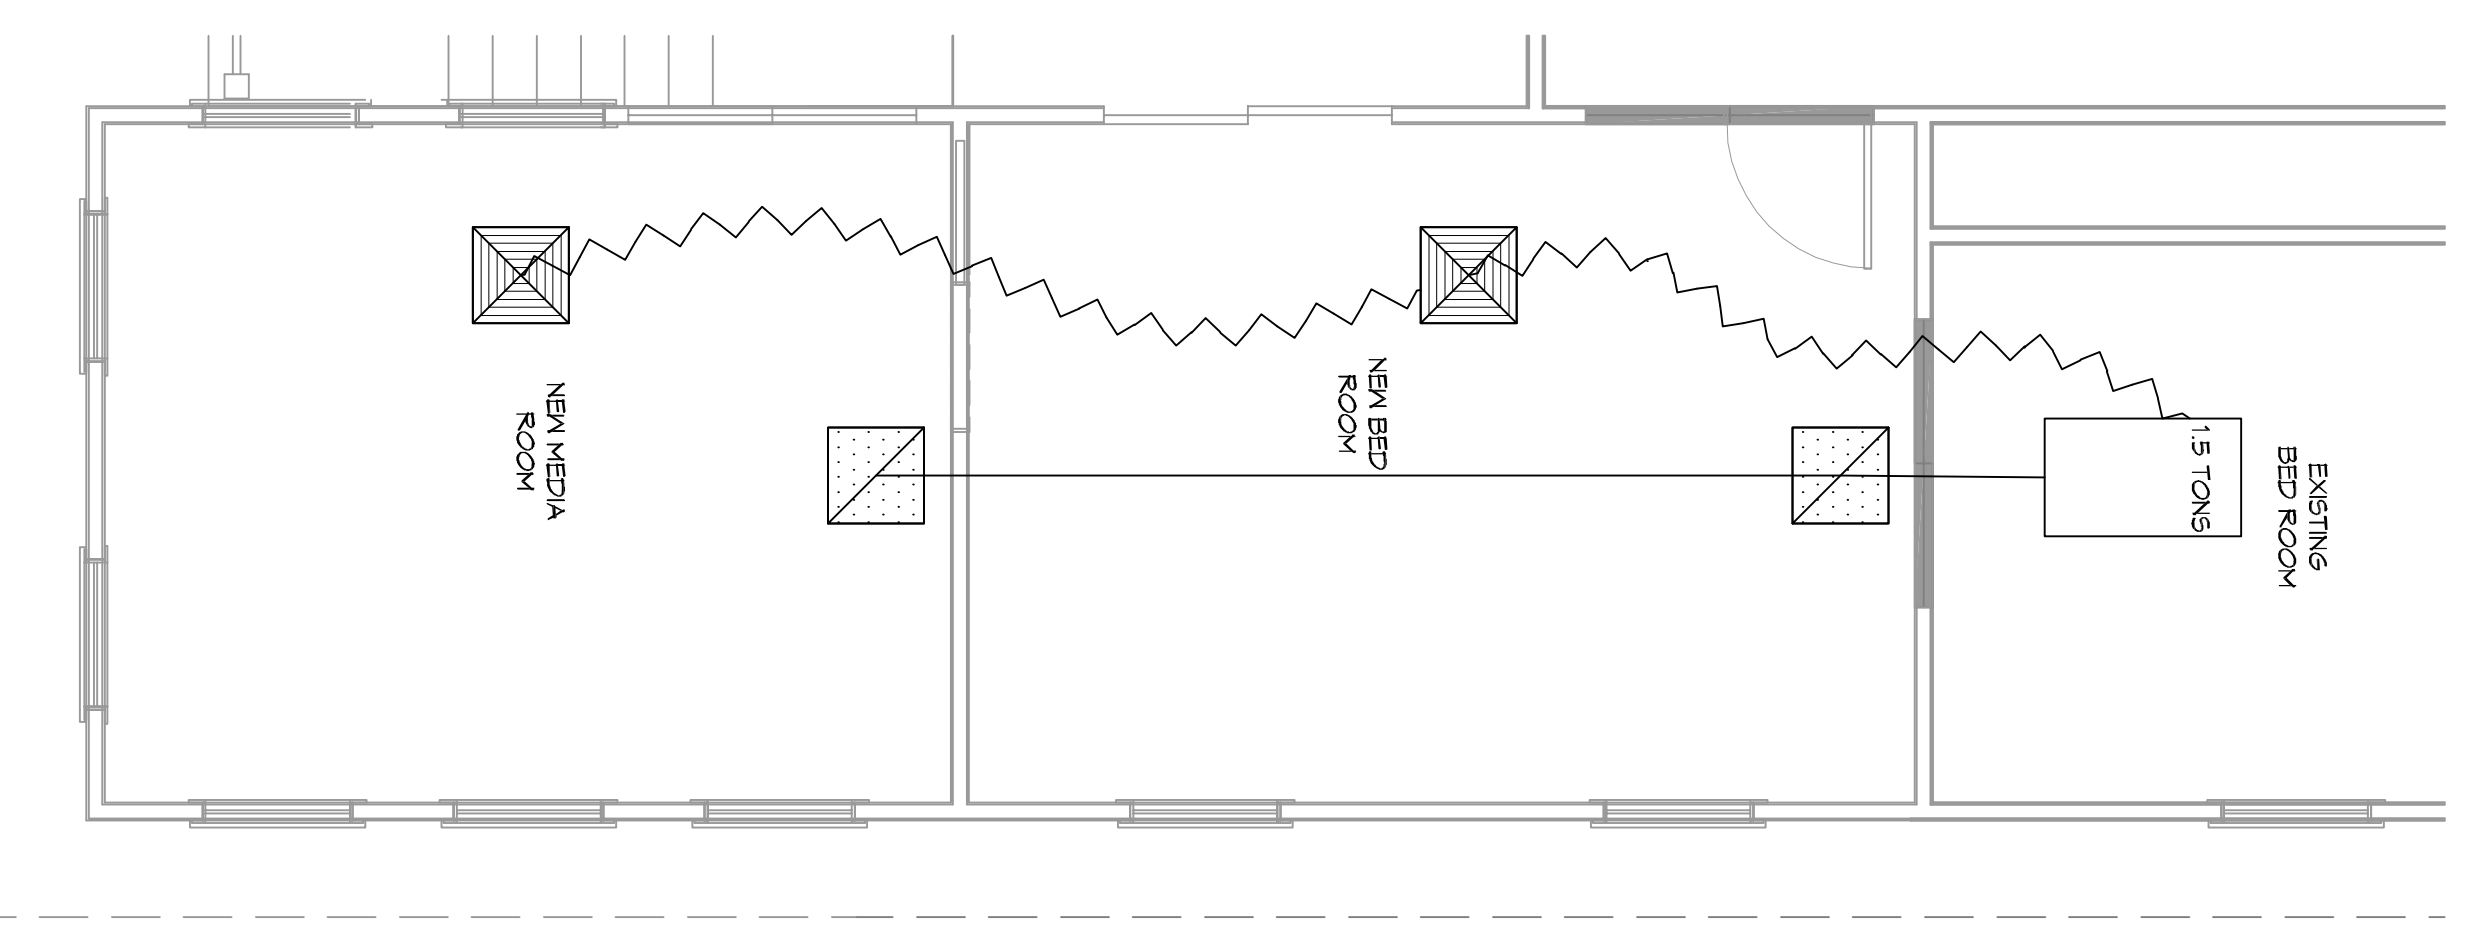



N
1
ADOPTED
SCALE: 1/4" = 1'-0"
POWER PLAN SECOND LEVEL
ARCHITECTURAL

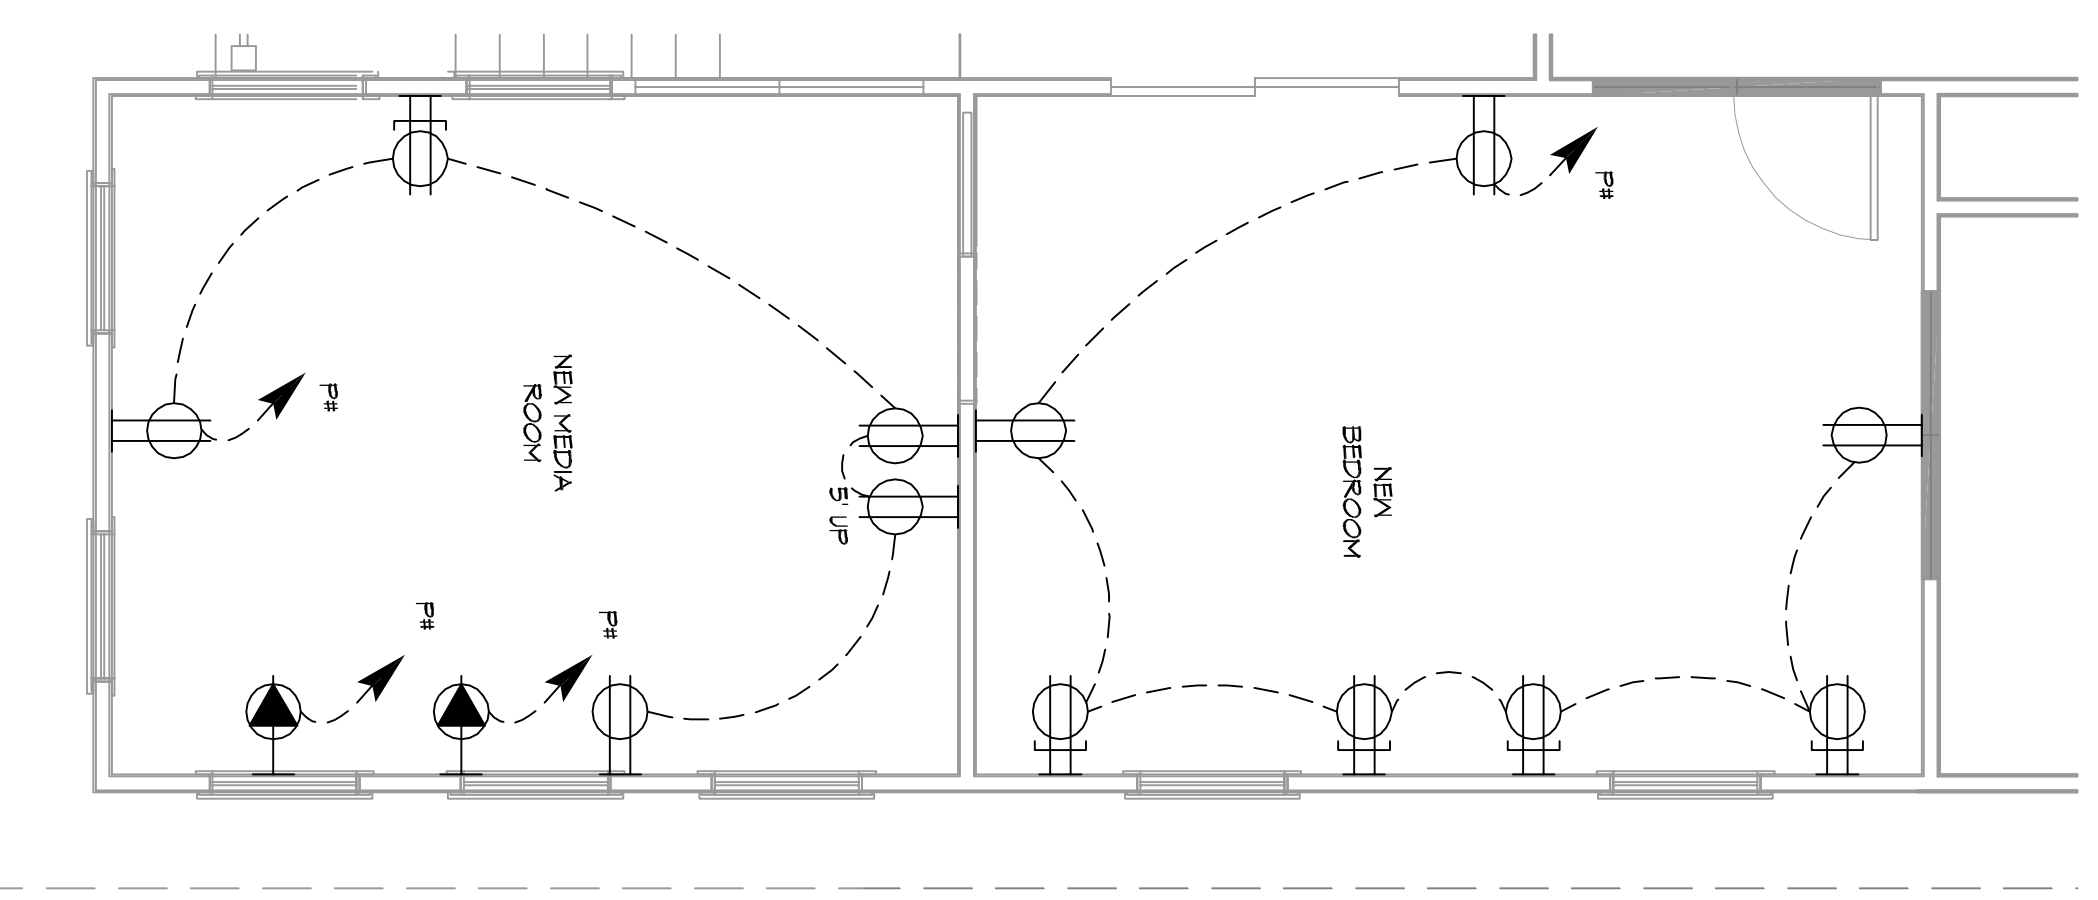

N
1
ADOPTED
SCALE: 1/4" = 1'-0"
LIGHTING PLAN SECOND LEVEL
ARCHITECTURAL

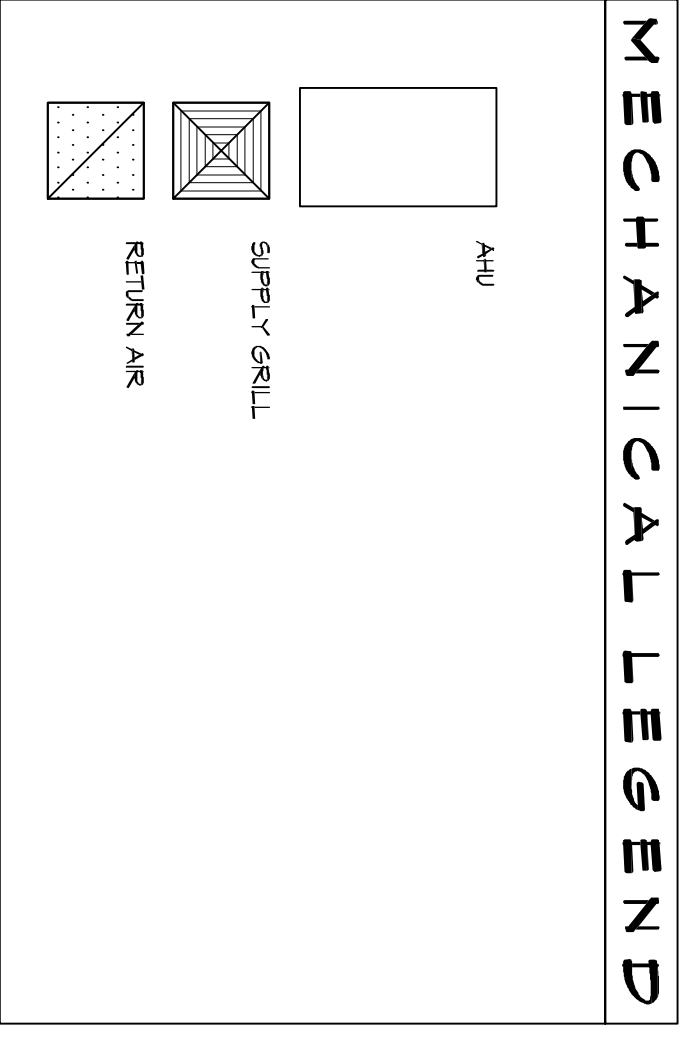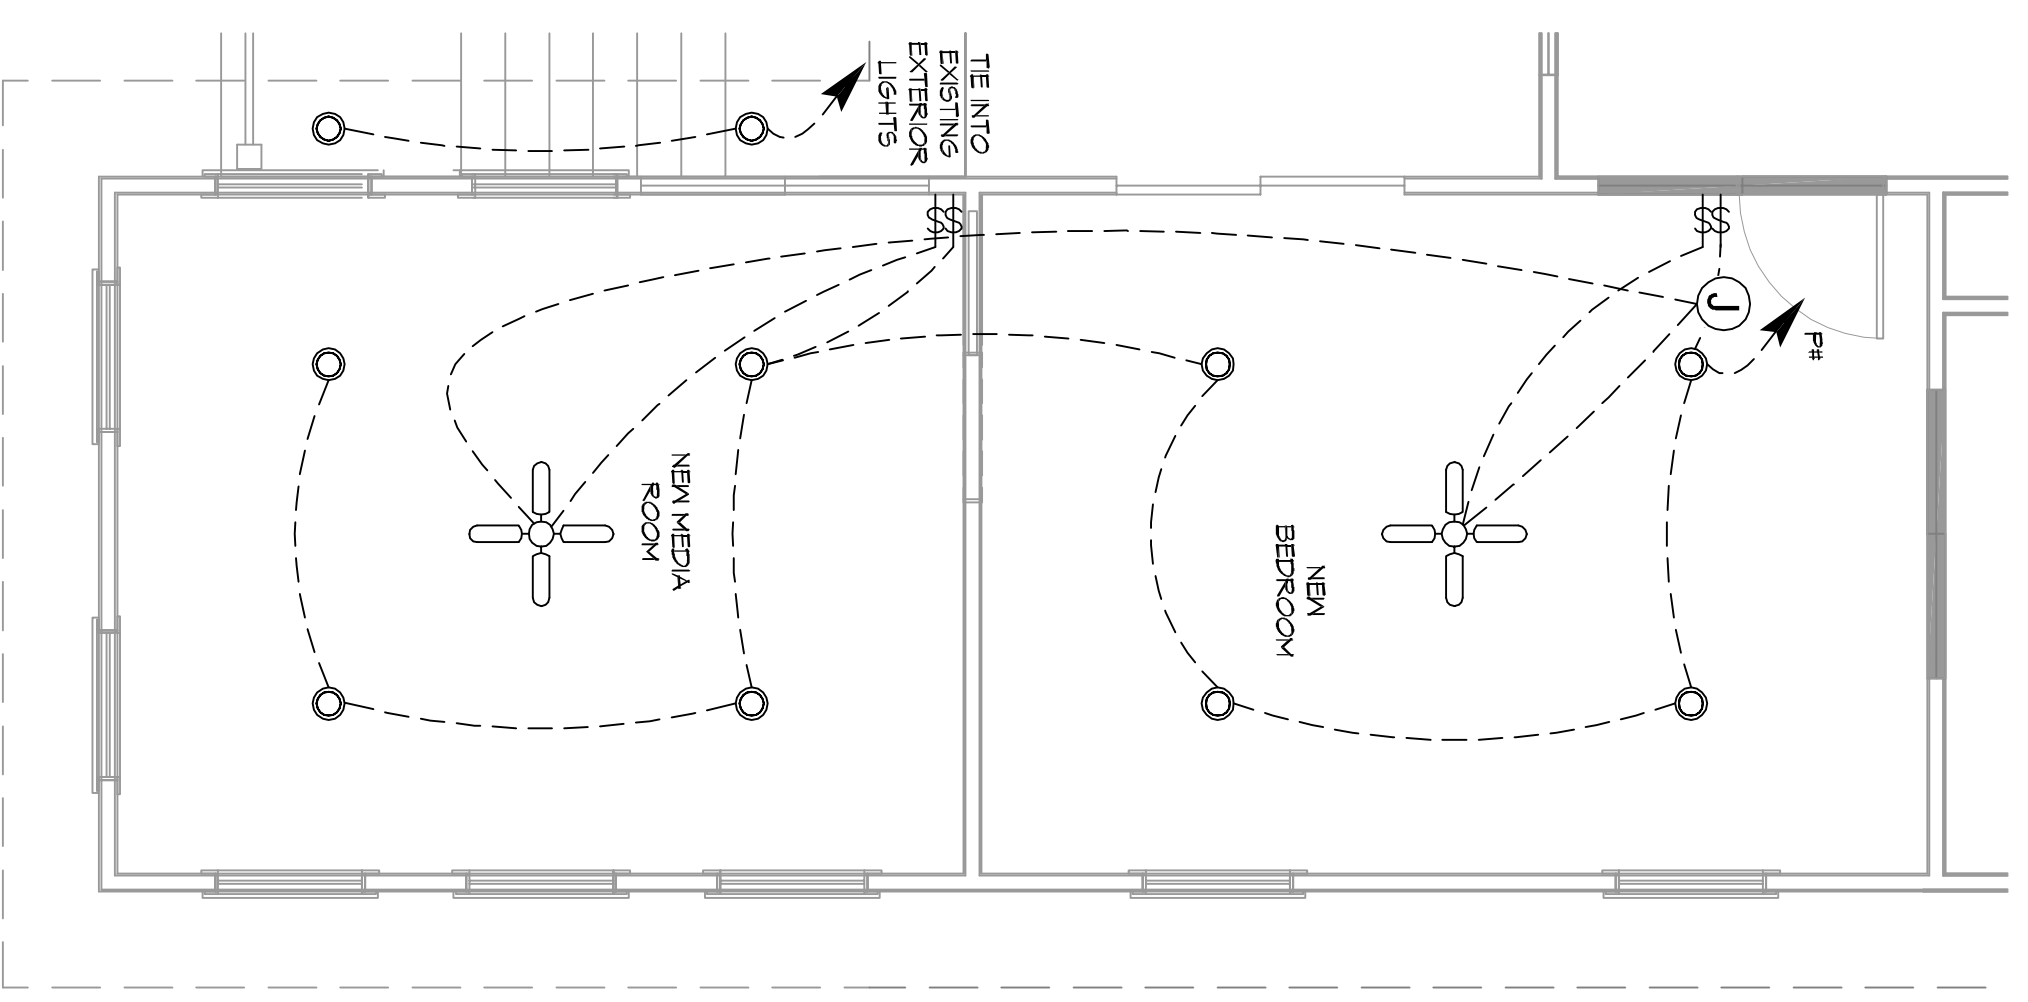

N
2
ADOPTED
SCALE: 1/4" = 1'-0"
LIGHTING PLAN FIRST LEVEL
ARCHITECTURAL

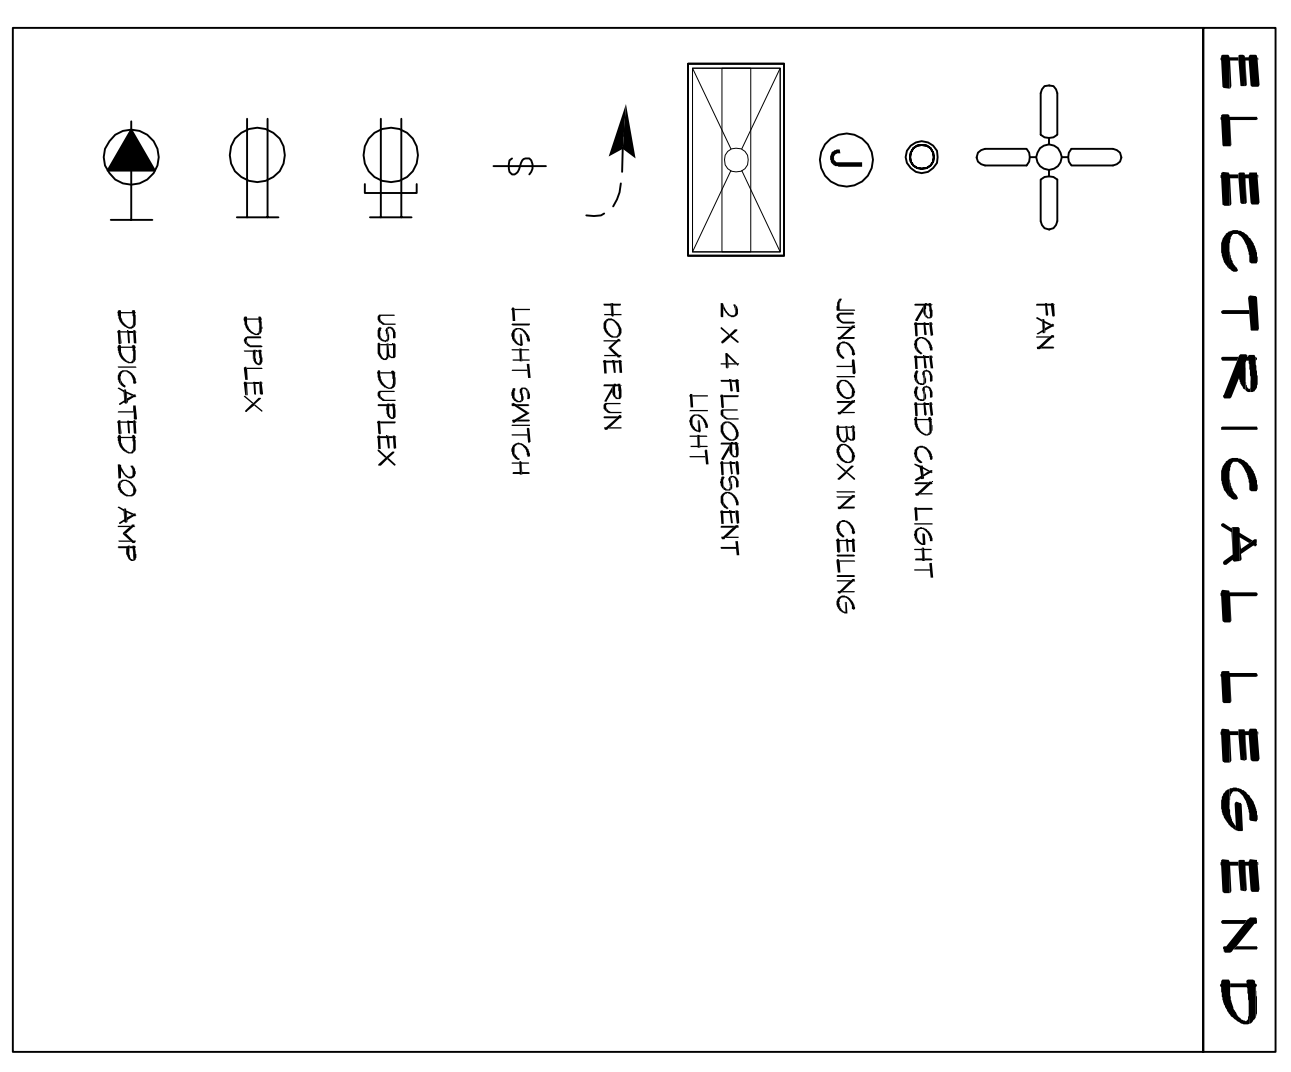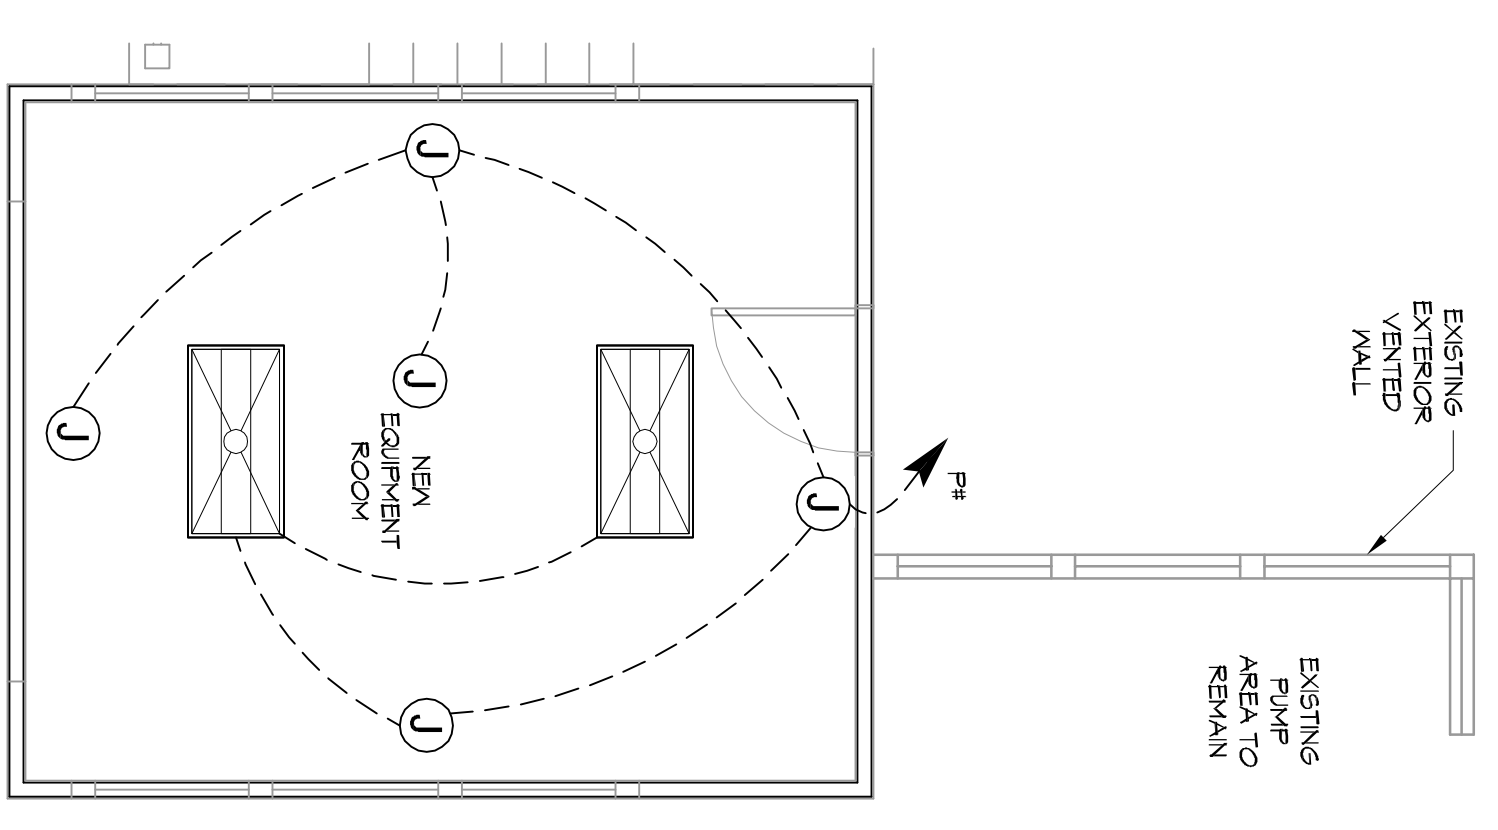

DAMMON
ENGINEERING, INC.

554 Old Spanish Trail
Slidell, LA 70458
PH: 985-649-5832

www.dammonengineering.com
info@dammonengineering.com
Fax: 985-641-5950

REVISIONS		DATE
#	DESCRIPTION	

PRELIMINARY NOT FOR CONSTRUCTION

DAMMON ENGINEERING

206 MARLIN DRIVE
SLIDELL LOUISIANA

JOB No: 2018 DATE: 10-01-2018

DRAWN BY: JAGMM CHECKED BY: KGD

SHEET TITLE:
MECHANICAL & ELECTRICAL PLANS

DRAWING NUMBER:
E101

SHEET No: 2 of 4