

**DAMMON ENGINEERING, INC.**  
 CHIEF ENGINEER  
 EMMETT DAMMON, P.E.  
 CHIEF ARCHITECT  
 ROBERT WILTSE

1095 FLORIDA AVENUE  
 SLIDELL, LA. 70456  
 OFFICE: 985-649-5832  
 FAX: 985-641-5950

WEBSITE: WWW.DAMMONENGINEERING.COM  
 EMAIL: DAMMONENG@BELLOUTH.NET

ARCHITECTURE  
 ENGINEERING  
 STUDIES  
 PLANNING  
 INVESTIGATION  
 EXPERT WITNESS

**RESTAURANT RENOVATION**

OSAKA  
 287 S. MORRISON BLVD.  
 HAMMOND, LA

**POWER PLAN**

REV:

SCALE: AS NOTED


JOB#: 1943

DATE: 7-25-08

SHEET 18

**E-1**

OF 22

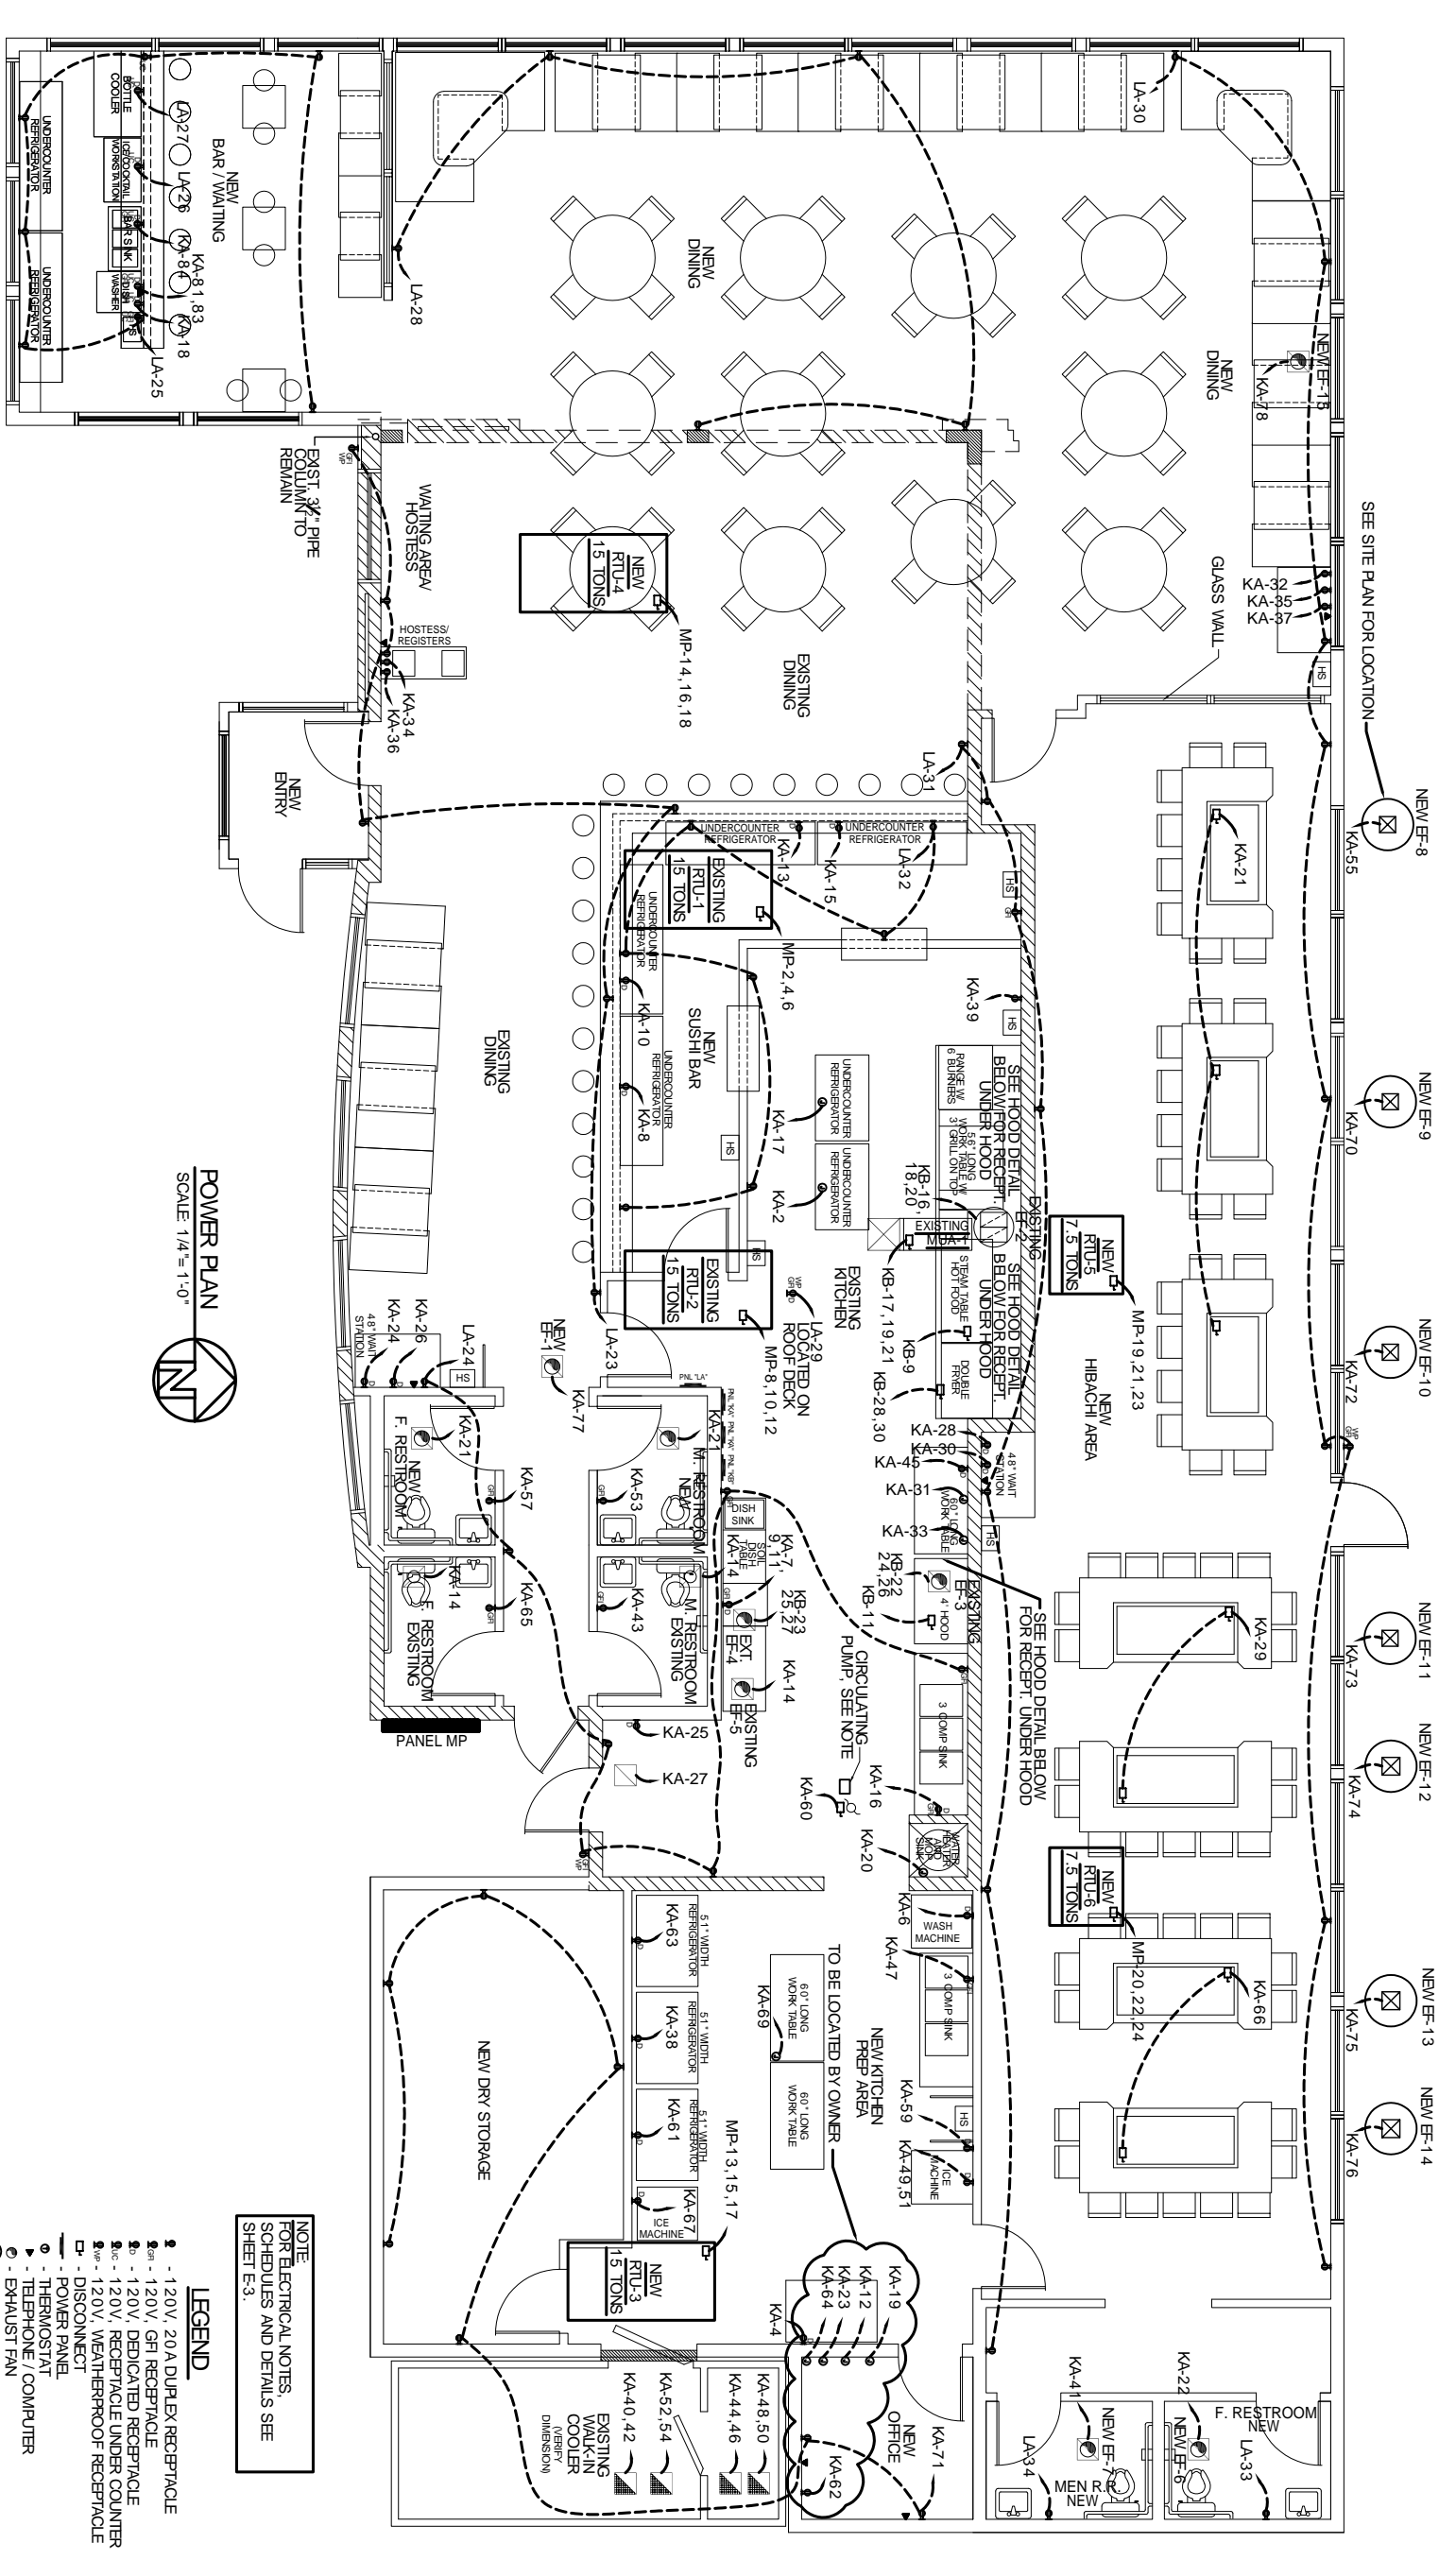


**POWER PLAN**  
 SCALE 1/4" = 1'-0"

**NOTE:**  
 FOR ELECTRICAL NOTES,  
 SCHEDULES AND DETAILS SEE  
 SHEET E.3.

- LEGEND**
- - 120V, 20A DUPLEX RECEPTACLE
  - - 120V, GFI RECEPTACLE
  - - 120V, DEDICATED RECEPTACLE
  - - 120V, RECEPTACLE UNDER COUNTER
  - - 120V, WEATHER-ROOF RECEPTACLE
  - - DISCONNECT
  - - POWER PANEL
  - - THERMOSTAT
  - - TELEPHONE / COMPUTER
  - - EXHAUST FAN
  - - WATER HEATER
  - - J-BOX 220V
  - - 208/240, 1Ø JUNCTION BOX

EXISTING WALLS TO REMAIN

**NOTE:**  
 HOT WATER CIRCULATING PUMP -  
 PHASE STRONG S-25, 1 1/2 HP, 115V, 1  
 PHASE PROVIDE PROGRAMMABLE TIMER  
 FOR PUMP.

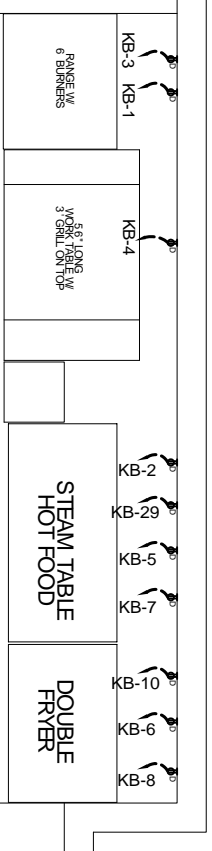

**HOOD DETAIL**  
 N.T.S.

