


- ### HVAC NOTES
1. CONCEALED DUCTWORK TO BE GALVANIZED SHEET METAL LINED WITH NEOPRENE COATED 1.0" THICK, 1.5 POUNDS PER CUBIC FOOT DUCT INSULATION, MIN R-6, INSTALLED PER SMACNA STANDARDS.
 2. EXPOSED DUCTWORK TO BE GALVANIZED SHEET METAL LINED WITH NEOPRENE COATED 1.0" THICK, 1.5 POUNDS PER CUBIC FOOT DUCT INSULATION, MIN R-6, INSTALLED PER SMACNA STANDARDS.
 3. CONDENSATE & OVERFLOW DRAIN LINES SHALL BE PVC SCH 40 AND SHALL BE INSTALLED COMPLETELY SEPARATE TO SANITARY SEWER. DRAINS TO BE RUN TO PLUMBERS P-TRAP WITHIN FIVE FEET OF AIR HANDLING UNITS.
 4. ROUND FLEXIBLE DUCT TO BE UL-181, CLASS 1, AIR DUCT MATERIALS.
 5. DUCT SIZES SHOWN ARE CLEAR INSIDE DIMENSIONS.
 6. IN ALL SYSTEMS OVER 2000 CFM AND LESS THAN 15,000 CFM, SMOKE DETECTORS SHALL BE INSTALLED IN ACCORDANCE WITH NFPA 72E IN THE RETURN DUCT DOWNSTREAM OF THE AIR HANDLING UNIT AND ALL FILTERS TO AUTOMATICALLY STOP THE FAN.
 7. PROVIDE U.L. LISTED 125°F FIRESTAT IN RETURN AIR OF EACH SYSTEM UNDER 2000 CFM TO SHUT DOWN THE FAN IN THE EVENT OF FIRE.
 8. PROVIDE U.L. RATED FIRE DAMPERS WHERE REQUIRED AT ALL DUCT PENETRATIONS OF FIRE-RATED ASSEMBLIES AND WHERE REQUIRED BY CODE, INCLUDING OUTSIDE AIR INTAKES.
 9. ALL AIR HANDLING SYSTEMS TO BE BALANCED TO ASSURE PROPER AIR FLOWS PER PLANS.
 10. ALL THERMOSTATS TO BE AUTOMATIC CHANGEOVER WITH HEAT SWITCH.
 11. EXHAUST FAN EQUAL TO ACFE FRN-110 OR EQUAL. FAN SHALL BE CONTROLLED BY A SWITCH ON THE WALL IN THE SAME LOCATION AS LIGHT SWITCH(S). PROVIDE BACK DRAFT DAMPER.
 12. PROVIDE AND INSTALL WATER PROOF GRILLE VENT IN PROPER ROOF LOCATION FOR PLUMBING FIXTURE EXHAUST.
 13. ALL SUPPLY AIR VENTS SHALL BE EQUIPPED WITH AIR CONTROL DAMPERS.
 14. LOCATE OUTDOOR UNITS AS SHOWN ON ARCH. DWGS.
 15. REFRIGERANT LINES SHALL BE SIZED BY UNIT MANUFACTURER AND INSTALLED ACCORDING TO MANUFACTURERS' INSTRUCTIONS.
 16. FRESH AIR SHALL BE SUPPLIED TO EACH AIR HANDLER THROUGH EXTERIOR WALL DUCT SUPPLIED WITH A CONTROL DAMPER.
 17. INSTALL FIRE DAMPER WHERE S.A. & R.A. DUCTS PENETRATE 1 HOUR RATED CEILING.
 18. ALL ELECTRICAL, MECHANICAL, AND PLUMBING PENETRATING FIRE WALLS SHALL BE FIRE CAULKED. (PENETRATIONS THROUGH RATED CONSTRUCTION SHALL BE SEALED WITH A MATERIAL CAPABLE OF PREVENTING THE PASSAGE OF FLAMES AND HOT GASES WHEN TESTED IN ACCORDANCE WITH ASTM-E814).
 19. ALL MECHANICAL SYMBOLS ARE DRAWN DIAGRAMATICALLY. CONTRACTOR TO VERIFY WITH OWNER LOCATIONS OF VENTS, DAMPERS, REGISTERS, ETC.
 20. FLEXIBLE DUCTWORK LENGTH NOT TO EXCEED 12'-0".
 21. REFER TO REFLECTED CEILING PLAN FOR FINAL GRILLE AND DIFFUSER LOCATIONS AND COORDINATE AS REQUIRED.
 22. FINAL LOCATION OF TEMPERATURE CONTROLS TO BE COORDINATED WITH OWNER AT JOB SITE.
 23. PROVIDE AND INSTALL SMOKE DETECTORS AS APPROVED BY LOCAL AHJ'S. PLACE NEAR R/A AND S/A OPENINGS OF AHU AND PROVIDE, WITH ACCESS PANEL, WIRING BY ELECTRICAL CONTRACTOR.
 24. FRESH AIR INTAKES ARE REQUIRED TO HAVE MOTORIZED OR GRAVITY DAMPERS TO SHUT OFF WHEN SYSTEM IS NOT RUNNING.


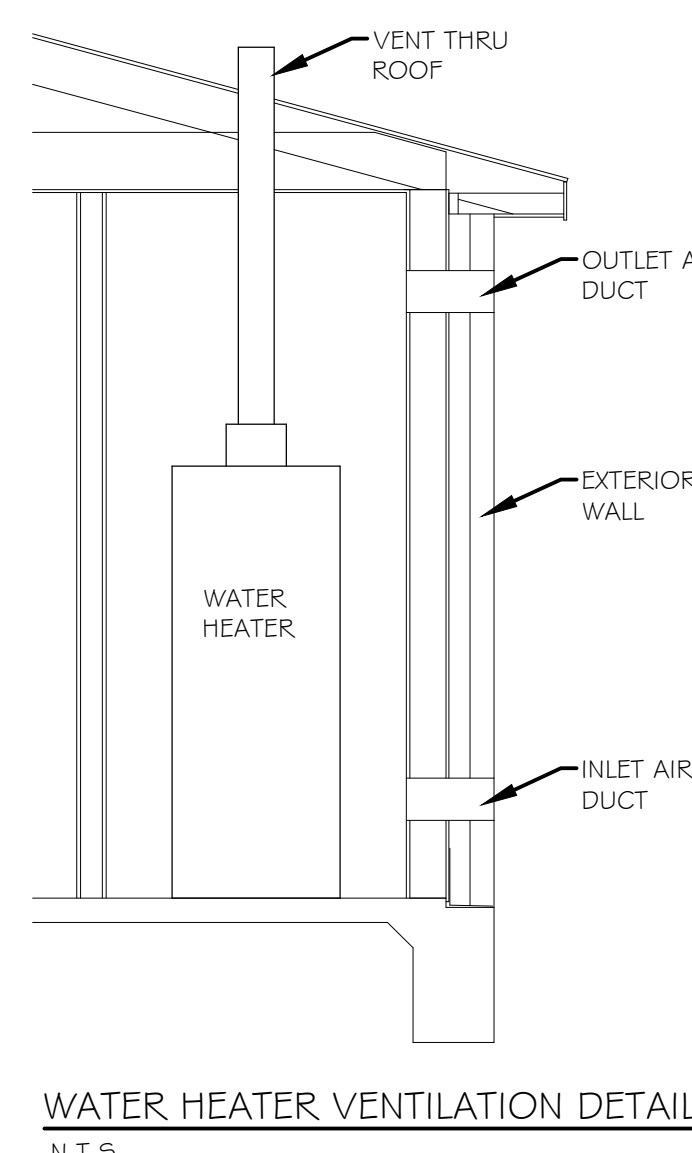


SINGLE PACKAGE ROOF-TOP A/C UNITS SCHEDULE														TRANE			
UNIT NUMBER	TOTAL CFM	MINIMUM OUTSIDE AIR CFM	EXT. STATIC PRESSURE IN W.G.	COOLING CAPACITY						ELECTRICAL DATA				MODEL NUMBER	UNIT WEIGHT		
				TOTAL BTUH	SENSIBLE BTUH	ENTERING D.B.F.	W.B.F.	LEAVING D.B.F.	W.B.F.	VOLT.	PH.	FAN H.P.	UNIT MCA			UNIT MOCP	HEATING GAS BTUH
RTU-1	4000	400	0.50	119,000	101,410	80	67	60.1	57.9	208	3	1.7	49.6	60	200,000	Y5C120F	1800
RTU-2	4000	400	0.50	119,000	101,410	80	67	60.1	57.9	208	3	1.7	49.6	60	200,000	Y5C120F	1800
RTU-3	6000	400	0.50	186,000	131,000	80	67	60.8	56.9	208	3	3	75	100	250,000	Y5D180F	2500

MINI-SPLIT DUCTLESS A/C SYSTEM SCHEDULE												
UNIT NUMBER	NOM. TONS	AIR CAPACITY MIN. CFM	AIR CAPACITY MAX. CFM	COOLING CAPACITY		AIR HANDLING UNIT		CONDENSING UNIT				
				RATED BTU/HR	MINIMUM BTU/HR	TRANE MODEL	TOTAL AMPS	WEIGHT	TRANE MODEL	VOLTS /PH	UNIT MCA/MCP	WEIGHT
DS-AC	3	400 (2)	600 (2)	34,000	16,000	4TXW 6515 (2)	1 (2)	37.4 (2)	4TXM 6536A	208/1	28/45	165

EXHAUST FAN SCHEDULE								
NO.	LOCATION	CFM	EXT. S.P.	MOTOR HP (w)	TYPE	DRIVE	ELECTRICAL (v/ph/hz)	MANF.
EF1	WOMEN'S RESTROOM	250	0.3	212(w)	CEILING	DIRECT	120/1/60	BROAN
EF2	MENS RESTROOM	250	0.3	212(w)	CEILING	DIRECT	120/1/60	BROAN
EF3	CUSTODIAN	100	0.3	127(w)	CEILING	DIRECT	120/1/60	BROAN

GAS-FIRED INFRARED TUBE HEATERS SCHEDULE				
UNIT NO.	SERVICE AREA	BTUH	MINIMUM MOUNT HT.	ELECTRICAL (v/ph/hz/amps)
IH-1	DINING PATIO	50,000	10 FT.	120/1/60/4.8a
IH-2	DINING PATIO	50,000	10 FT.	120/1/60/4.8a

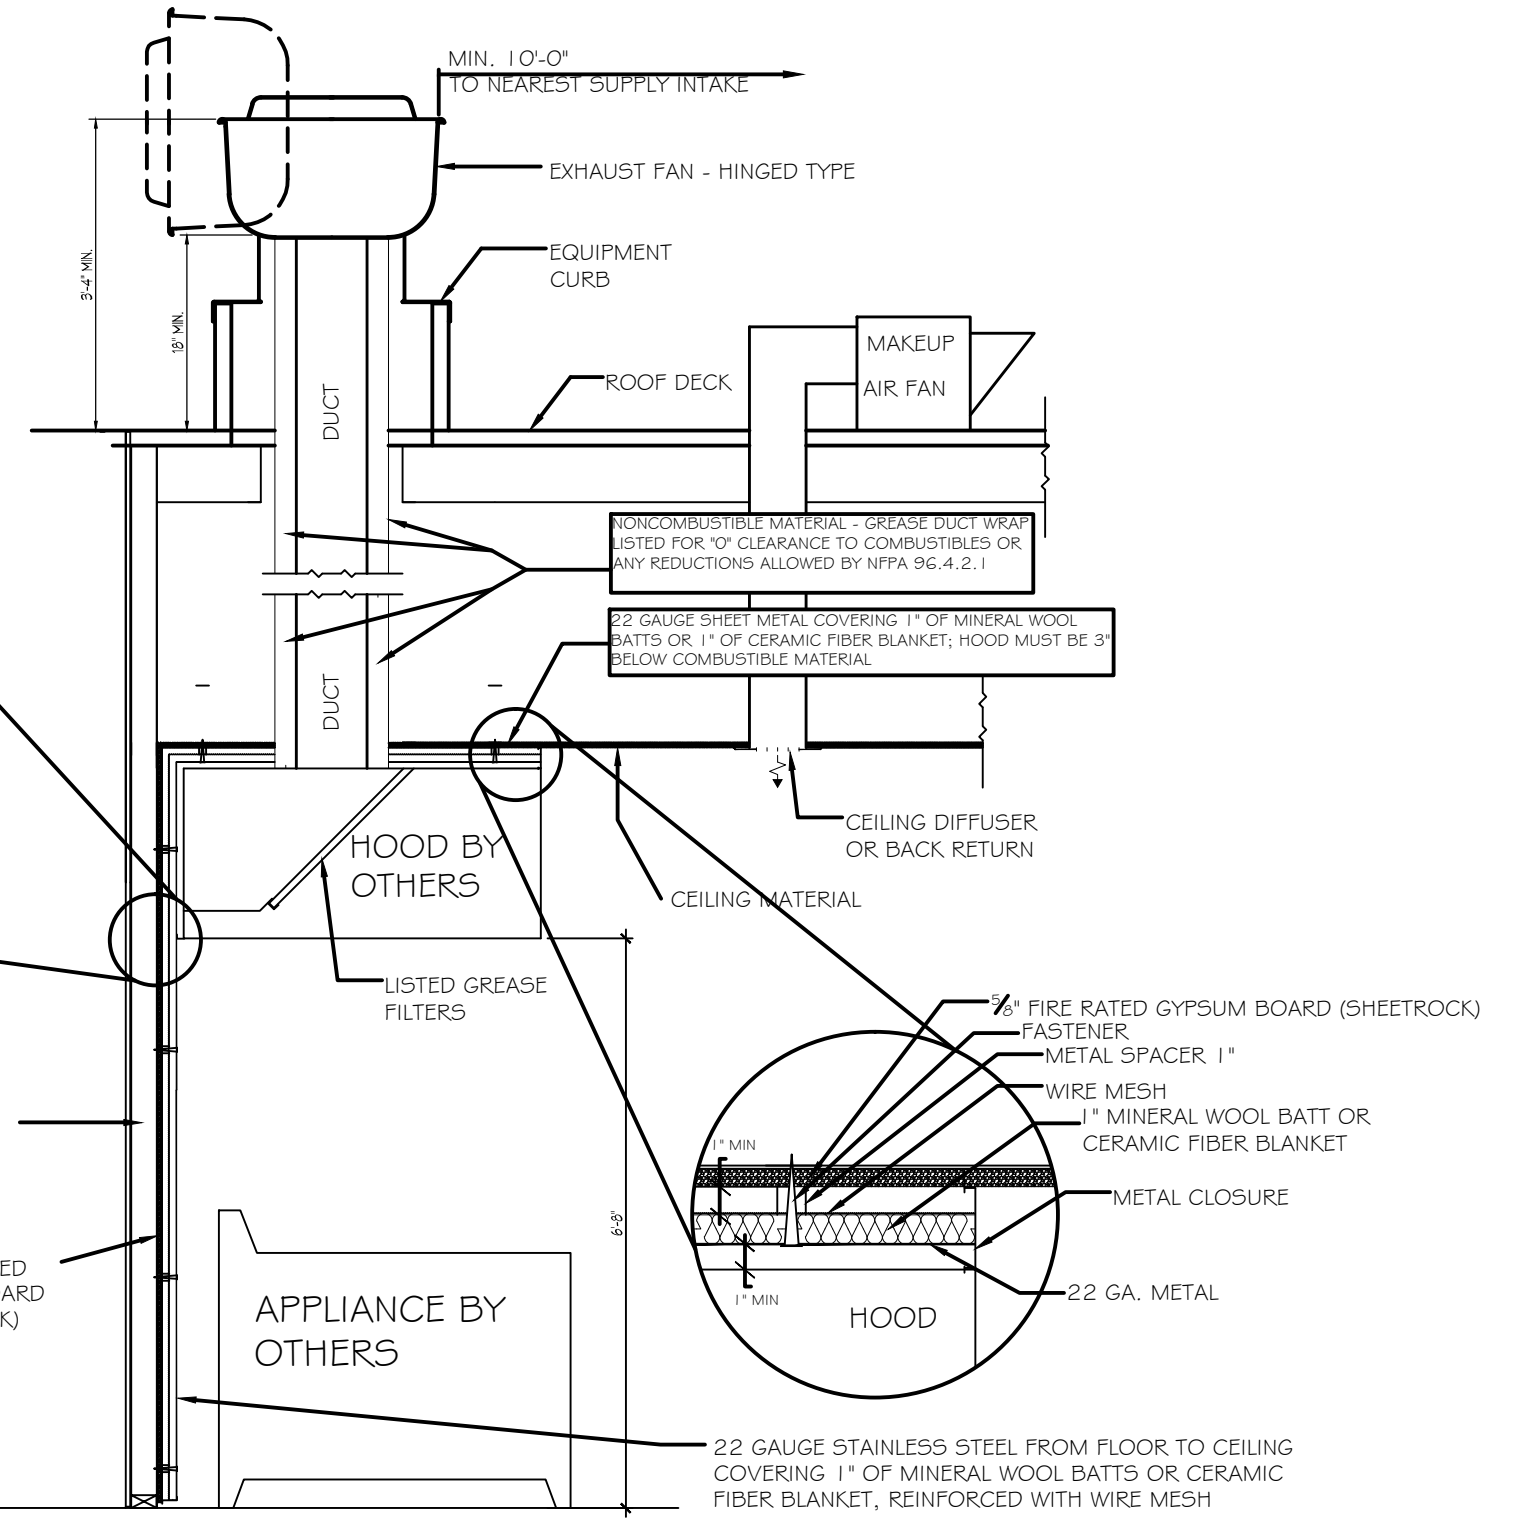
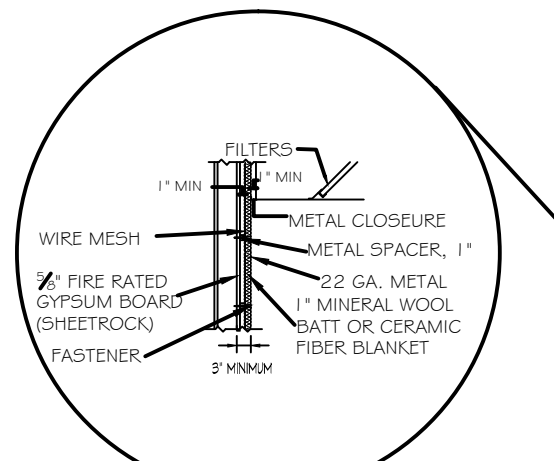


HVAC LEGEND

- 2x2 SUPPLY AIR GRILLE W/DAMPER
- RETURN AIR GRILLE
- SIDE-WALL SUPPLY AIR GRILLE W/DAMPER
- ROOFTOP AC UNIT
- DUCTLESS MINI-SPLIT AIR HANDLING UNIT
- EXHAUST FAN
- THERMOSTAT
- INLINE DUCT SMOKE DETECTOR
- INFRARED GAS-FIRED TUBE HEATERS
- SUPPLY AIR DUCT
- RETURN AIR DUCT
- ROUND FLEX DUCT, MAX. LENGTH 12'-0", MIN. R-6. PROVIDE MAN. DAMPER AT DIFFUSER CONNECTIONS.

NOTE-1: MECHANICAL PLAN IS DRAWN DIAGRAMATIC. DUCT LOCATIONS ARE FOR REFERENCE ONLY. FIELD LOCATE AS NEEDED BETWEEN JOISTS OR TRUSSES.


NOTE-2: COORDINATE LOCATION OF ALL SUPPLY AIR DIFFUSERS, RETURN AIR GRILLES, EXHAUST FANS, ETC... WITH LIGHTING PLAN.

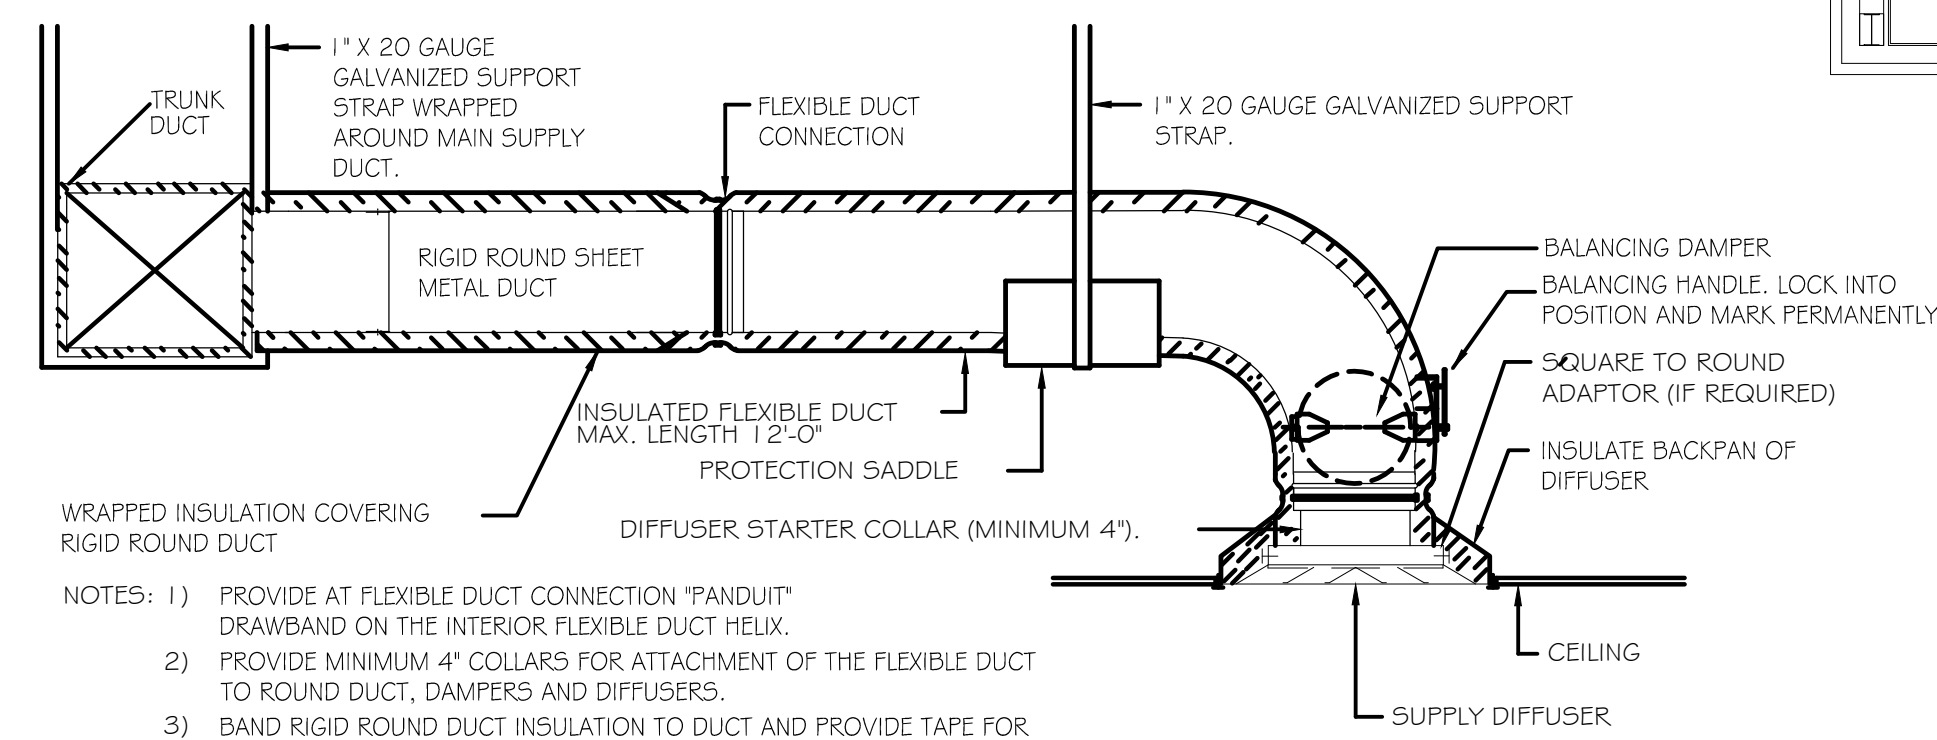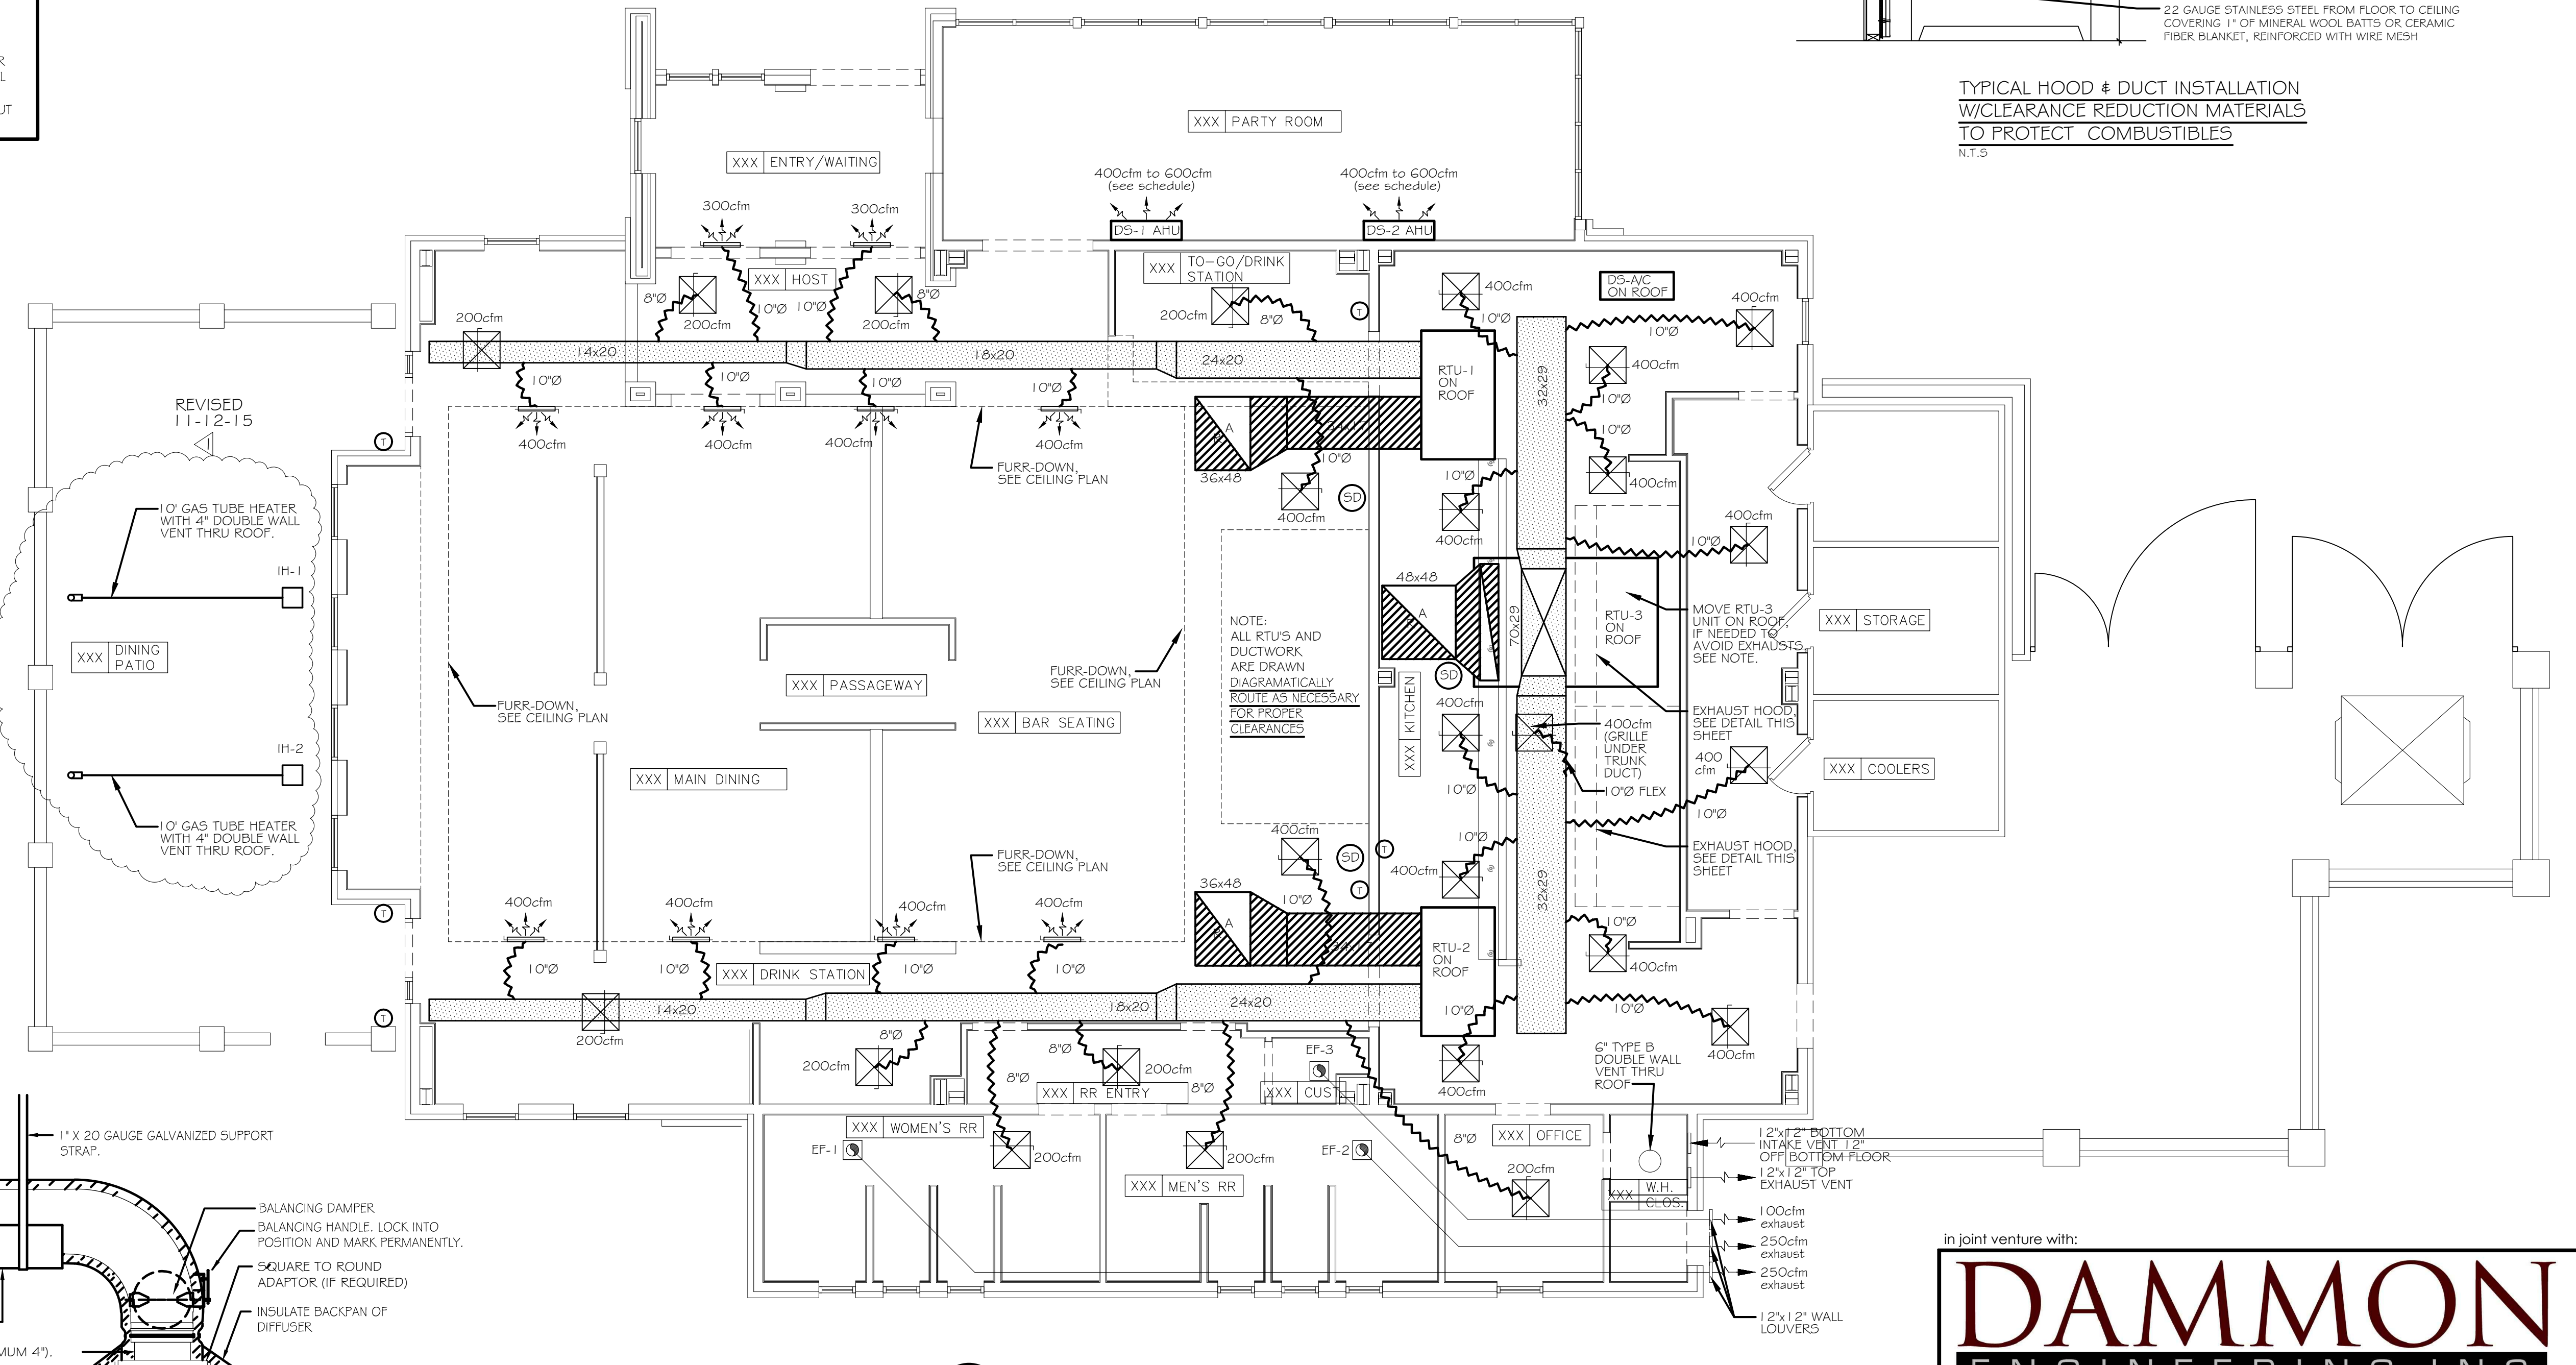

- NOTES:
- 1) PROVIDE AT FLEXIBLE DUCT CONNECTION "PANOUT" DRAWING ON THE INTERIOR FLEXIBLE DUCT HELIX.
 - 2) PROVIDE MINIMUM 4" COLLARS FOR ATTACHMENT OF THE FLEXIBLE DUCT TO ROUND DUCT, DAMPERS AND DIFFUSERS.
 - 3) BAND RIGID ROUND DUCT INSULATION TO DUCT AND PROVIDE TAPE FOR INSULATION OVERLAP.

MECHANICAL PLAN
3/16" = 1'-0"

project no. 20-1348
drawn JTL
checked CKD
date 10.06.2014
revised 11/13/2015
00.00.0000
00.00.0000

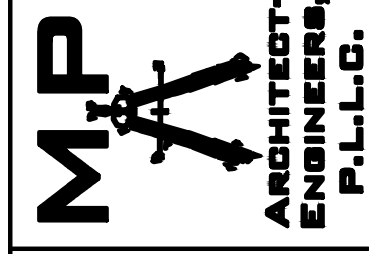

MP Architect-Engineers, P.L.L.C.
RICHARD C. MEYER, P.E.
JAMES J. PAPIA, ARCHITECT

MECHANICAL PLAN & DETAILS
MUGSHOTS GRILL & BAR
RIDGELAND, MISSISSIPPI
HARBOUR POINTE DEVELOPMENT

sheet no. M001
of 42 sheets

in joint venture with:

DAMMON ENGINEERING, INC.
Architects & Engineers

Chief Engineer: Brian Mistich, PE
554 Old Spanish Trail
Slidell, LA 70458

www.dammonengineering.com
dammoneng@bellsouth.net
PH: 985.649.5832
F: 985.641.5950