



**14 REFLECTED CEILING PLAN**  
SCALE: 1/4" = 1'-0"

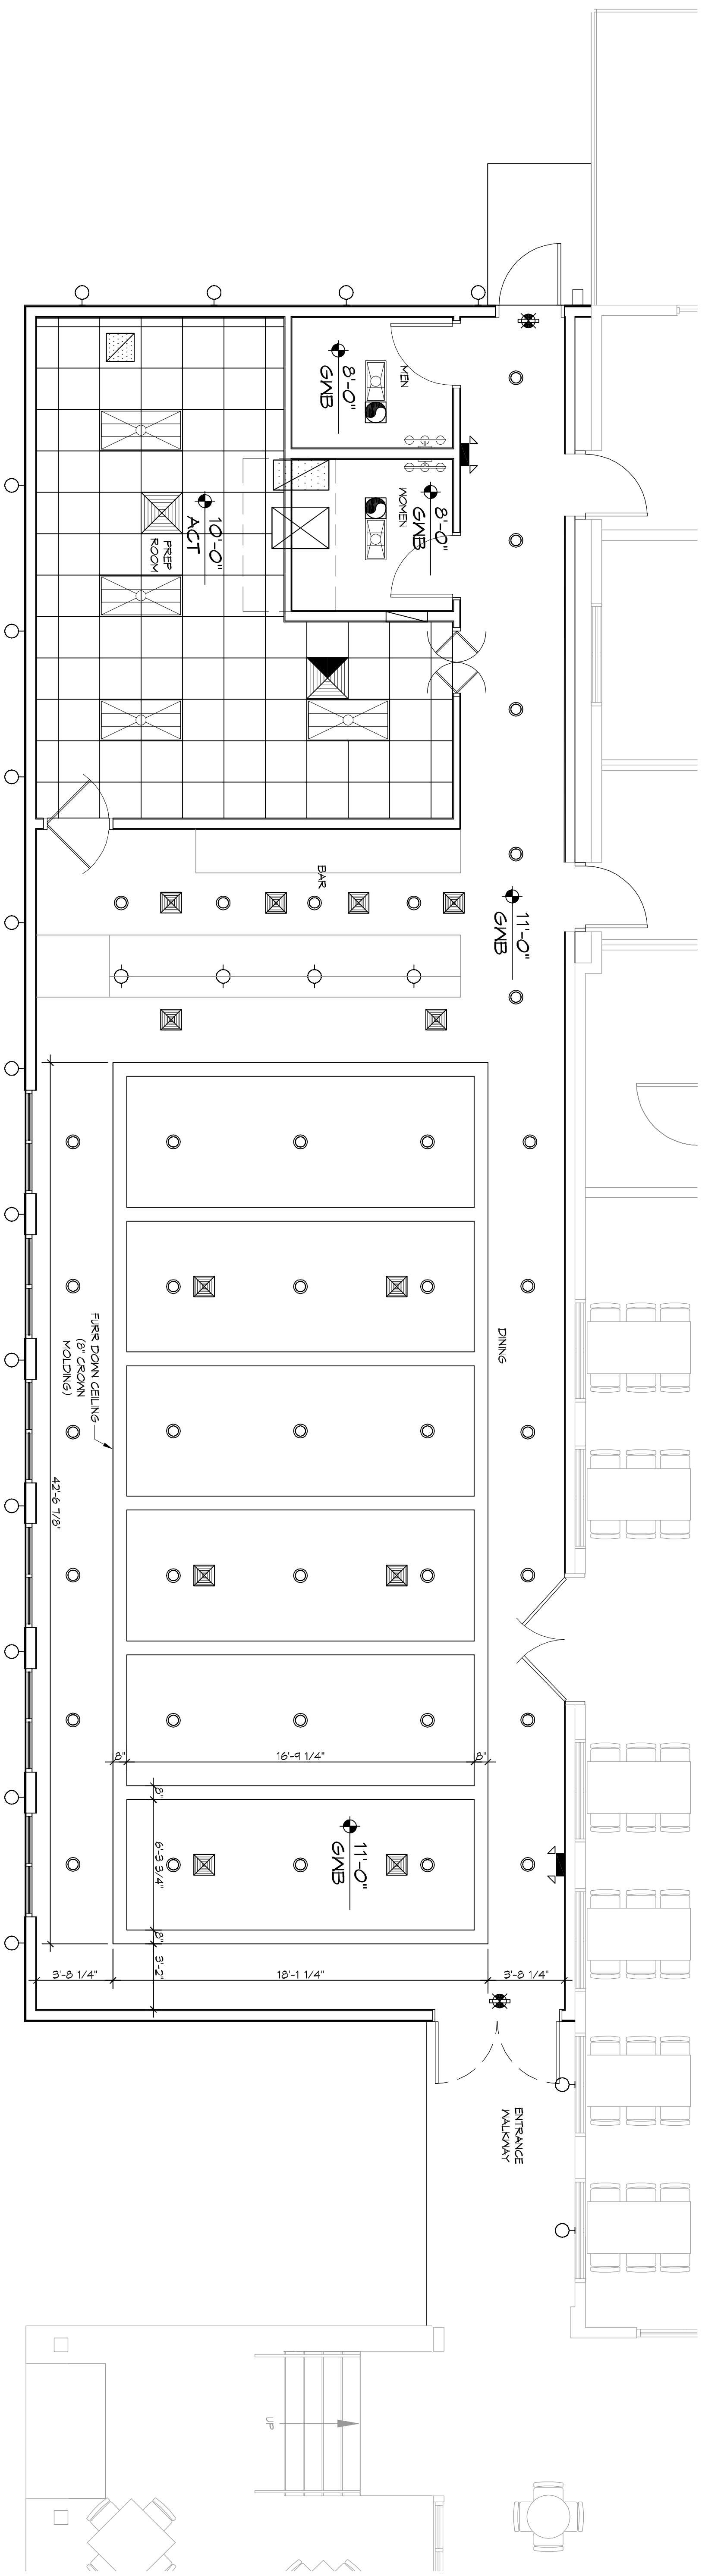

**FUR DOWN CEILING DETAIL**  
SCALE: 3/4" = 1'-0"

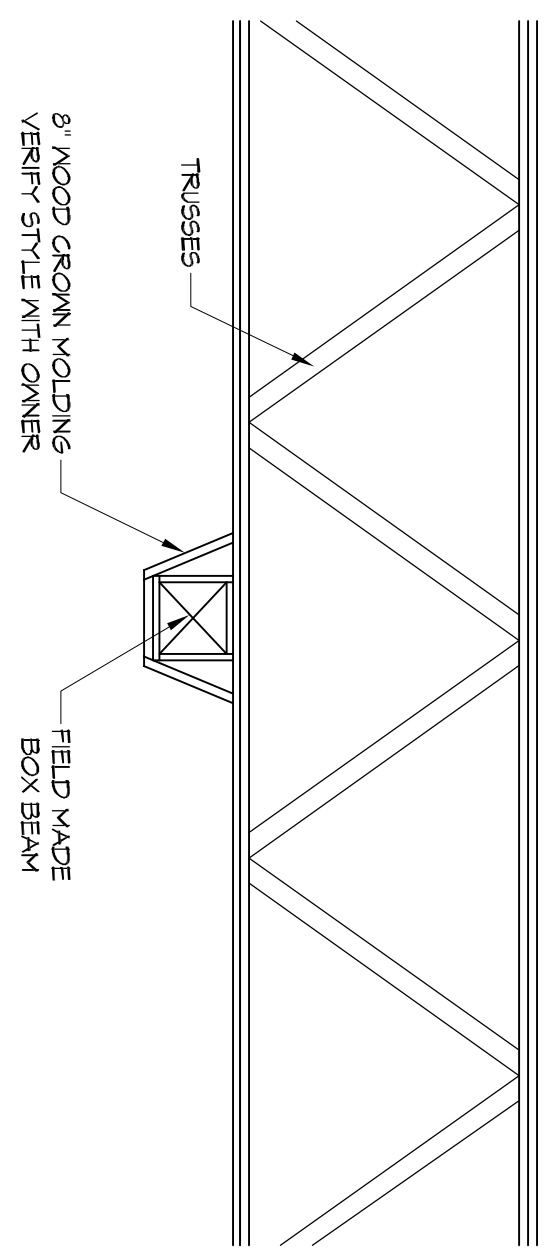

LEGEND	
	AIR SUPPLY GRILLE (24X24)
	RETURN AIR GRILLE
	AIR SUPPLY GRILLE (12X12)
	EMERGENCY LIGHT
	RECESSED LIGHT
	PENDANT LIGHT
	EXTERIOR WALL LIGHT
	2X4 FLUORESCENT LIGHT
	CEILING MOUNTED EXIT LIGHT
	VANITY LIGHT

NEW DINING ADDITION  
**SOUTHSIDE CAFE**  
3154 PONTCHARTRAIN DR  
SLIDELL, LA 70458  
JOB No: 2354 DATE: 02-07-2019  
DRAWN BY: JAG/MJ CHECKED BY: JMS



REVISIONS	
#	DESCRIPTION

**DAMMON ENGINEERING, INC.**  
LOUISIANA & MISSISSIPPI  
Chief Engineer: Brian Mistich, PE  
554 Old Spanish Trail  
Slidell, LA 70458  
www.dammonengineering.com  
info@dammonengineering.com  
PH: 985.649.5832

**A104**  
DRAWING NUMBER:  
SHEET NO: 12 OF 15