
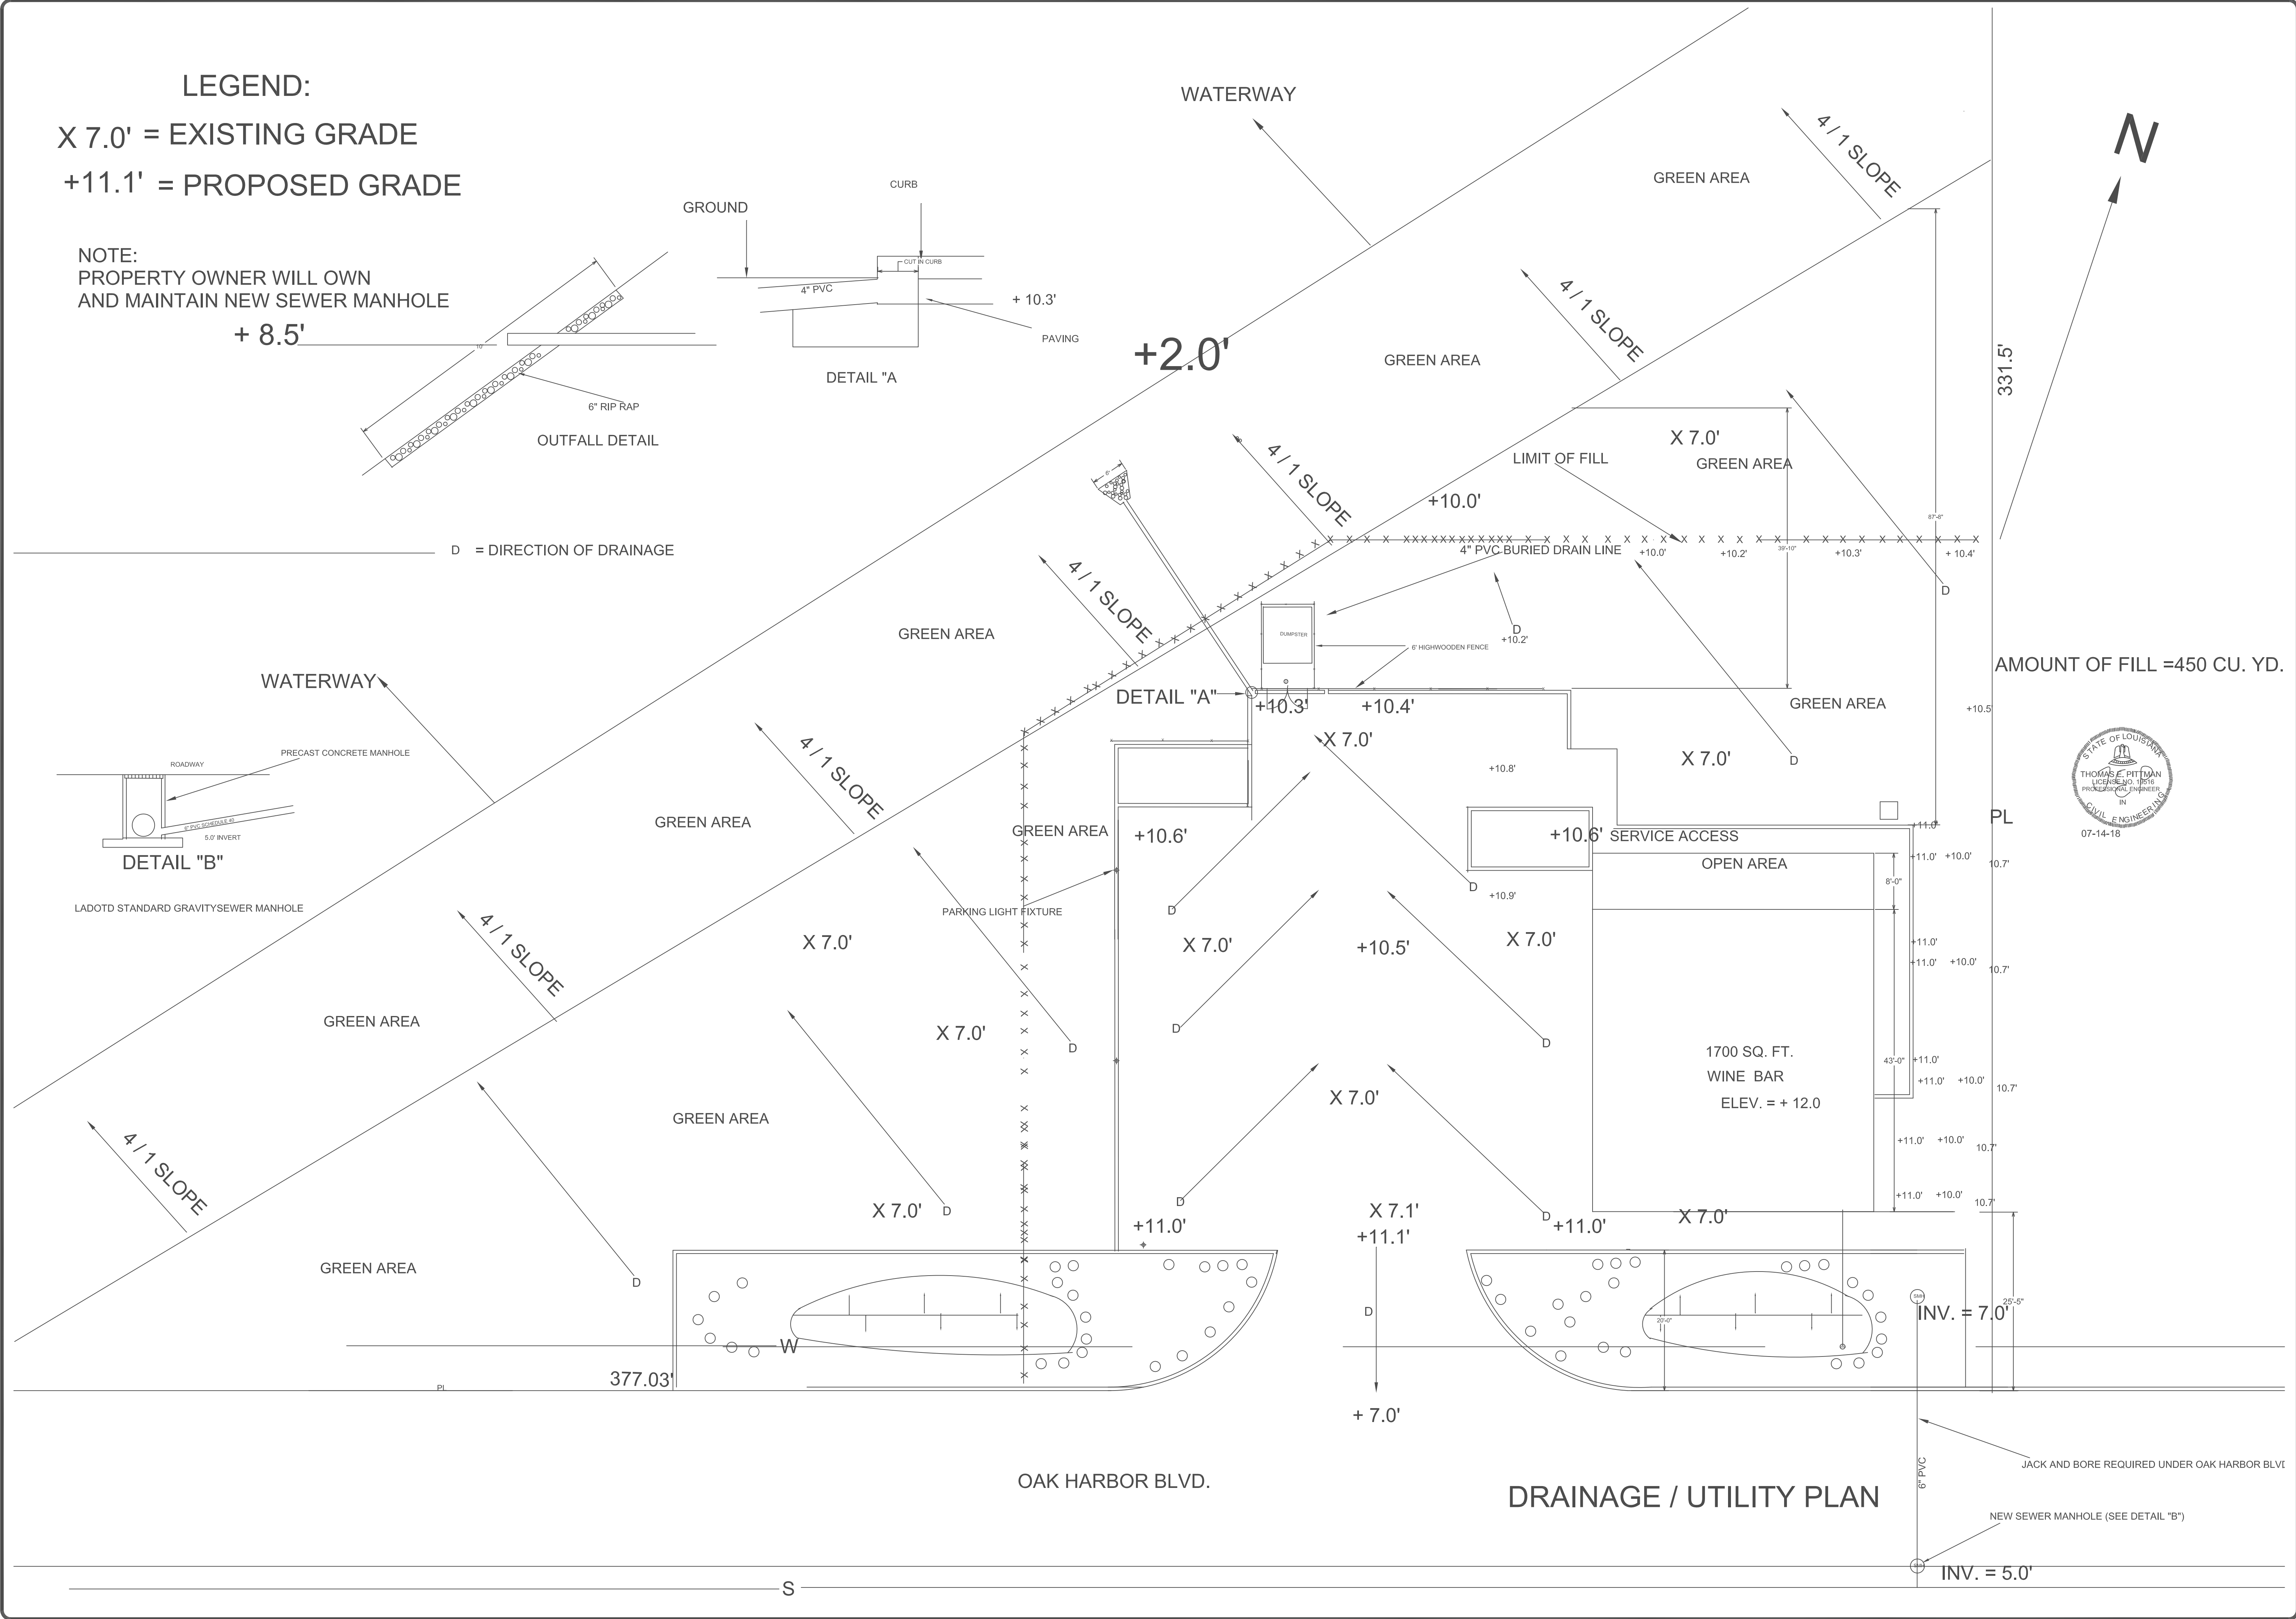
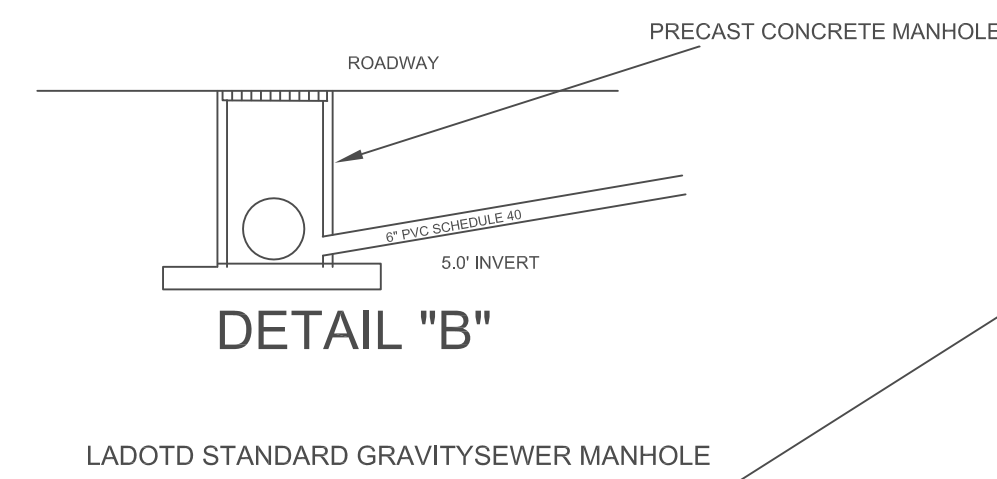
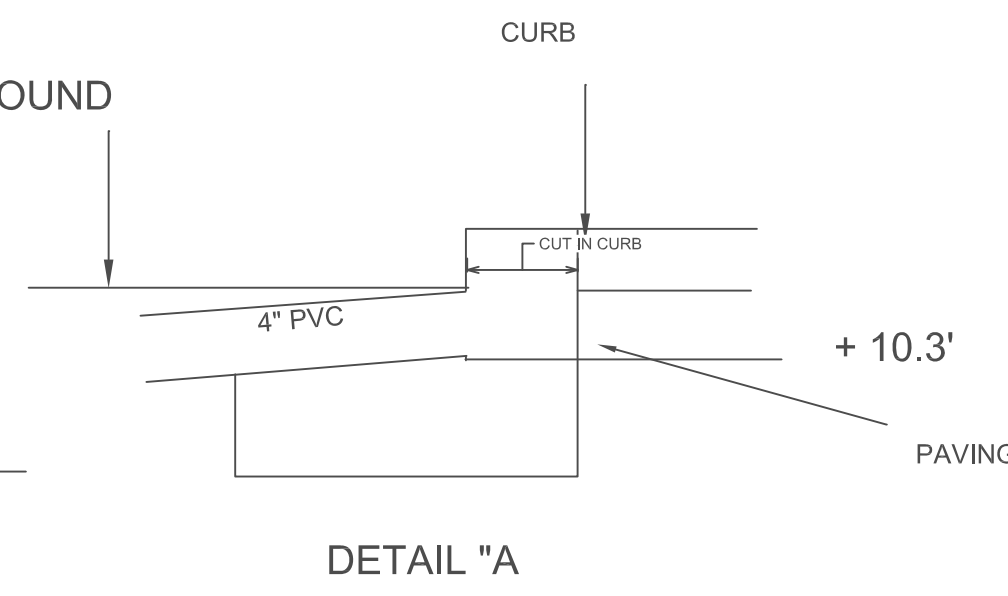



LEGEND:

X 7.0' = EXISTING GRADE
 +11.1' = PROPOSED GRADE

NOTE:
 PROPERTY OWNER WILL OWN
 AND MAINTAIN NEW SEWER MANHOLE
 + 8.5'

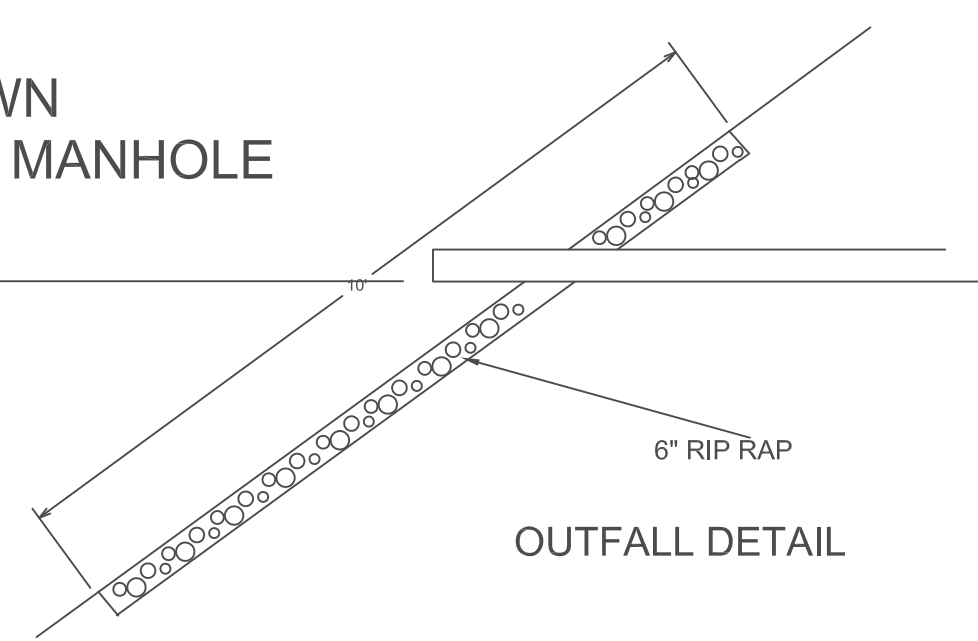

AMOUNT OF FILL = 450 CU. YD.

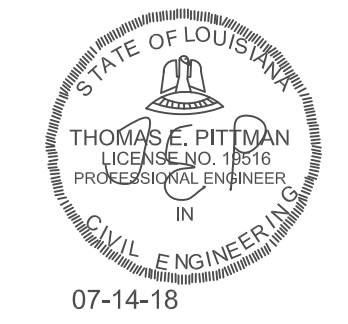

DRAINAGE / UTILITY PLAN

REVISIONS		
NO.	DESCRIPTION	DATE
1	RADIUS	10/17/18
2	LIMIT OF FILL	10/17/18
3	UTILITY CONN.	10/17/18
4	OUTFALL DET.	10/17/18
5	MANHOLE SECTION	11/16/18
6	DRAINAGE DETAIL	12/07/18
7	MANHOLE DETAIL	12/07/18

THOMAS E. PITTMAN P. E.
 CONSULTING ENGINEER
 18080 BRANDON DR.
 HAMMOND, LA.
 985-662-5054

DRAWN
TEP
 CHECKED
 DATE
 08/12/17
 SCALE
 3/32" = 1'-0"
 JOB NO.
 SHEET

C5
 OF SHEETS