


PLOT NO. 111 - RESTAURANT'S 2464 - NEWARK, LOUISIANA 2024 FOR APPROVAL. THE INFORMATION CONTAINED HEREIN IS THE PROPERTY OF DAMMON ENGINEERING, INC. DATE: 02/02/2023.

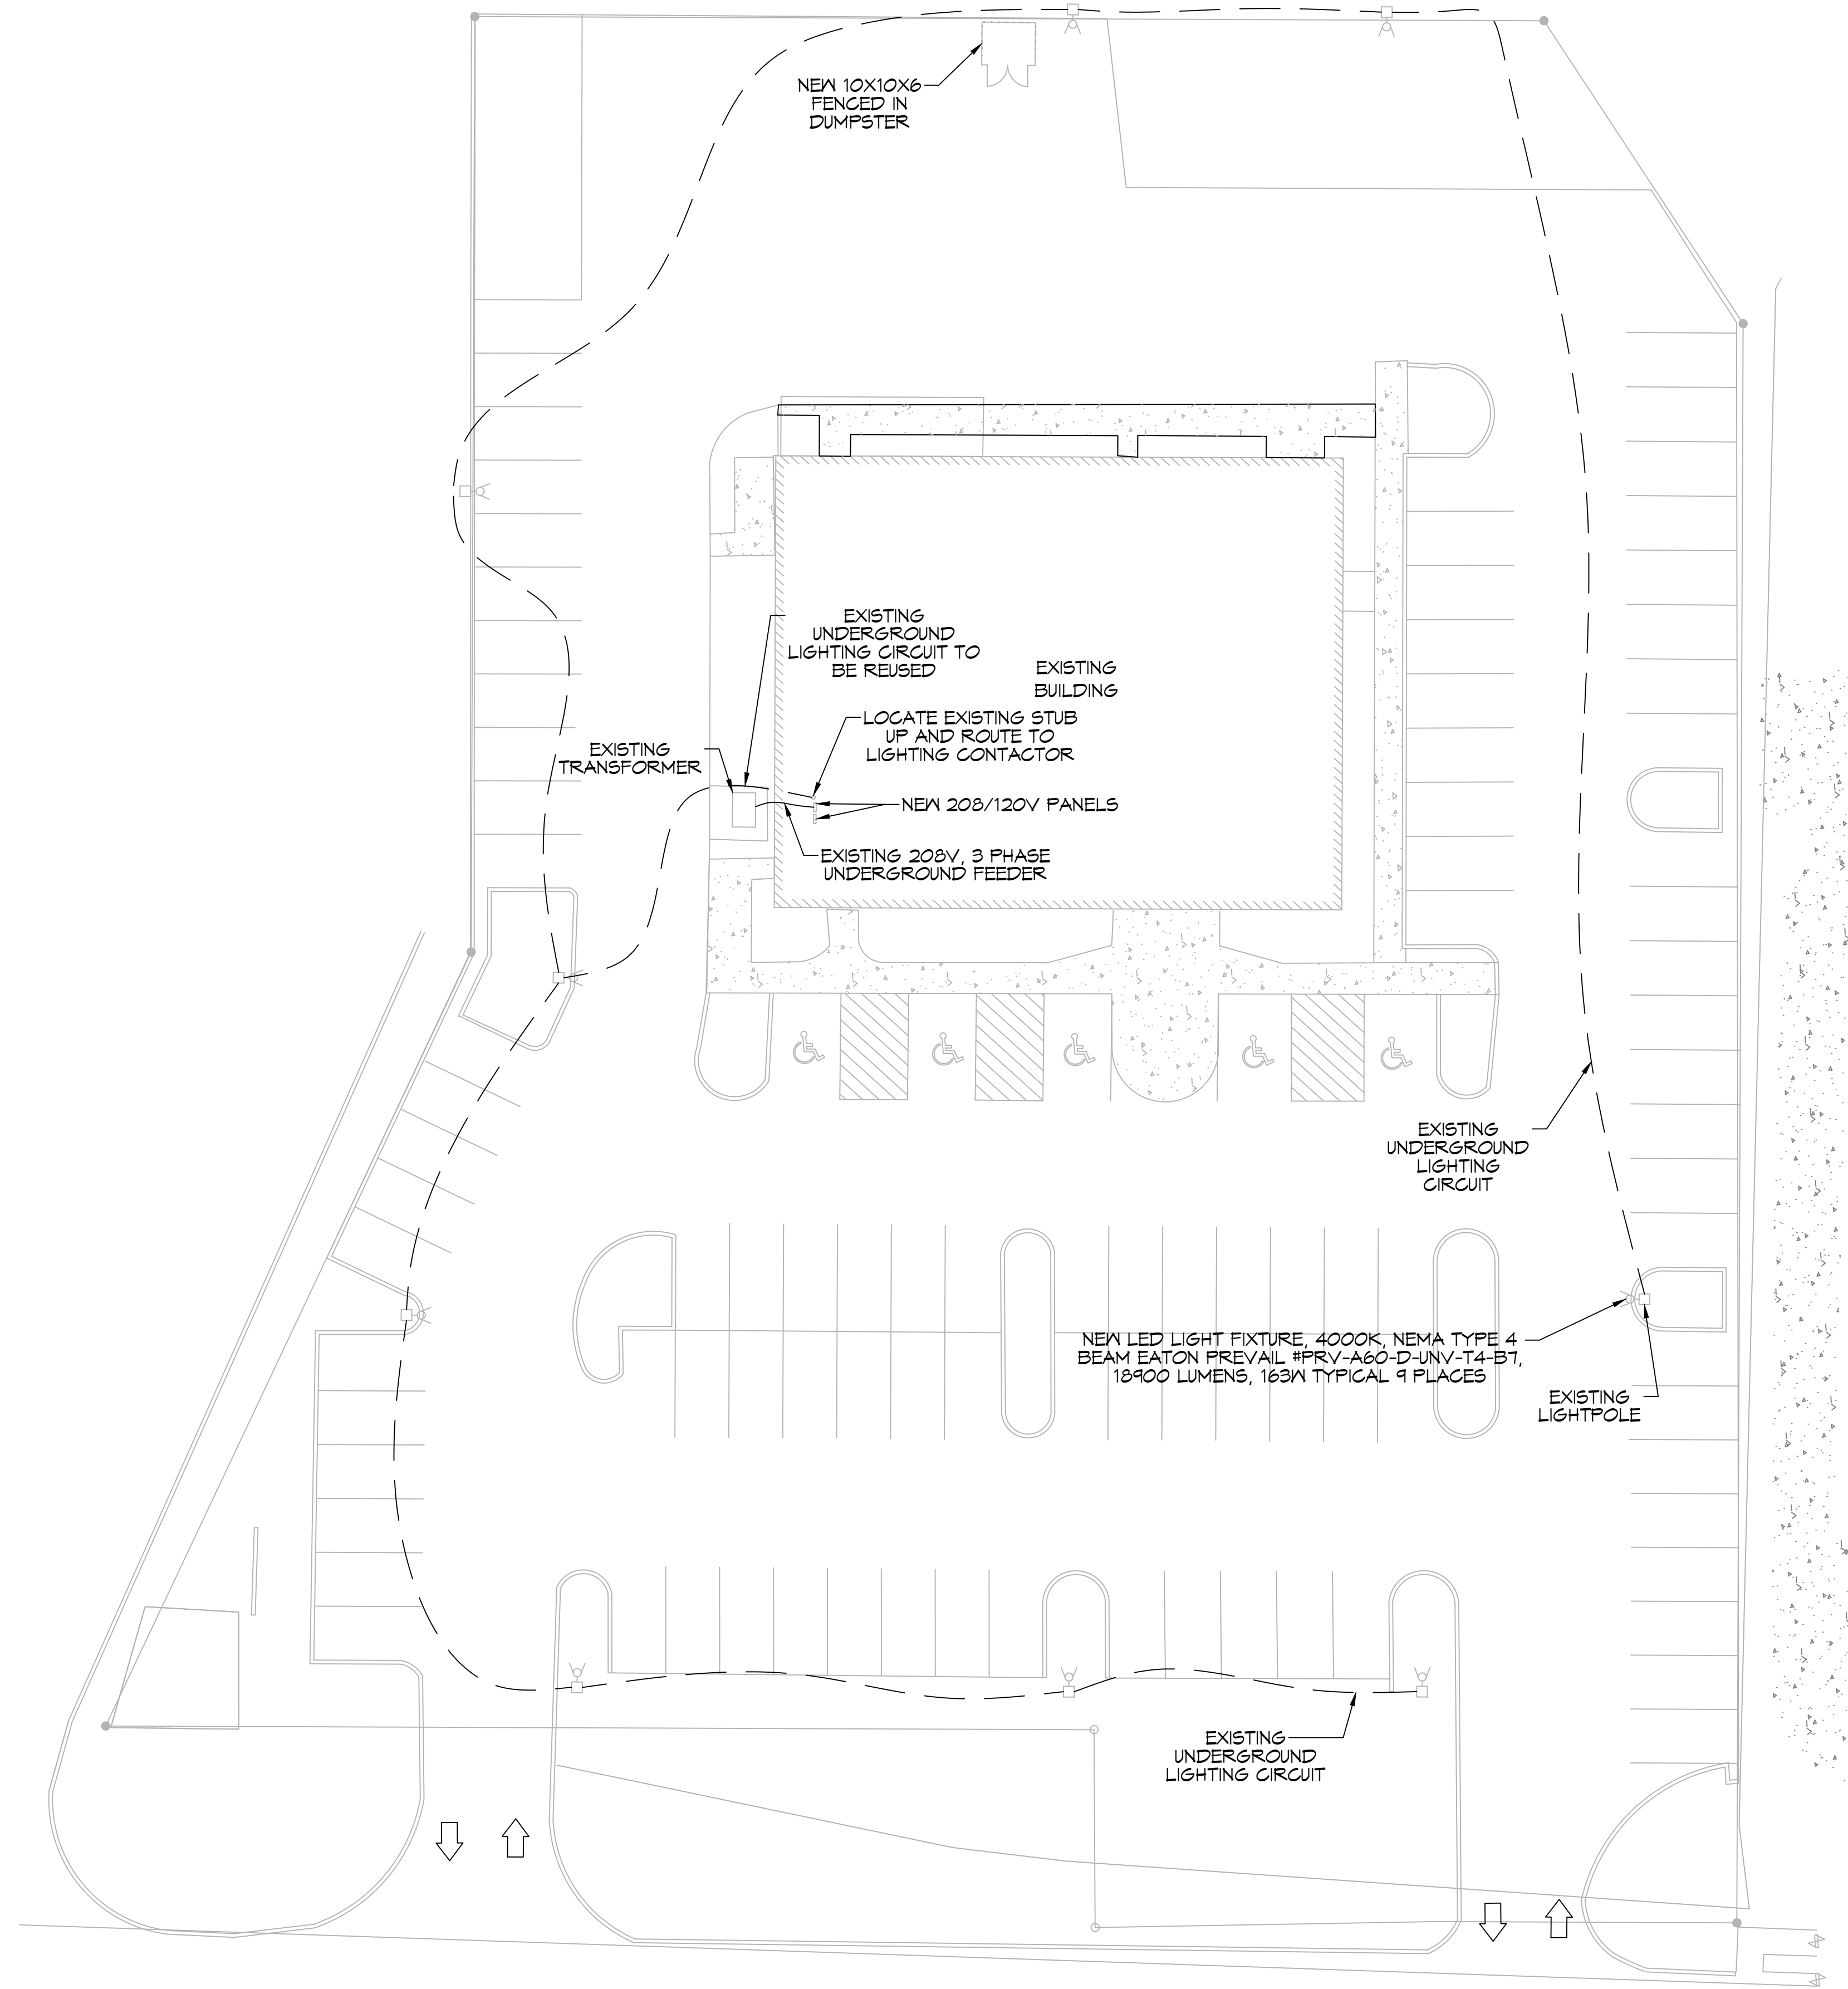

1 SITE LIGHTING PLAN
 SCALE: 1" = 20'

SITE LIGHTING

EXTERIOR LIGHTING SHALL BE SHADED OR INWARDLY DIRECTED IN SUCH A MANNER SO THAT NO DIRECT LIGHTING OR GLARE BE CAST BEYOND THE PROPERTY LINE. THE INTENSITY OF SUCH LIGHTING SHALL NOT EXCEED ONE FOOT CANDLE AS MEASURED AT THE ABUTTING PROPERTY LINE.

DAMMON

ENGINEERING, INC.

LOUISIANA & MISSISSIPPI

Chief Engineer: Brian Mistich, PE
 554 Old Spanish Trail
 Slidell, LA 70488
 www.dammonengineering.com
 info@dammonengineering.com
 PH: 985.649.5832

#	DESCRIPTION	REVISIONS	DATE

SEAL:

NEW LOUNGE RESTAURANT

THE BLAKK LOUNGE RESTAURANT AND BAR

2504 OLD SPANISH TRAIL,
 SLIDELL, LA 70461

JOB No: 2464 DATE: 03/02/2023
 DRAWN BY: CKD CHECKED BY: JMS

SHEET TITLE:
 SITE LIGHTING PLAN

DRAWING NUMBER:
E103