


SITE LIGHTING

EXTERIOR LIGHTING SHALL BE SHADED OR INWARDLY DIRECTED IN SUCH A MANNER SO THAT NO DIRECT LIGHTING OR GLARE BE CAST BEYOND THE PROPERTY LINE. THE INTENSITY OF SUCH LIGHTING SHALL NOT EXCEED ONE FOOT CANDLE AS MEASURED AT THE ABUTTING PROPERTY LINE.

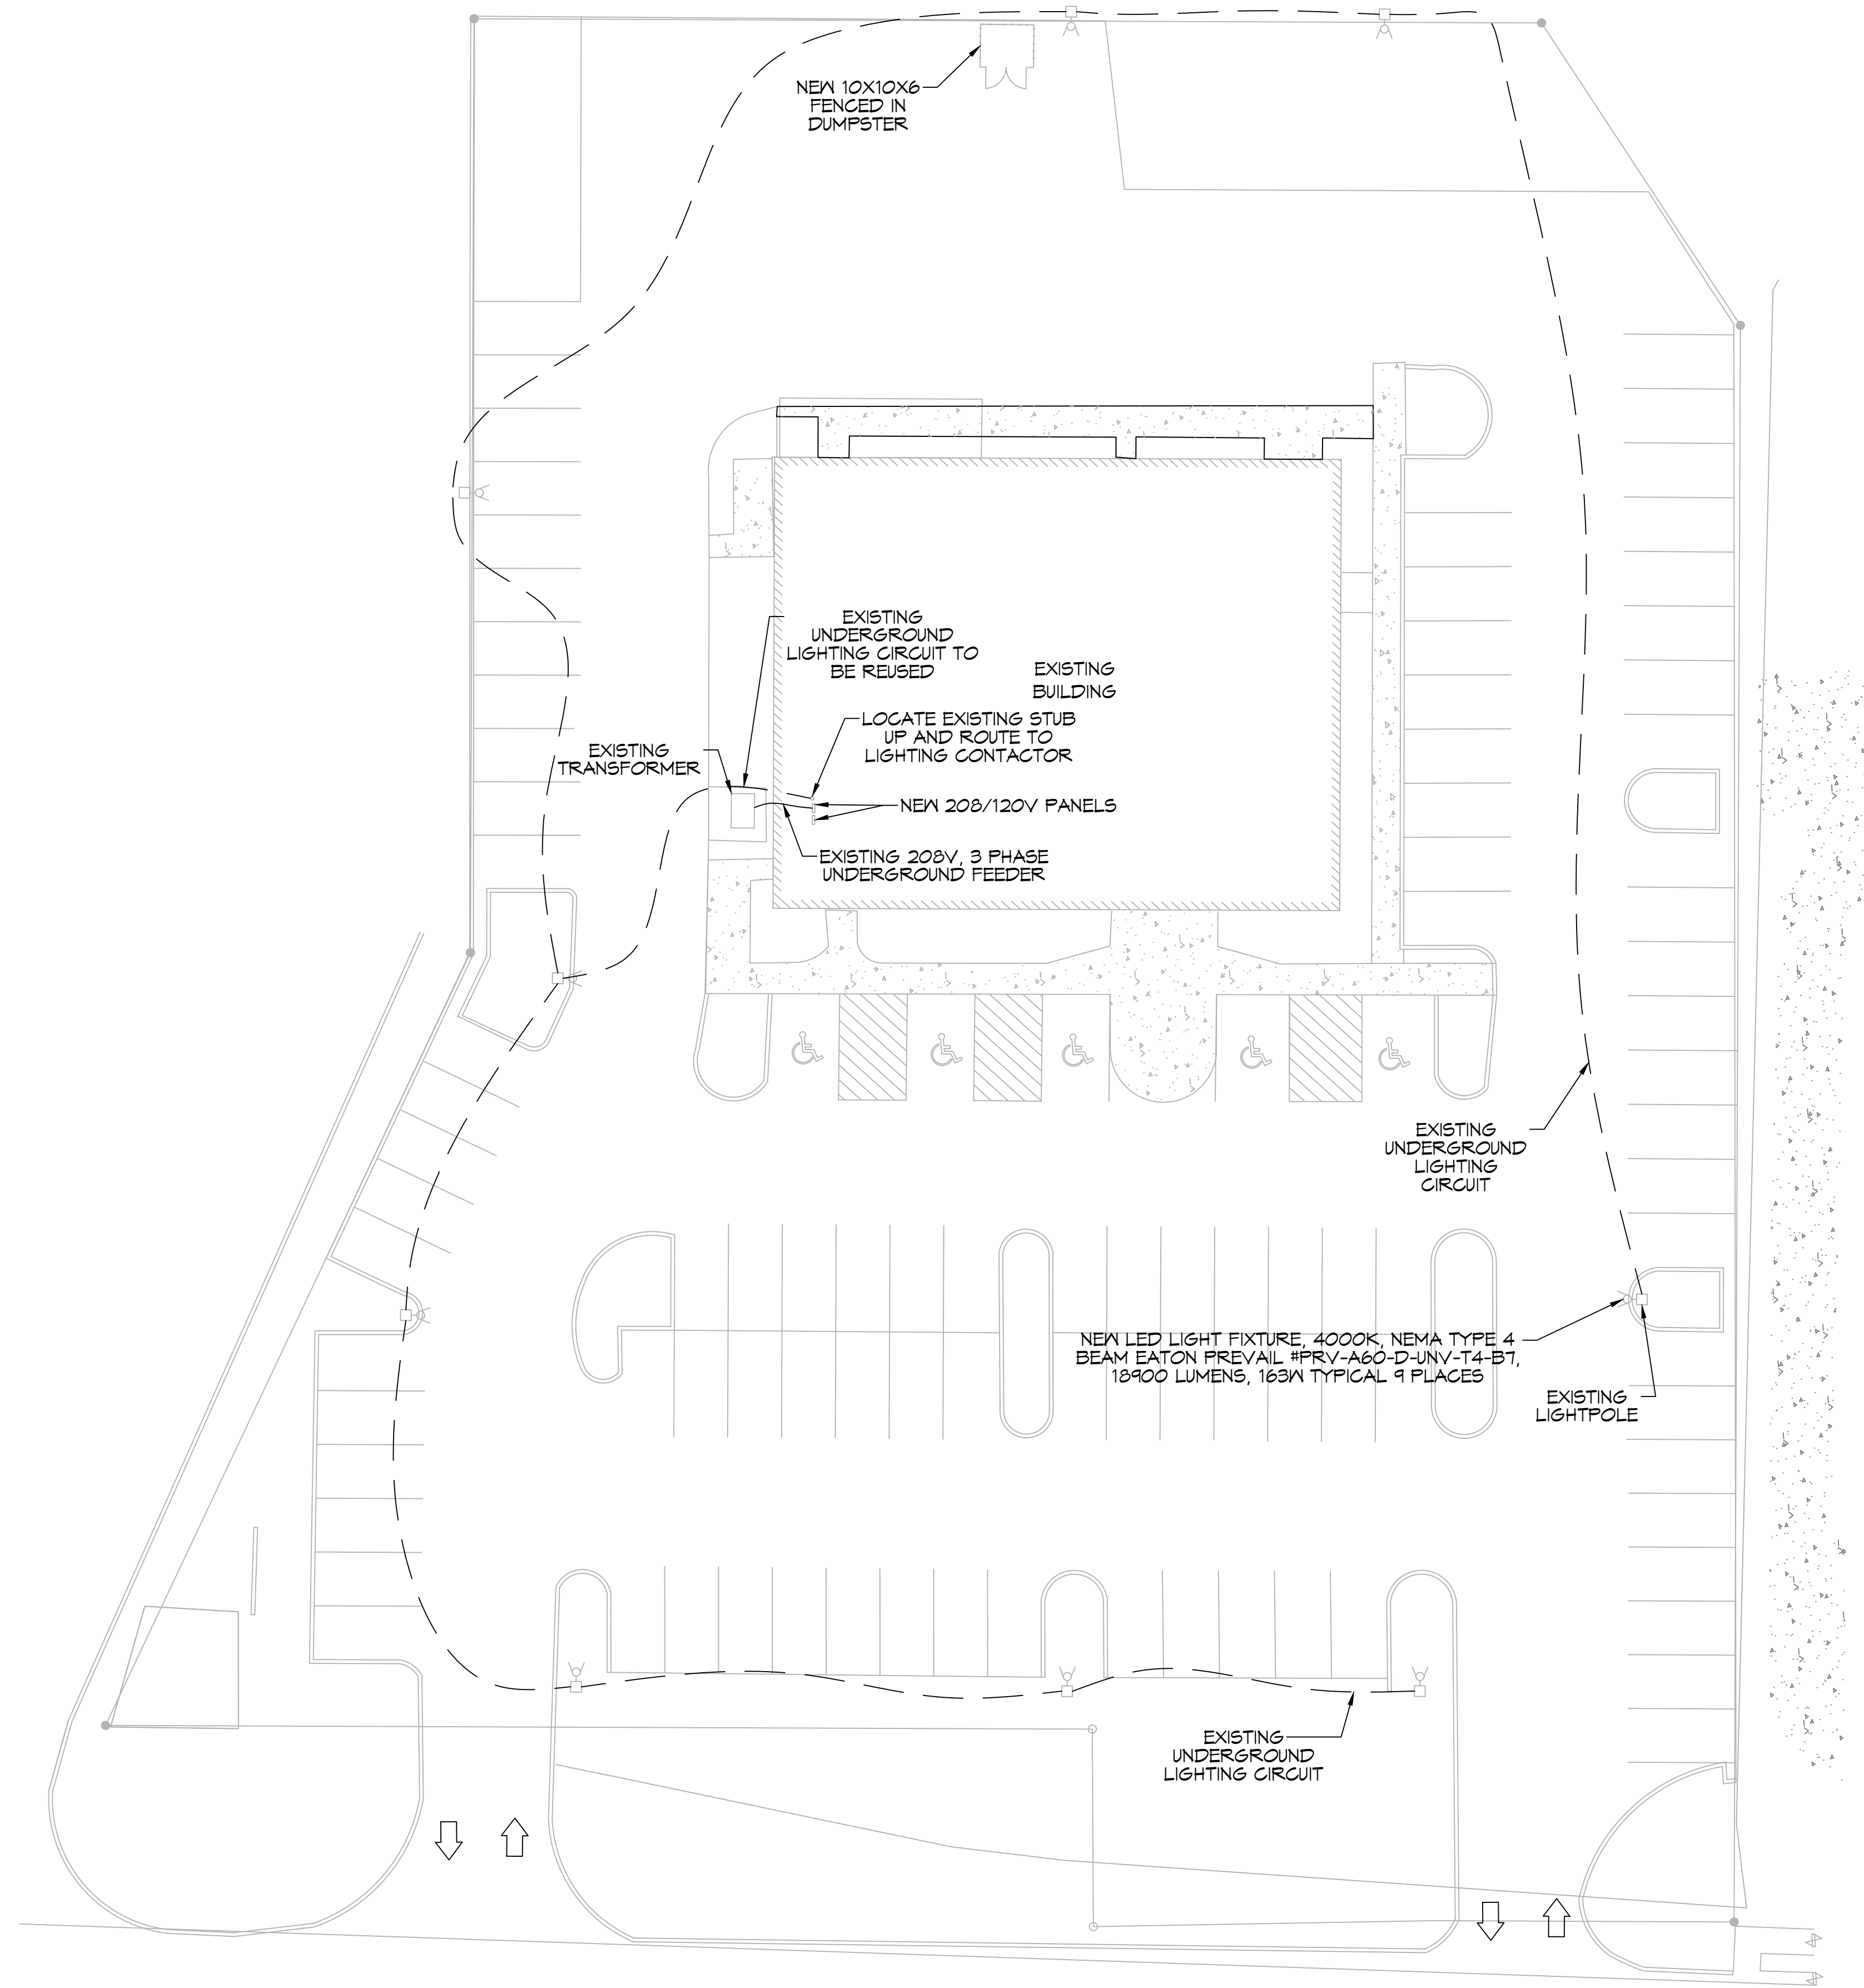

1 SITE LIGHTING PLAN
SCALE: 1" = 20'

DAMMON
ENGINEERING, INC.
LOUISIANA & MISSISSIPPI

Chief Engineer: Brian Mistich, PE
554 Old Spanish Trail
Slidell, LA 70488
www.dammonengineering.com
info@dammonengineering.com
PH: 985.649.5832

#	DESCRIPTION	REVISIONS	DATE



NEW LOUNGE RESTAURANT
THE BLAKK LOUNGE RESTAURANT AND BAR
2504 OLD SPANISH TRAIL,
SLIDELL, LA 70461
JOB No: 2464 DATE: 09/02/2023
DRAWN BY: CKD CHECKED BY: JMS

SHEET TITLE:
SITE LIGHTING PLAN

DRAWING NUMBER:
E103