


1 MECHANICAL PLAN FIRST FLOOR
SCALE: 1/4"=1'-0"

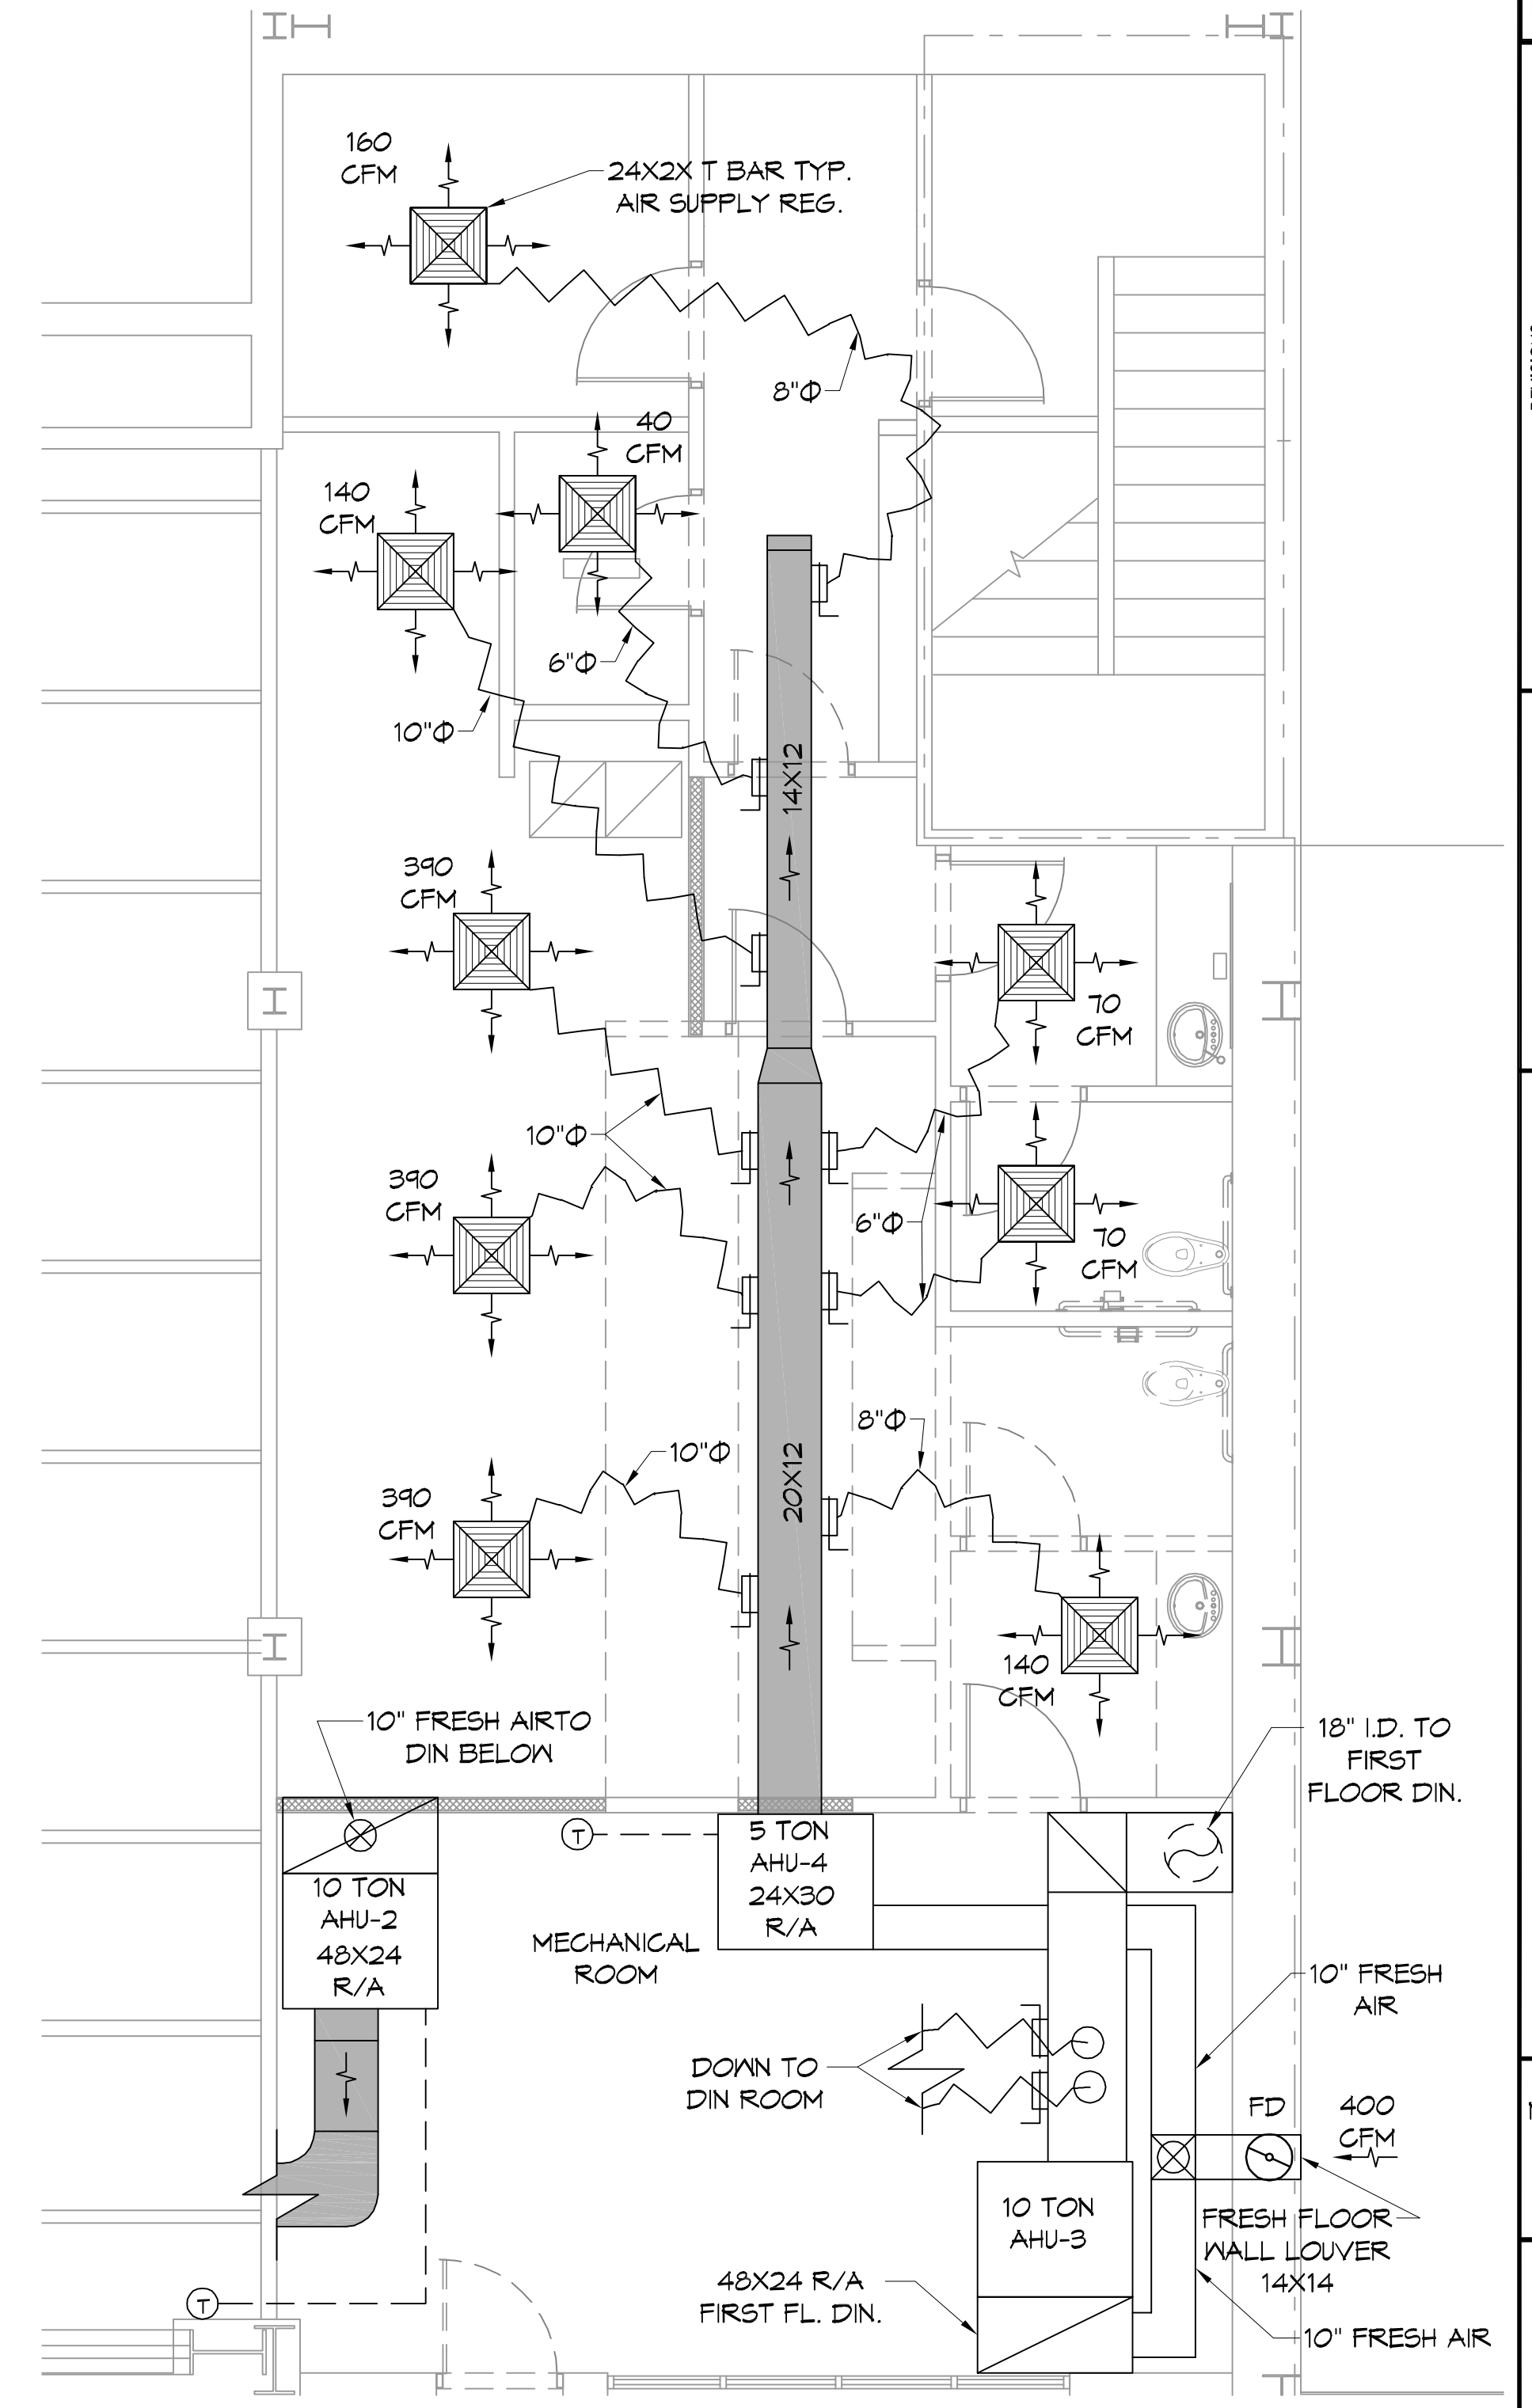

2 MECHANICAL PLAN SECOND FLOOR
SCALE: 1/4"=1'-0"

DAMMON
ENGINEERING, INC.
LOUISIANA & MISSISSIPPI

www.dammonengineering.com
info@dammoneng.com
1000 N. Highway 101, Suite 100
Shreveport, LA 71208
PH: 955.489.8832

Chief Engineer: Brian Mitchell, PE
Project Engineer: Ryan Mitchell, PE
Project Engineer: David Mitchell, PE
Project Engineer: Stephen Mitchell, PE

#	DESCRIPTION	DATE

SEAL:

BERNARD BISTROT

LA HWY 21
COVINGTON, LA 70439

JOB No: 06-16-2021
DATE: 06-16-2021

DRAWN BY: BAW
CHECKED BY: GCD

SHEET TITLE:
MECHANICAL FLOOR PLAN

DRAWING NUMBER:
M101

SHEET No: 1 of 2