


POTABLE WATER IMPROVEMENTS

AWG DEVELOPMENT


TOWN OF PEARL RIVER

ST. TAMMANY PARISH, LOUISIANA

INDEX TO DRAWINGS	
SHEET NO.	TITLE/DESCRIPTION
--	TITLE
1	AVE D SHEET INDEX AND GENERAL NOTES
1	AVE D PLAN AND PROFILE STATION 0+00 TO 06+00
2	AVE D PLAN AND PROFILE STATION 06+00 TO 12+00
3	AVE D PLAN AND PROFILE STATION 12+00 TO 16+00
4	AVE D WATER MAIN TIE-IN DETAILS
5	AWG WATER LINE
6	BACKFLOW PREVENTER AND METER
7	WATER VALVE DETAILS
8	MISC. WATER DETAILS

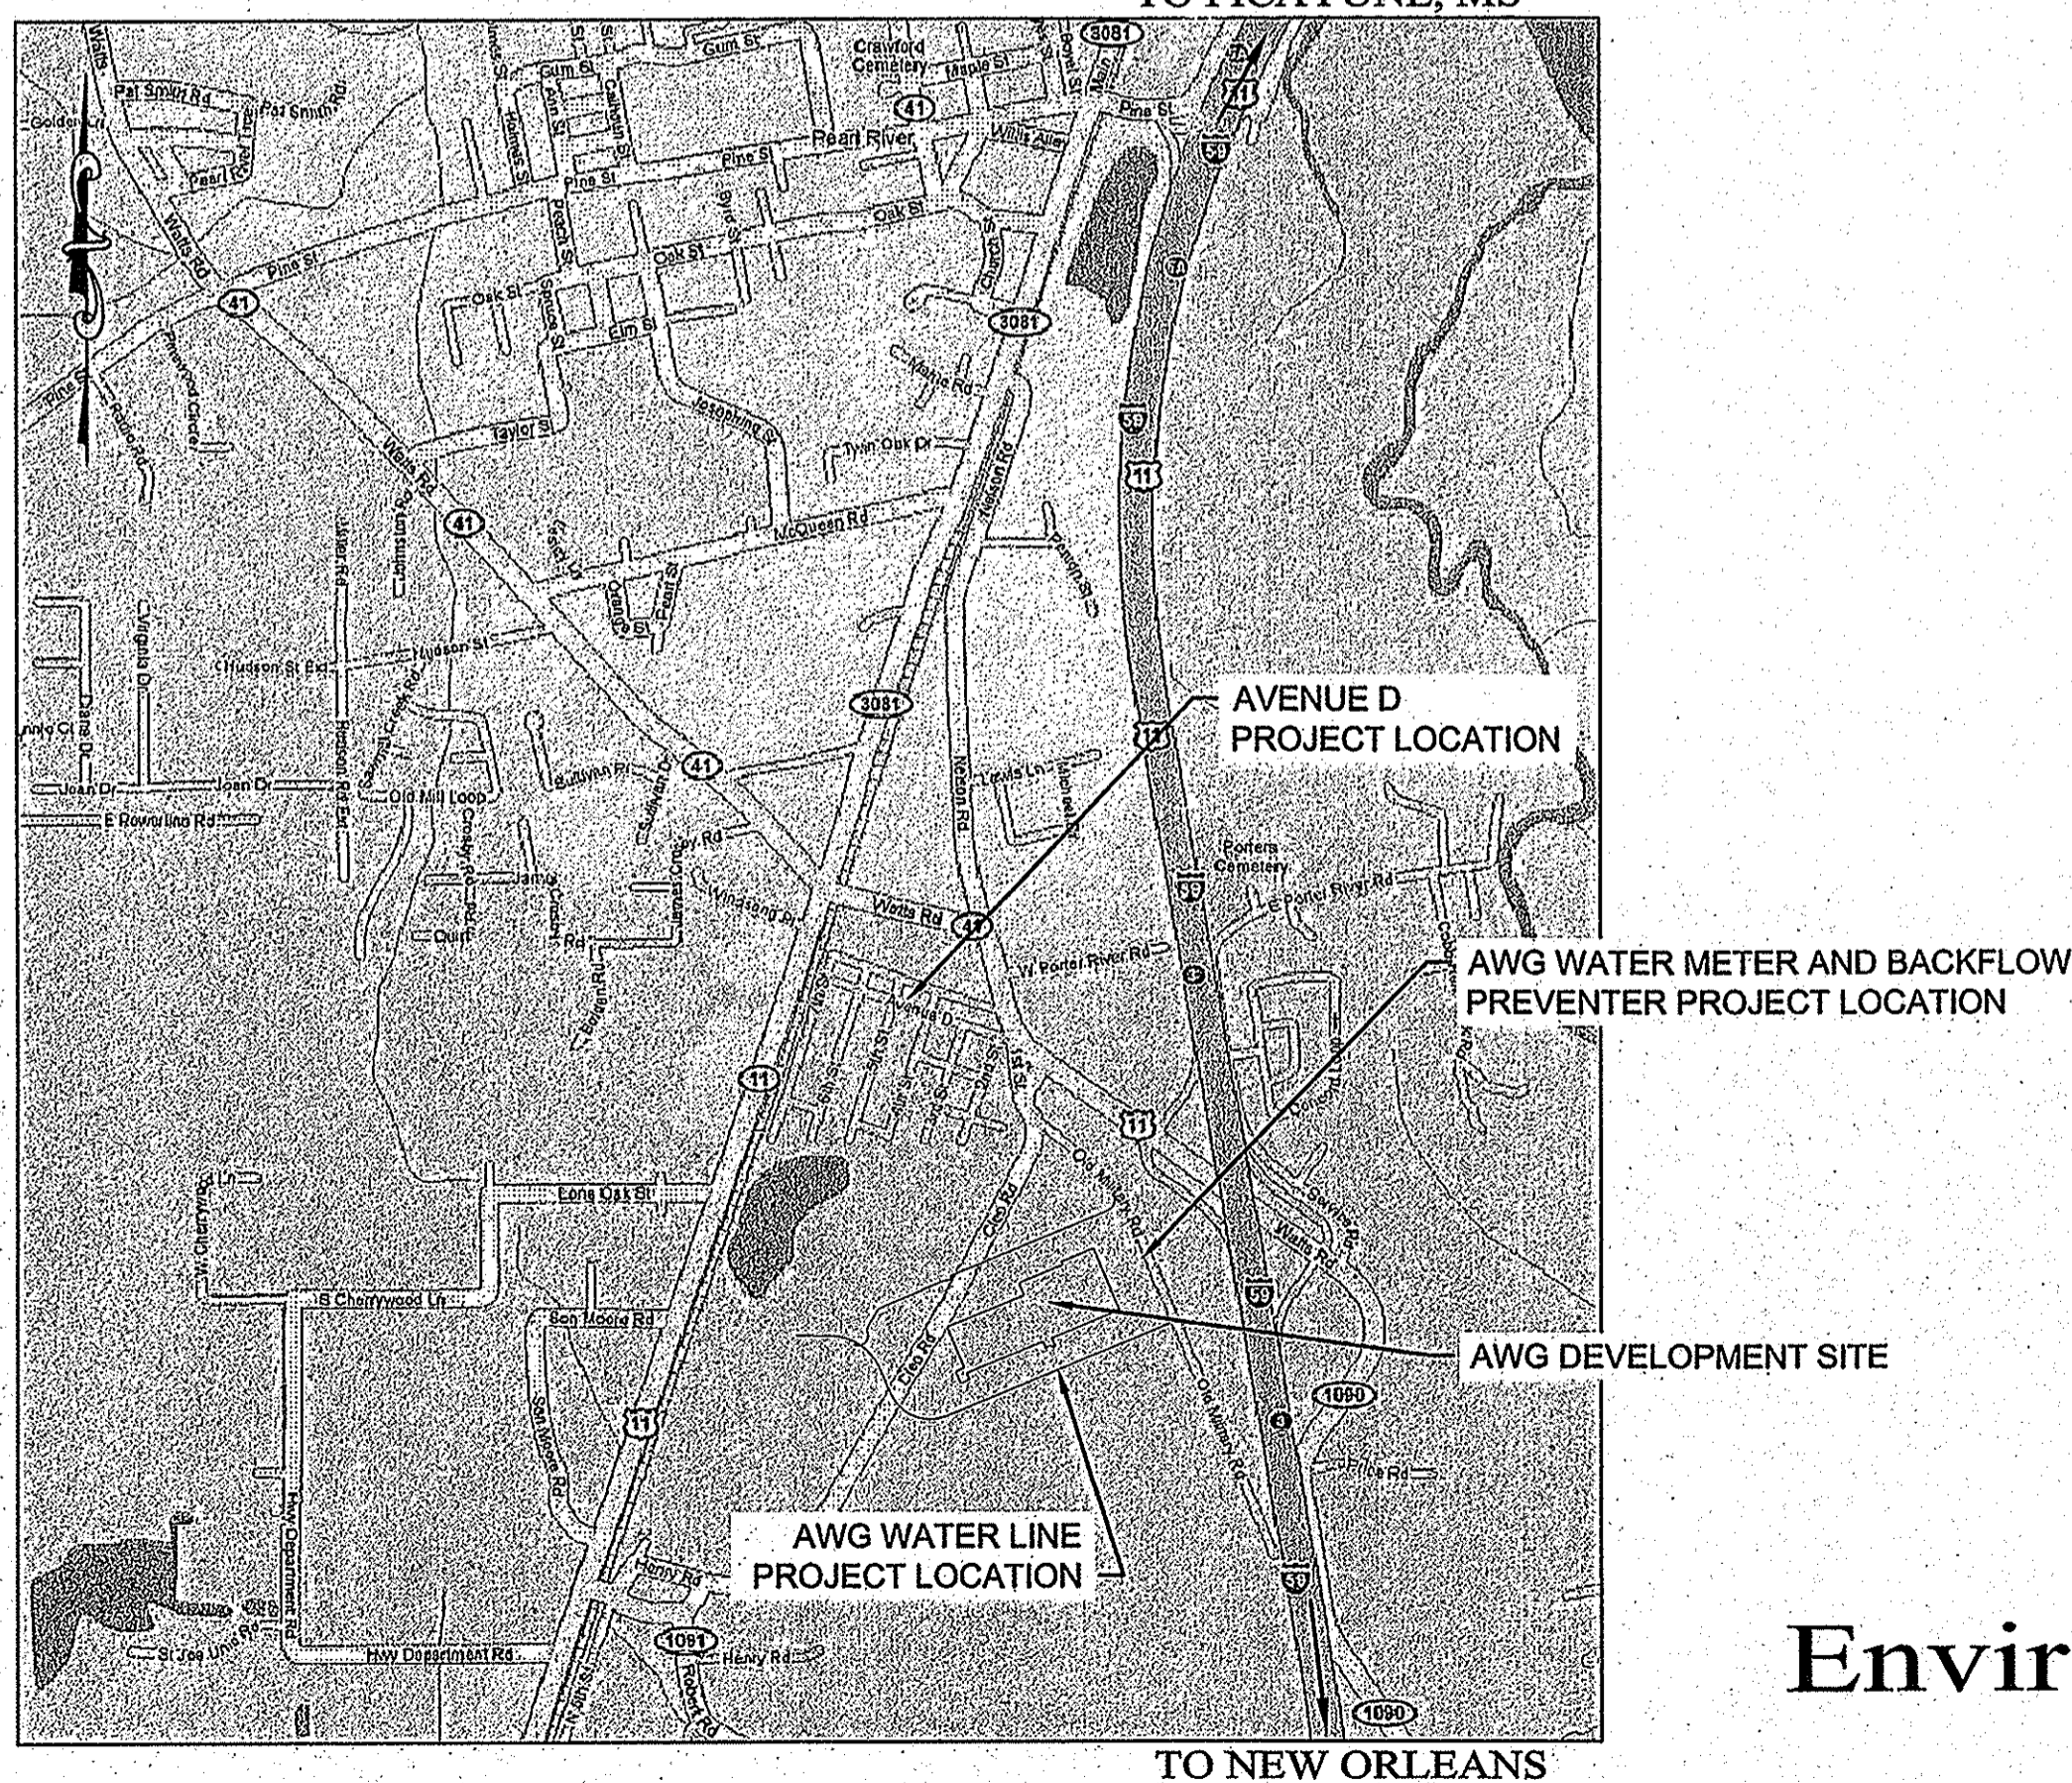

LOCATION MAP
NTS

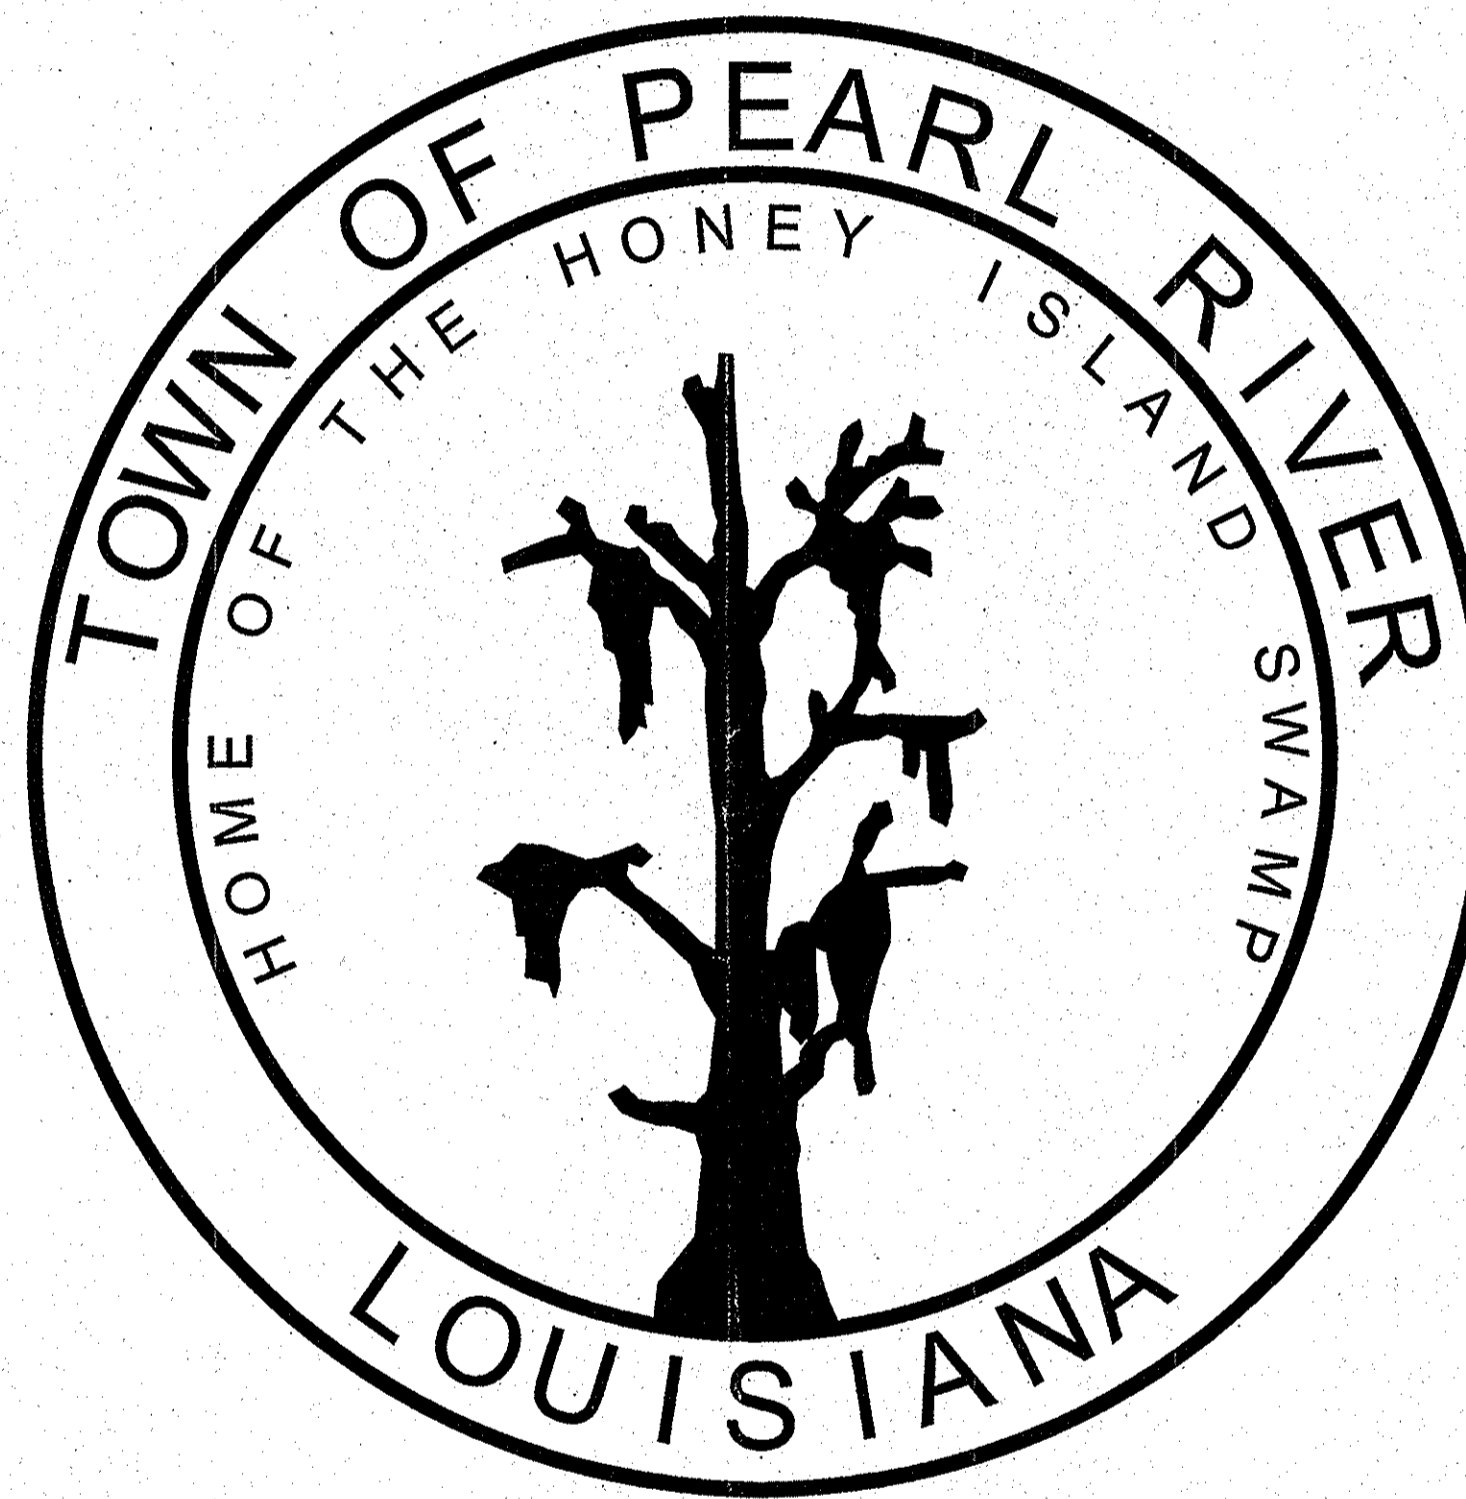

JAMES LAVIGNE
Mayor

DAVID McQUEEN
Mayor Pro Tempora

MARIE CROWE
RUBY GAULEY
KATHRYN WALSH
ELLA BRAKEFIELD
Aldermen

EES PROJECT NO. 1120
MARCH 2012

PREPARED BY:
Environmental Engineering Services, Inc.
CONSULTING ENGINEERS

610 Belle Terre Blvd.
LaPlace, Louisiana 70068

Phone: (985) 653-0185
FAX: (985) 653-0182

APPROVED BY:
ENVIRONMENTAL ENGINEERING SERVICES, INC.

Oscar Boudreaux, Jr.
OSCAR BOUDREAU, Jr., P.E.
LIC. NO. 18859

