


FIRST FLOOR PLAN - BLDG. 2 - LIGHTING
SCALE: 1/8" = 1'-0"



- KEYED PLAN NOTES:**
- ① LOW VOLTAGE OVERRIDE, 3-WAY SWITCH TO TURN ON LIGHTS FOR MAXIMUM OF 2 HOURS.
 - ② SEE DRAWING E1.2 FOR CIRCUITING OF BLDG MOUNTED LIGHTS TYP.

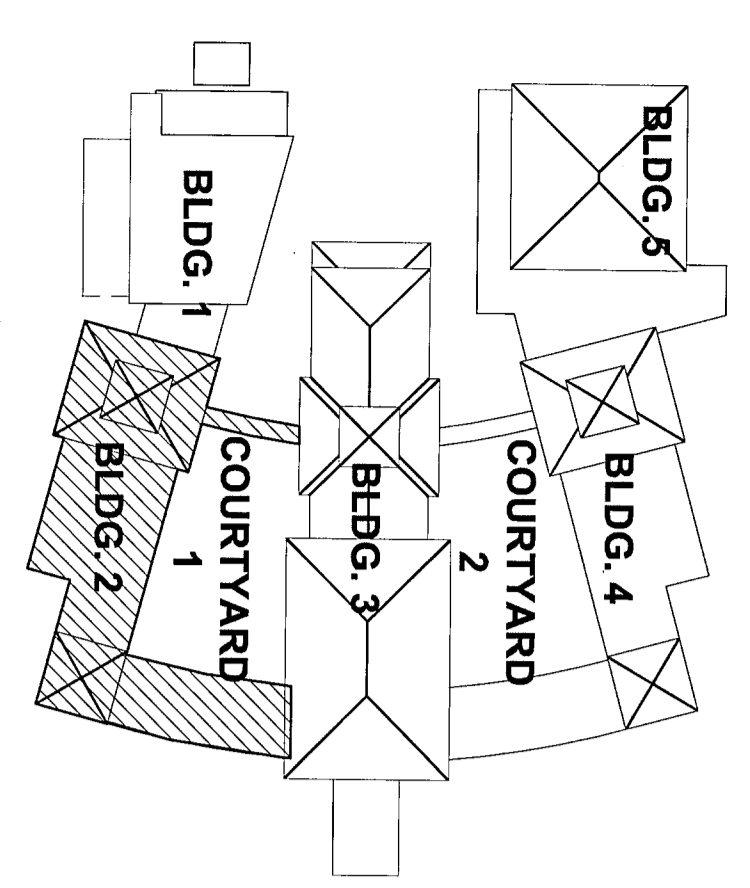

KEY PLAN
N.T.S.

SSE KINGSTOWN
SSE Engineering, Inc.
3000 West Esplanade Ave., Suite 302
Metairie, LA 70002
Phone: (504) 835-8013
www.sse.com

PROJECT TITLE	ST. BERNARD PARISH SCHOOL BOARD - BLDG. 2
PROJECT NO.	2008 B
CLIENT	ST. BERNARD PARISH SCHOOL BOARD
DATE	04/10/2008
DESIGNER	SSE KINGSTOWN
DRAWN BY	...
CHECKED BY	...
DATE	...
PROJECT NO.	...

**ST. BERNARD PARISH SCHOOL BOARD
CHALMETTE ELEMENTARY SCHOOL**
75 WEST CHALMETTE CIRCLE
CHALMETTE, LOUISIANA

REVISION		
No.	DATE	DESCRIPTION
01	04/10/2008	BID/PENNY SUBMISSION

LACHIN OUBRE & Associates
ARCHITECTS PLANNERS
PROJECT MANAGERS
A PROFESSIONAL CORPORATION
3000 West Esplanade Ave., Suite 302, Metairie, La. 70002
Ph: 504-835-8013 Fax: 504-835-8034

E1.4

DATE PLOTTED: 04/10/2008 11:58:01 AM