



FIRST FLOOR PLAN - BLDG. 1 - LIGHTING
SCALE: 1/8" = 1'-0"

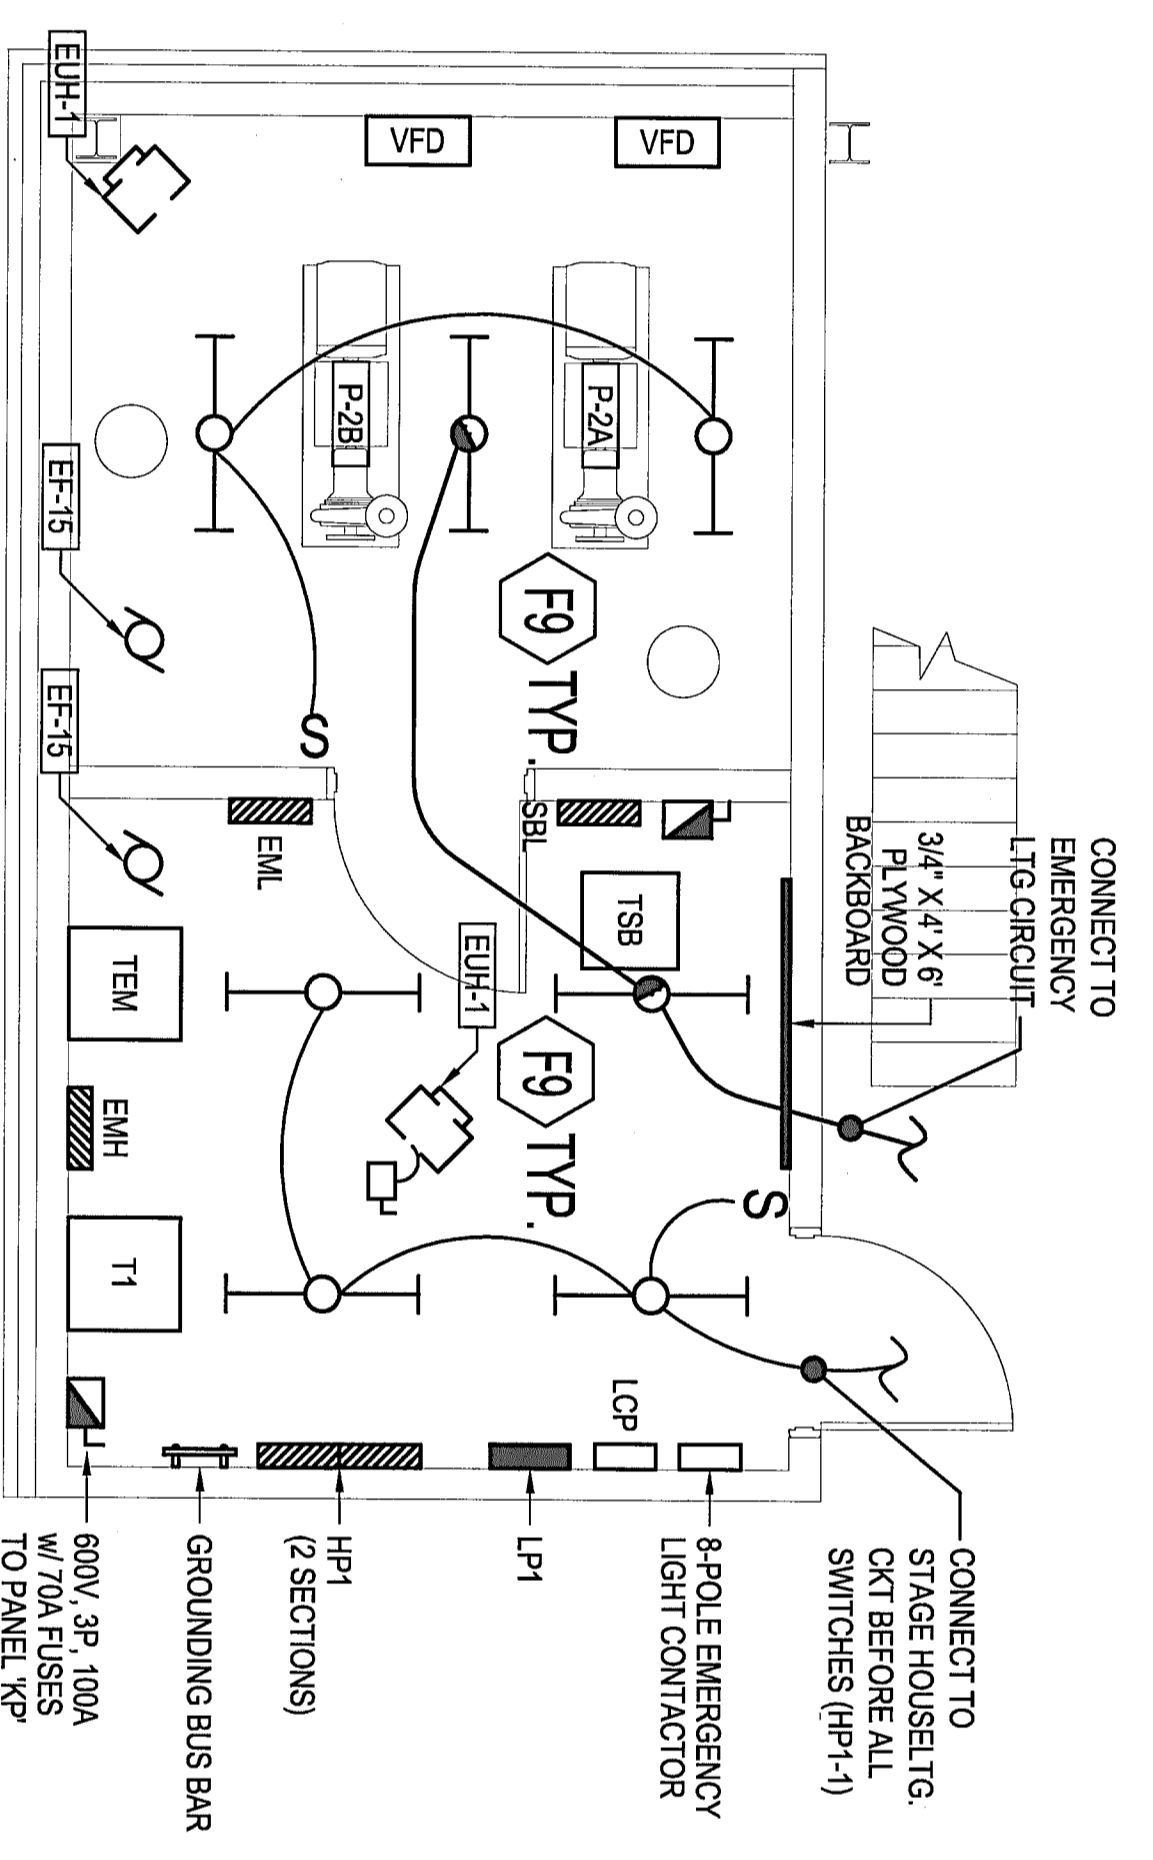

PARTIAL PLAN - MAIN ELECTRICAL ROOM @ MEZZANINE LEVEL
SCALE: 1/4" = 1'-0"


KEYED PLAN NOTES:

- 1 THEATRICAL LTR. POWER DISTRIBUTION SYSTEM WITH PIPE, COND. GUAD CONNECTOR TO PROVIDE ALL STEMS, PIPES, FLUES, WIREWAY CONNECTORS, MOUNTING ACCESSORIES, ETC. 1 1/2" PIPE AT 12'-0" AFF. PLUG SYSTEM STRAND LIGHTING OR EQUAL. SEE DETAIL THIS DWG.
- 2 2-BUTTON, 3-WAY LOW VOLTAGE SWITCH - 1-BUTTON TO CONTROL INNER LAMP BALLASTS, AND 2ND BUTTON TO CONTROL OUTER LAMP BALLASTS, ROUGH-IN.
- 3 VERIFY LOCATION OF THE DIMMER SWITCHES WITH THE OWNER PRIOR TO ROUGH-IN.
- 4 2-BUTTON, 3-WAY LOW VOLTAGE SWITCH.
- 5 SEE DRAWING E12 FOR CIRCUITING OF BLDG MOUNTED LIGHTS TYP.

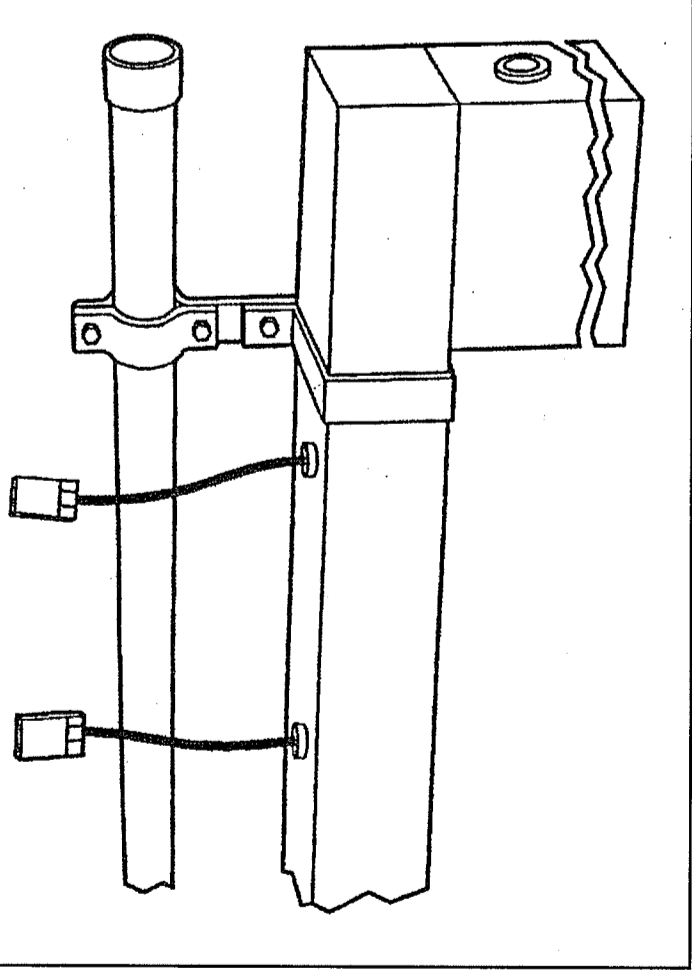

STRAND LIGHTING DETAIL
NOT TO SCALE

Connector Strip
Heavy gauge steel wire-ways with removable cover for wiring access and brackets for attaching 1 1/2" pipes and for suspending from rigging and suspension hardware. Connector strips are made to order with 18" cable pig-tails at specified centers (flush receptacles can also be specified) and with end terminal compartment (L or R end). Connector strip can be supplied with or without brackets for the alter, symmetrical brackets for TV or brackets for wall mounting.

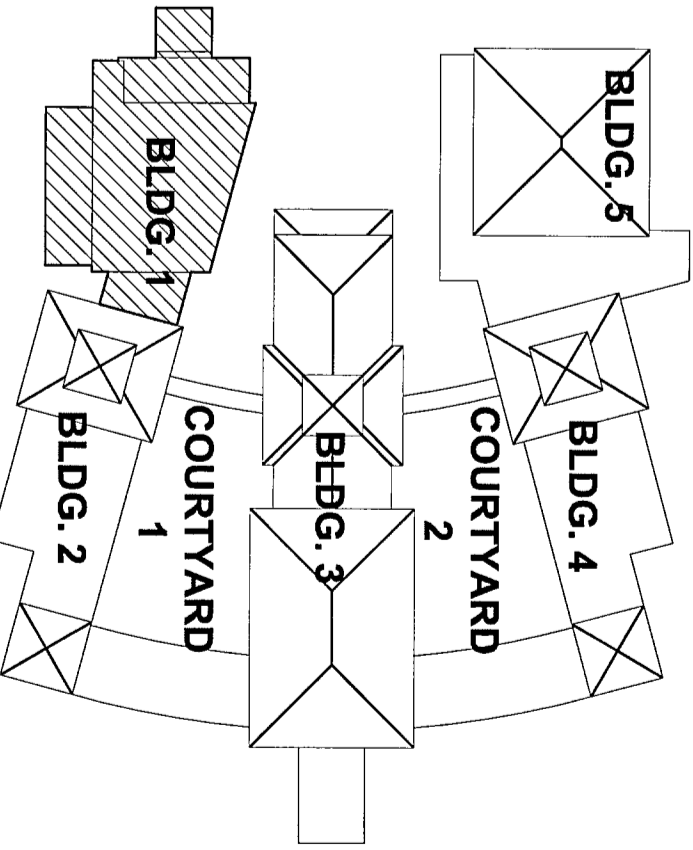

KEY PLAN
N.T.S.

REVISION		
No.	DATE	DESCRIPTION
1	04/10/2009	RED/PENNY SUBMISSION

LACHIN & OUBRE' & Associates
ARCHITECTS PLANNERS
PROJECT MANAGERS
A PROFESSIONAL CORPORATION
3000 West Esplanade Ave., Suite 302, Metairie, La. 70002
Ph: 504-835-8013 Fax: 504-835-8034

**ST. BERNARD PARISH SCHOOL BOARD
CHALMETTE ELEMENTARY SCHOOL**
75 WEST CHALMETTE CIRCLE
CHALMETTE, LOUISIANA

E1.6
1ST FLOOR - BLDG. 1
- LIGHTING
PROJECT NO. 2008-8
DRAWN BY: [Name]
DATE: 04/10/09
SHEET NO. 11 OF 11
SHEET

SNE KINGDOM
1572 Riverchase Lane
Suite 200
14007 Riverchase Blvd
Houston, TX 77040
Phone: (713) 578-0100
Fax: (713) 578-0100
www.sne.com