




PLUMBING PLAN UNIT 1A
SCALE: 1/4" = 1'-0"

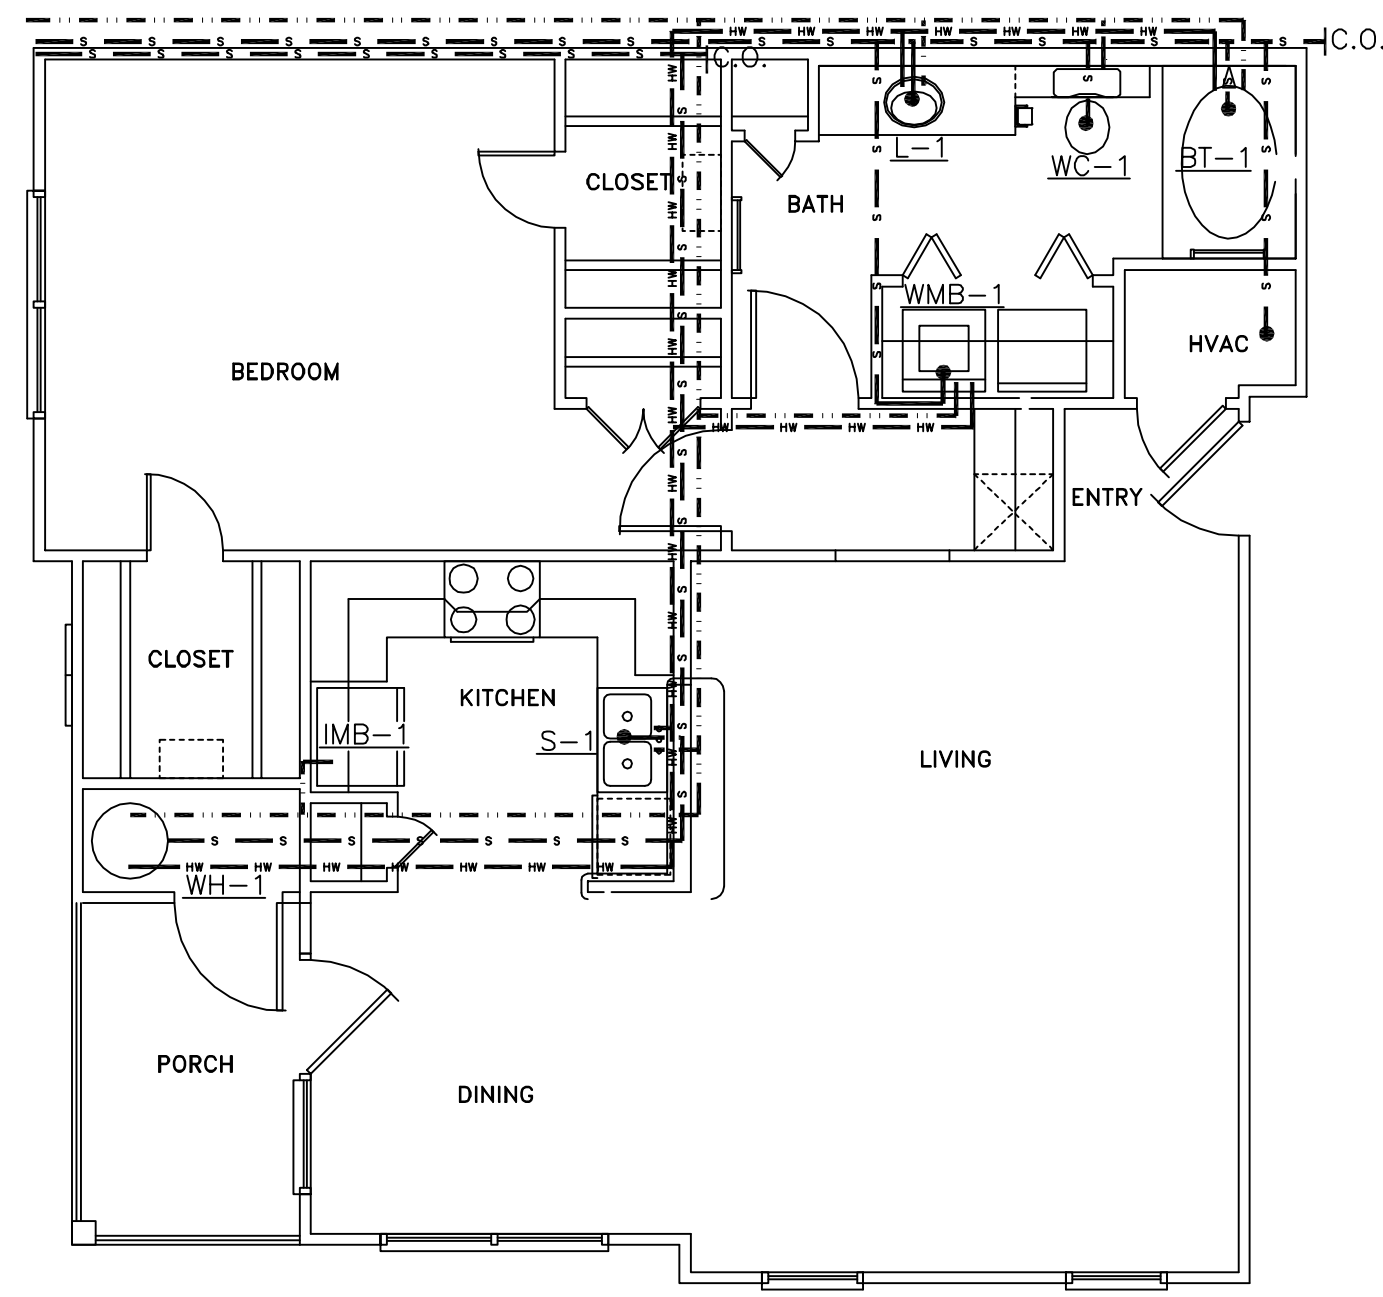


PLUMBING PLAN UNIT 1B
SCALE: 1/4" = 1'-0"

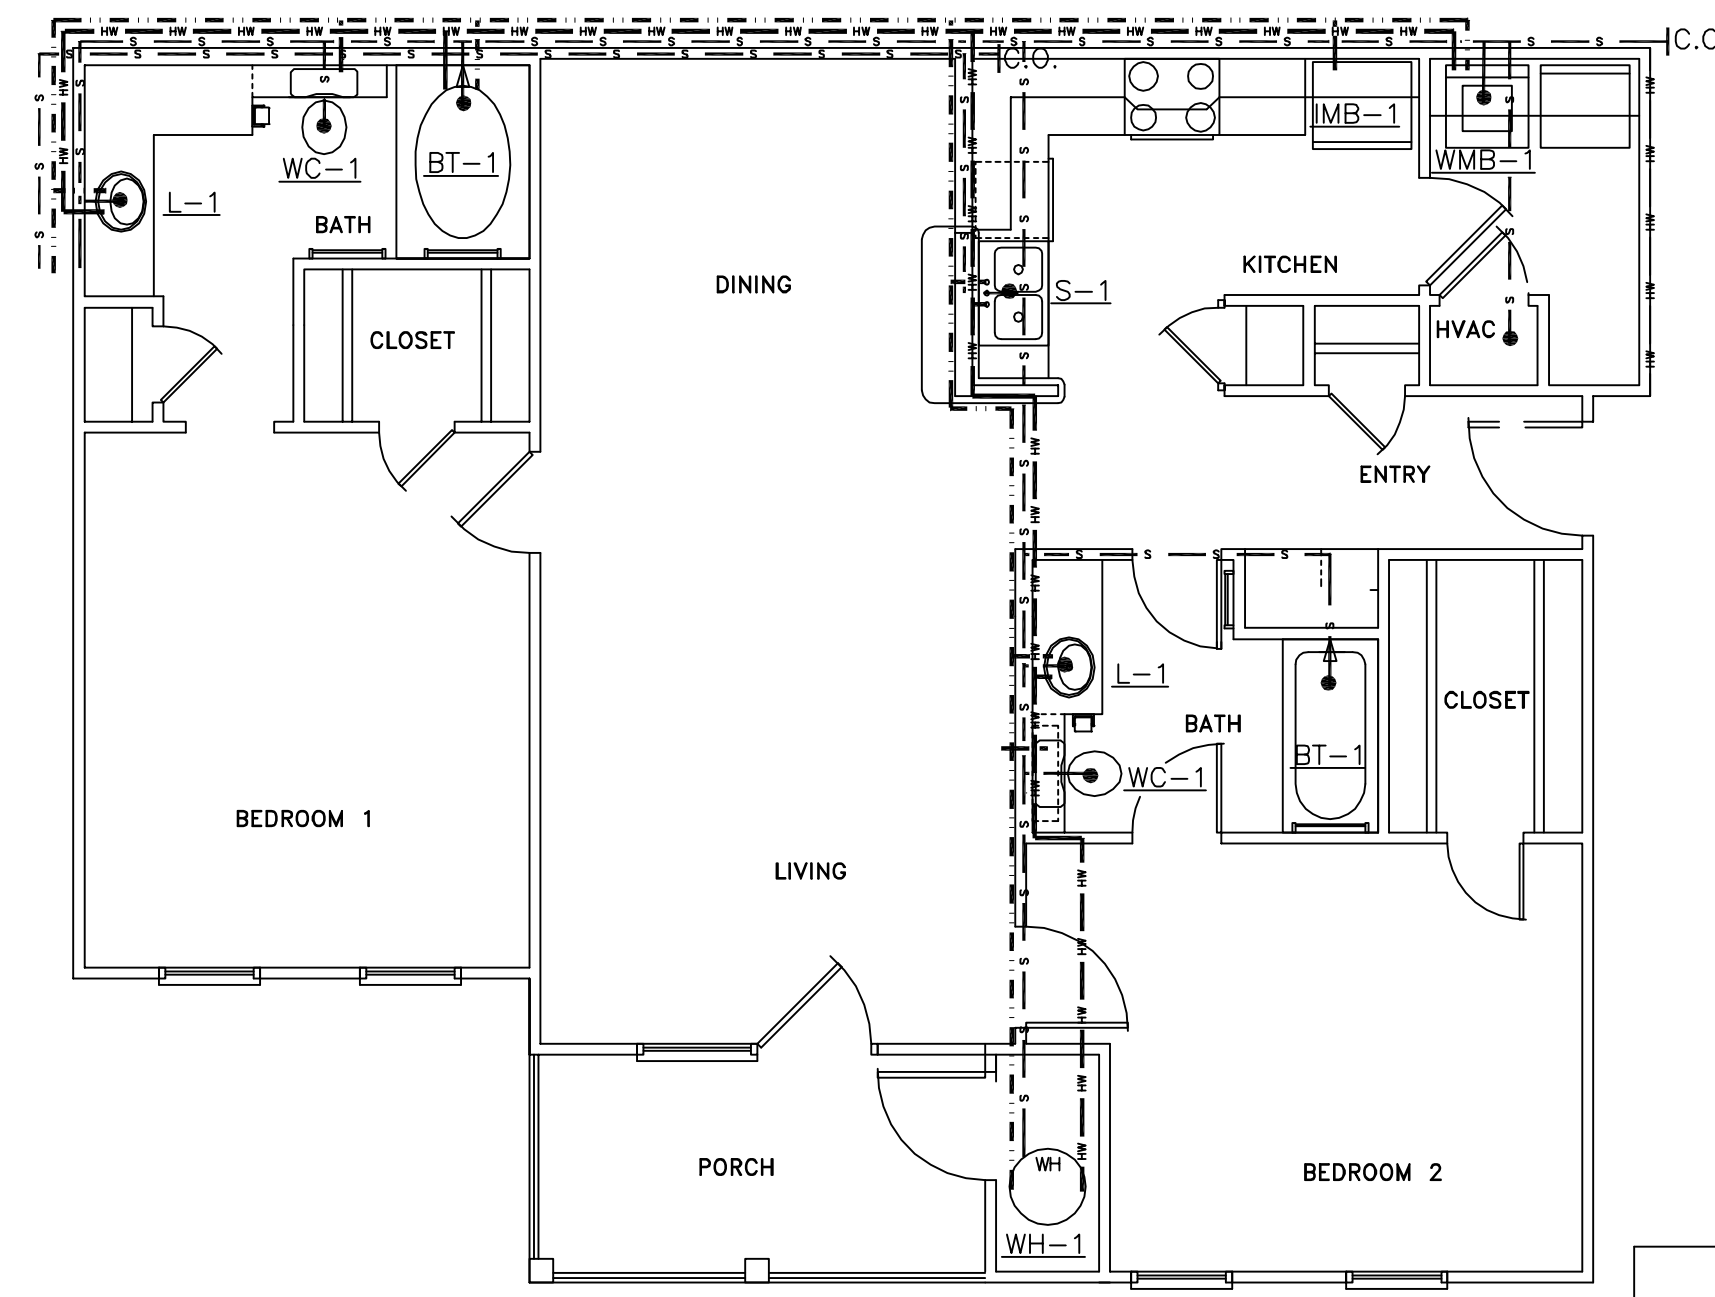


PLUMBING PLAN UNIT 2A
SCALE: 1/4" = 1'-0"

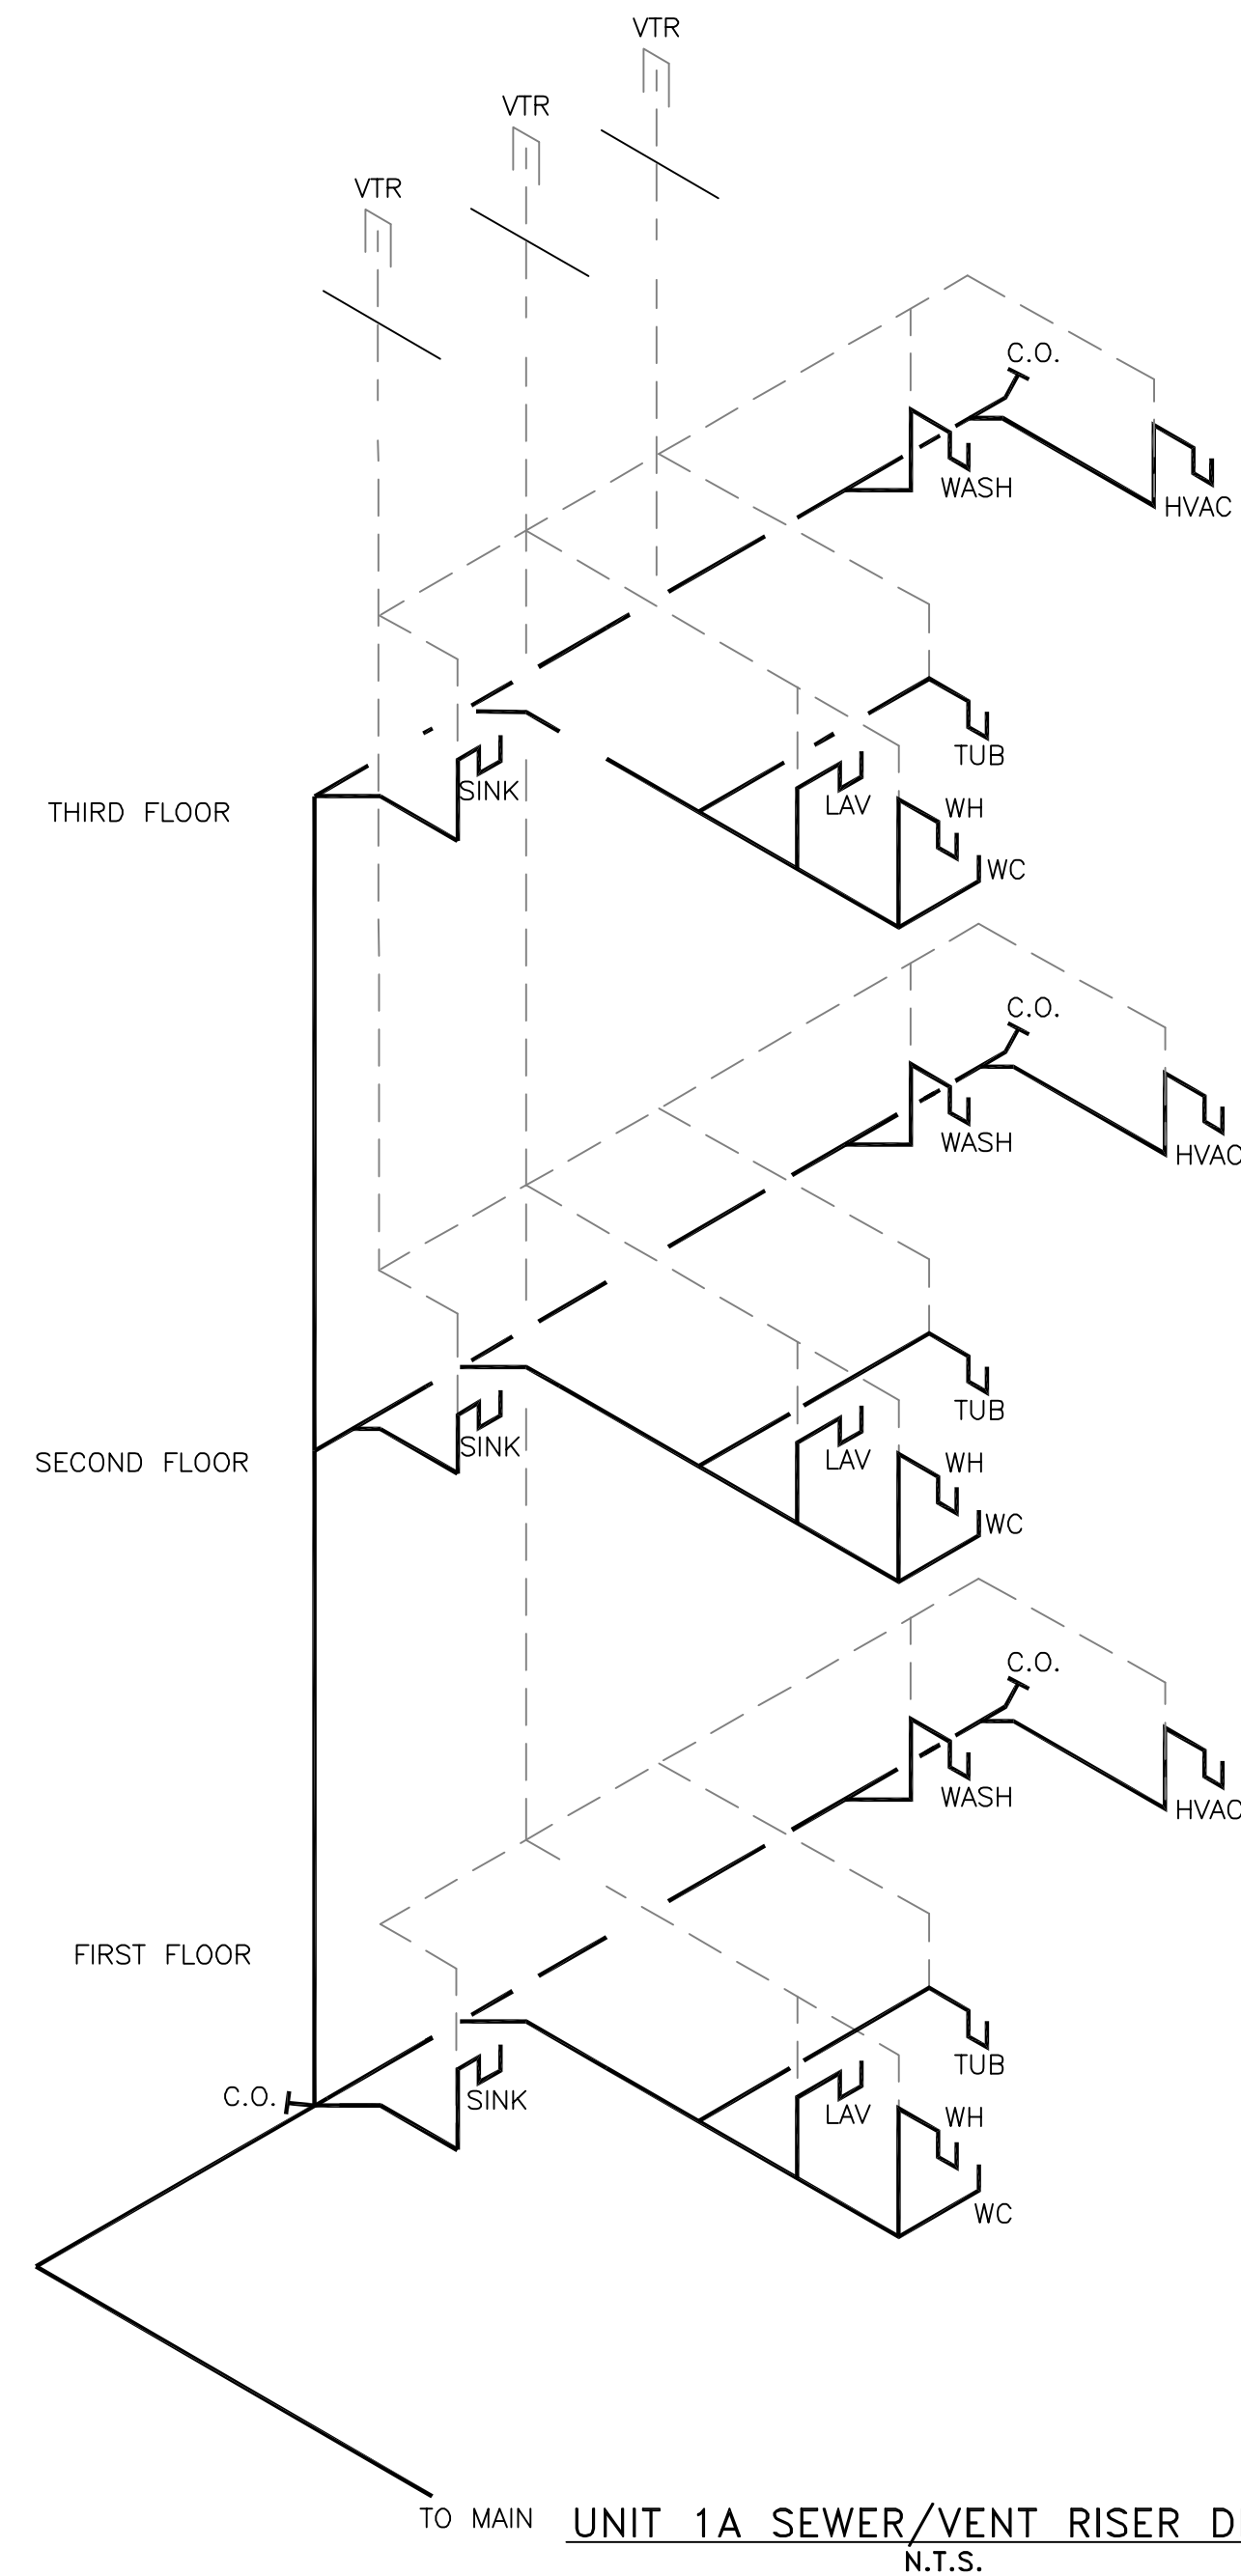

UNIT 1A SEWER/VENT RISER DIAGRAM
N.T.S.

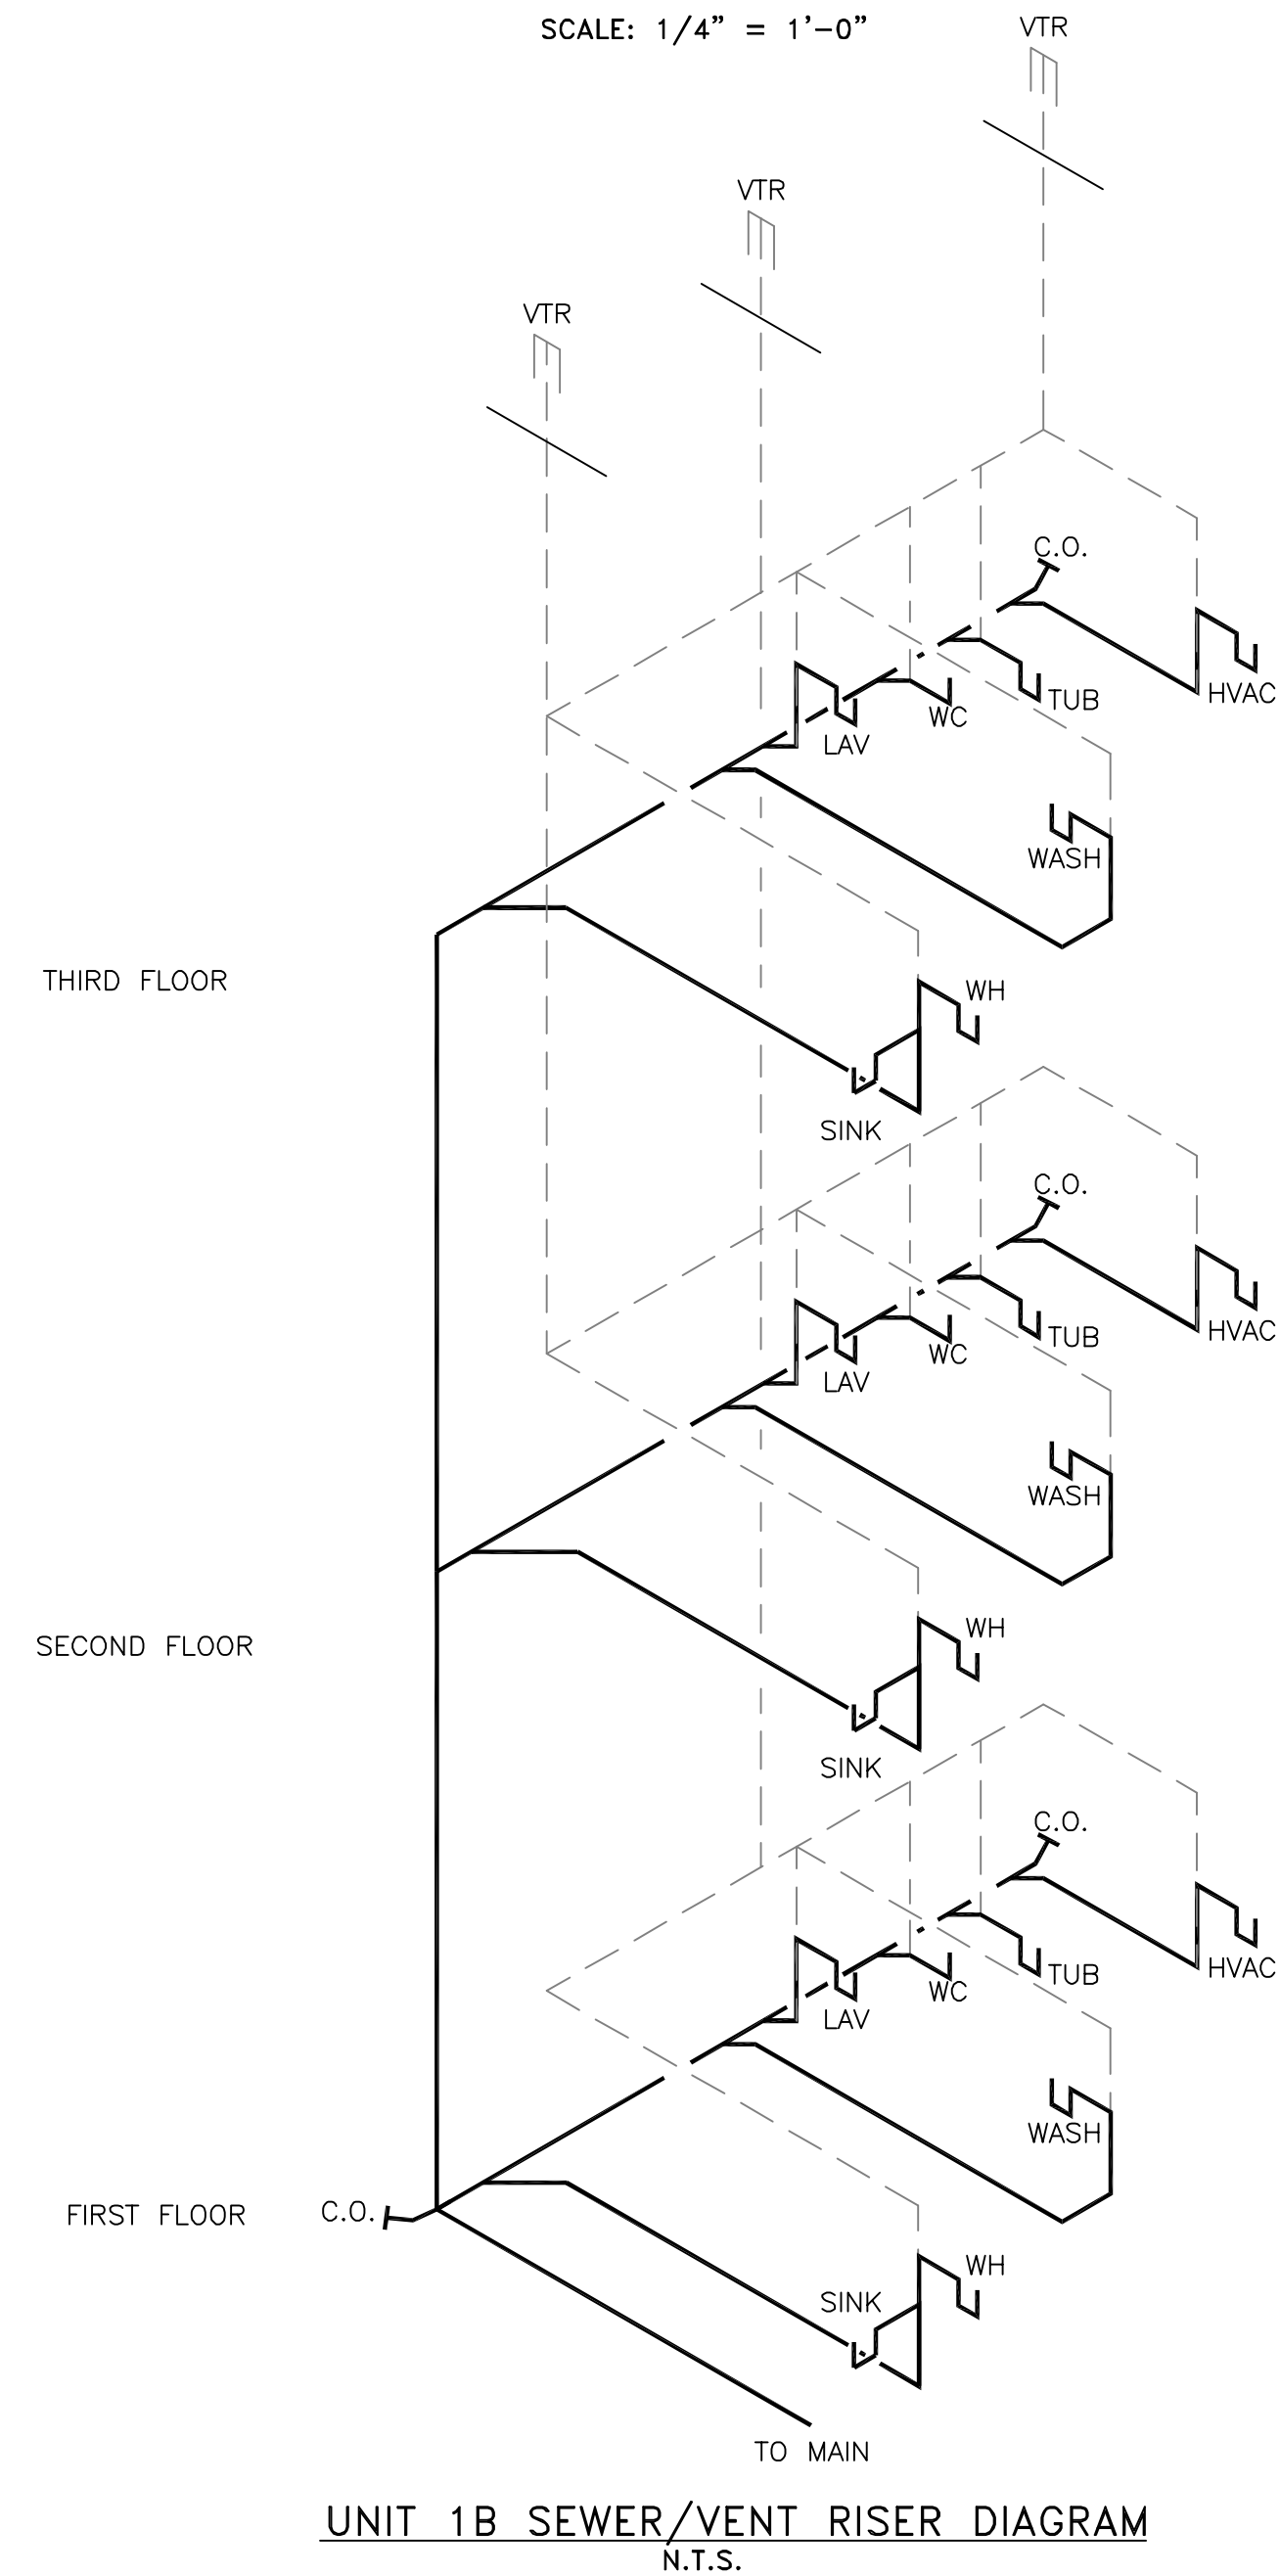

UNIT 1B SEWER/VENT RISER DIAGRAM
N.T.S.

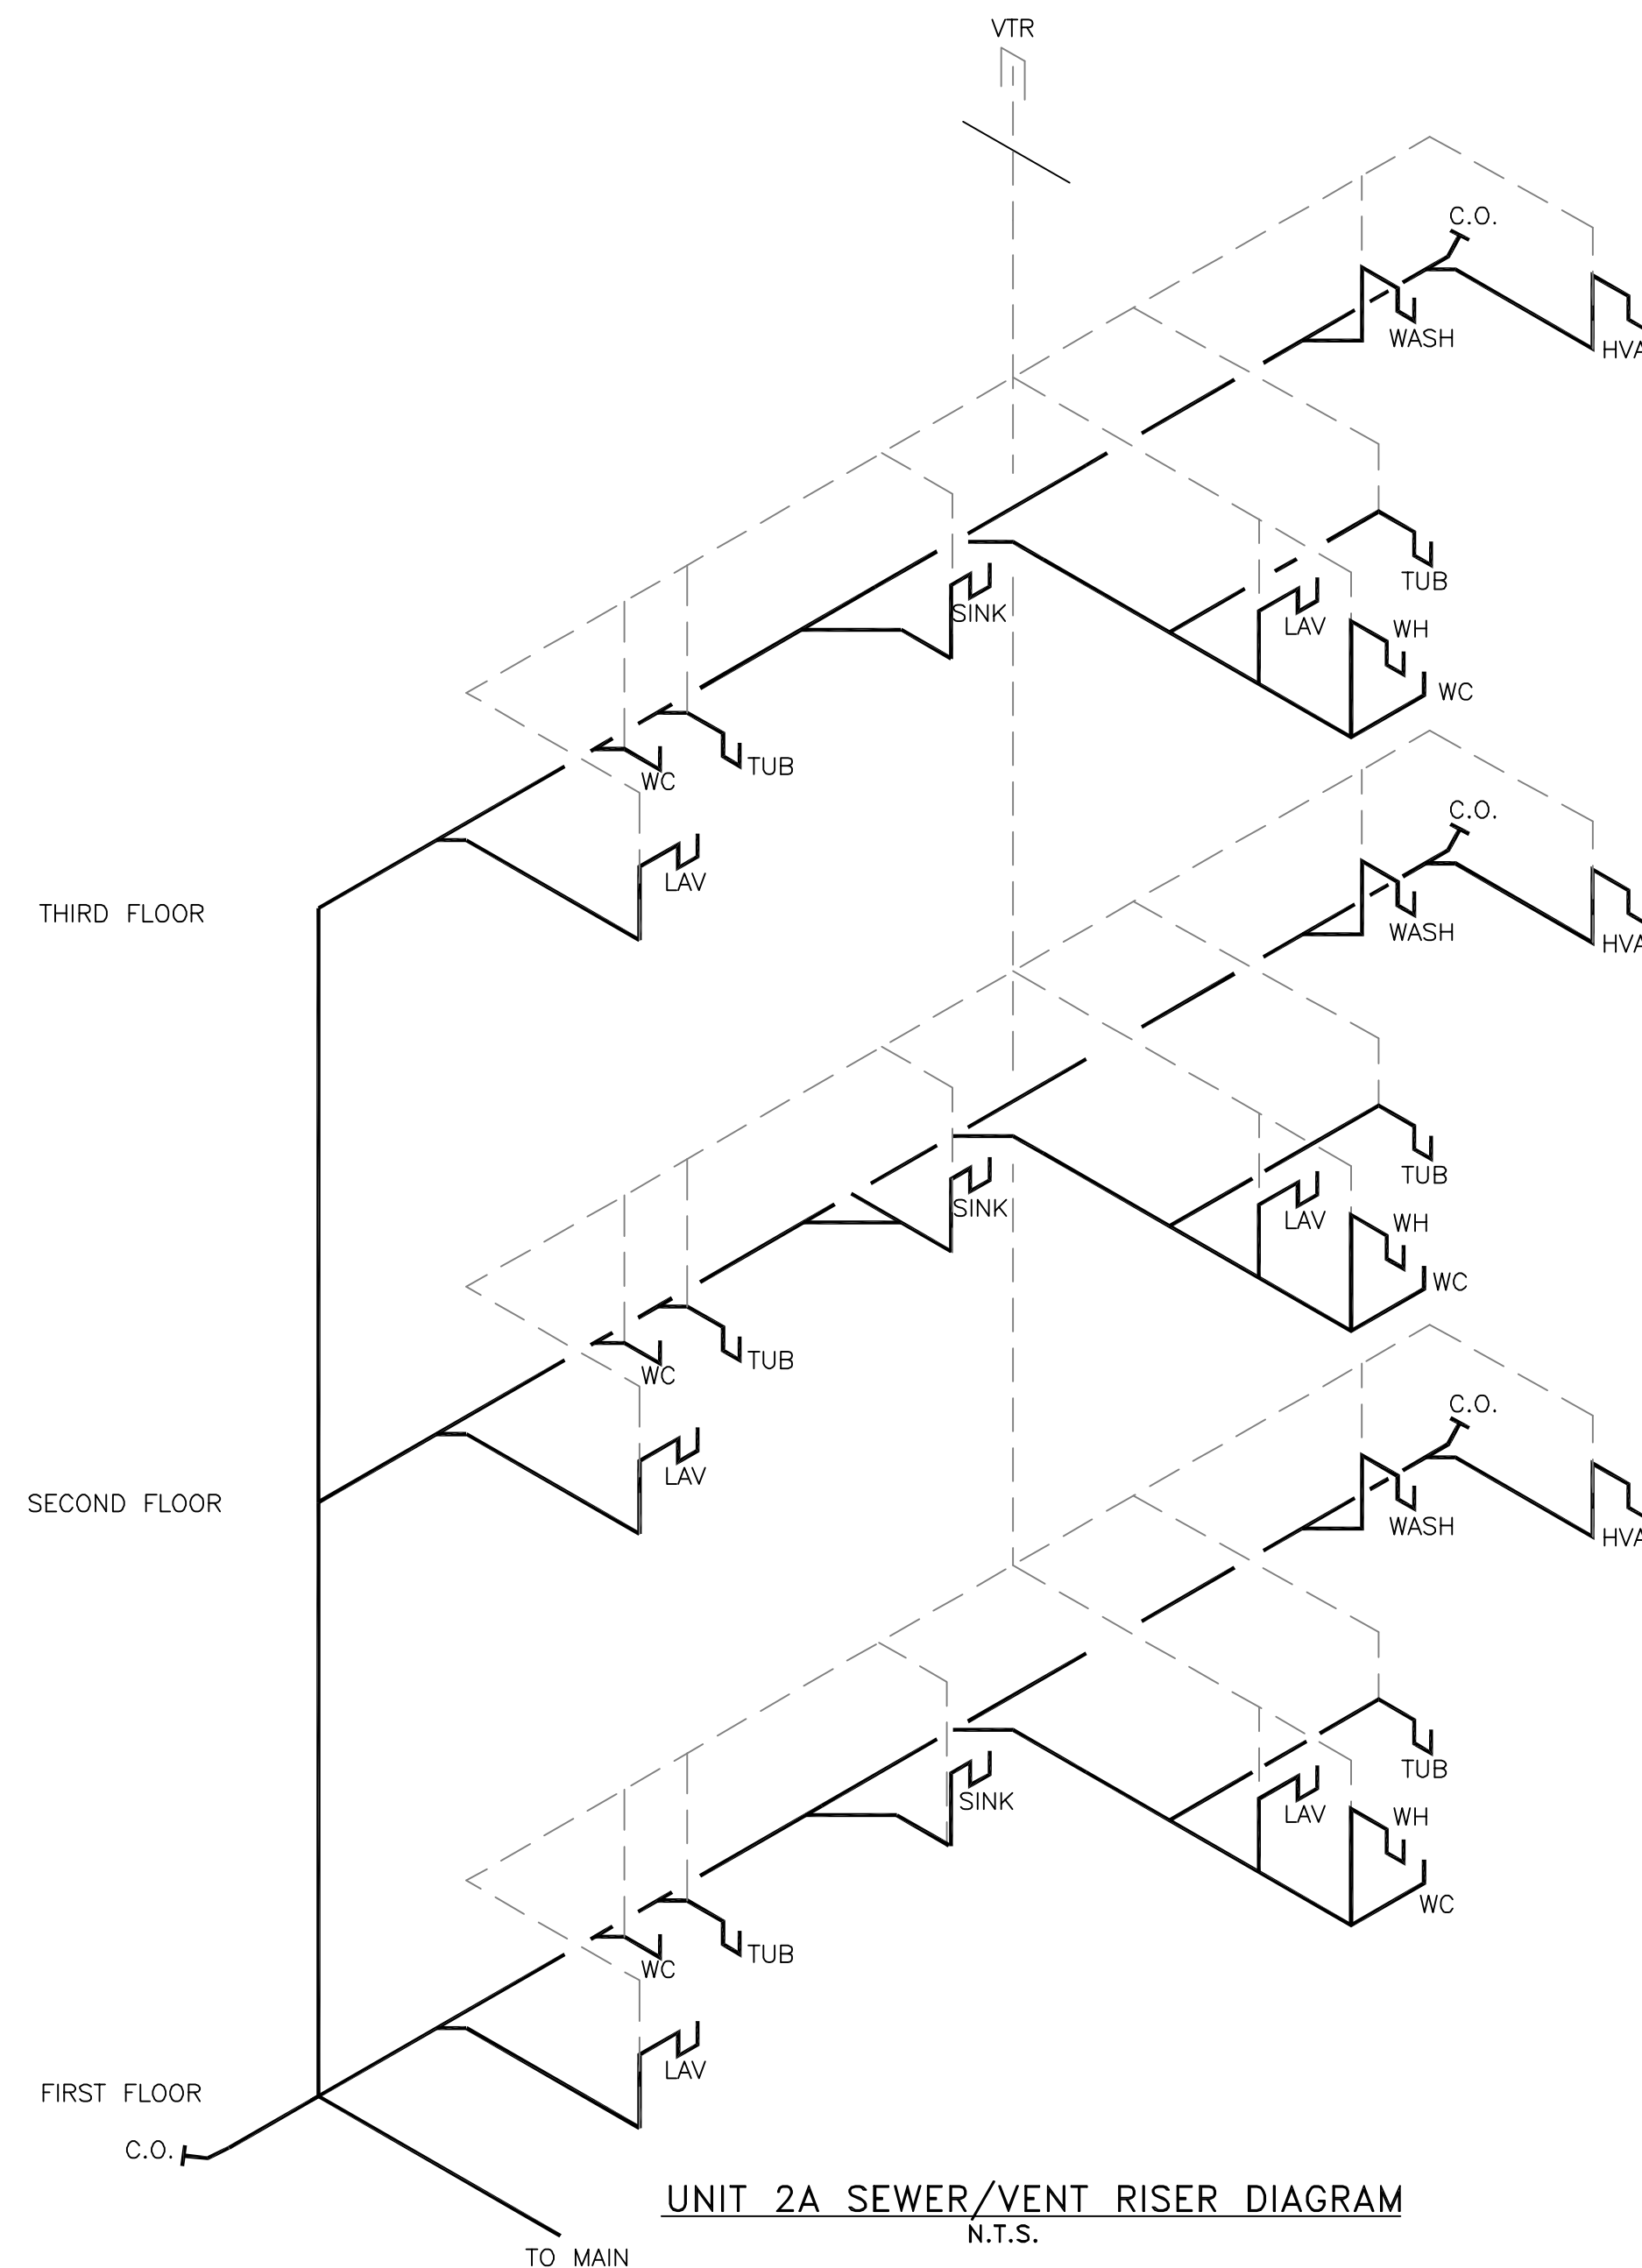

UNIT 2A SEWER/VENT RISER DIAGRAM
N.T.S.

MARK	DESCRIPTION	ROUGH-IN-SIZES			REMARKS
		CW	H.W.	WASTE VENT	
WC-1	WATER CLOSET, FLR. MTD.	1/2"	4"	4"	
L-1	COUNTER MOUNTED LAVATORY	1/2"	1/2"	2"	
BT-1	TUB / SHOWER/SURROUND	1/2"	1/2"	2"	W/ PRESSURE BALANCING VALVE.
S-1	KITCHEN SINK - 2 COMPARTMENT	1/2"	1/2"	2"	PROVIDE PIPING TO DISHWASHER.
WMB-1	WASHING MACHINE BOX	1/2"	1/2"	2"	
IMB-1	ICE MAKER BOX	1/2"	-	-	
WH-1	40 GAL WATER HEATER	-	-	-	
VTR	VENT TO ROOF	-	-	4"	

LEGEND

- HOT WATER
- - - POTABLE WATER
- · - · - SANITARY SEWER
- - - PLUMBING VENT

THE BRYAN COMPANY
ISLAND PARK
APARTMENT COMMUNITY
SHREVEPORT, LA.

ISLAND PARK
DAMMON ENGINEERING, INC.
ARCHITECTS - ENGINEERS
819 ROBERT ROAD
SLIDELL, LA. 70458

SCALE: AS NOTED

FILE: -

JOB No.: -

DATE: 03-29-04

SHEET

P-8

OF -