


**2nd FLOOR ELECTRICAL PLAN**  
 SCALE: 3/16" = 1'-0"

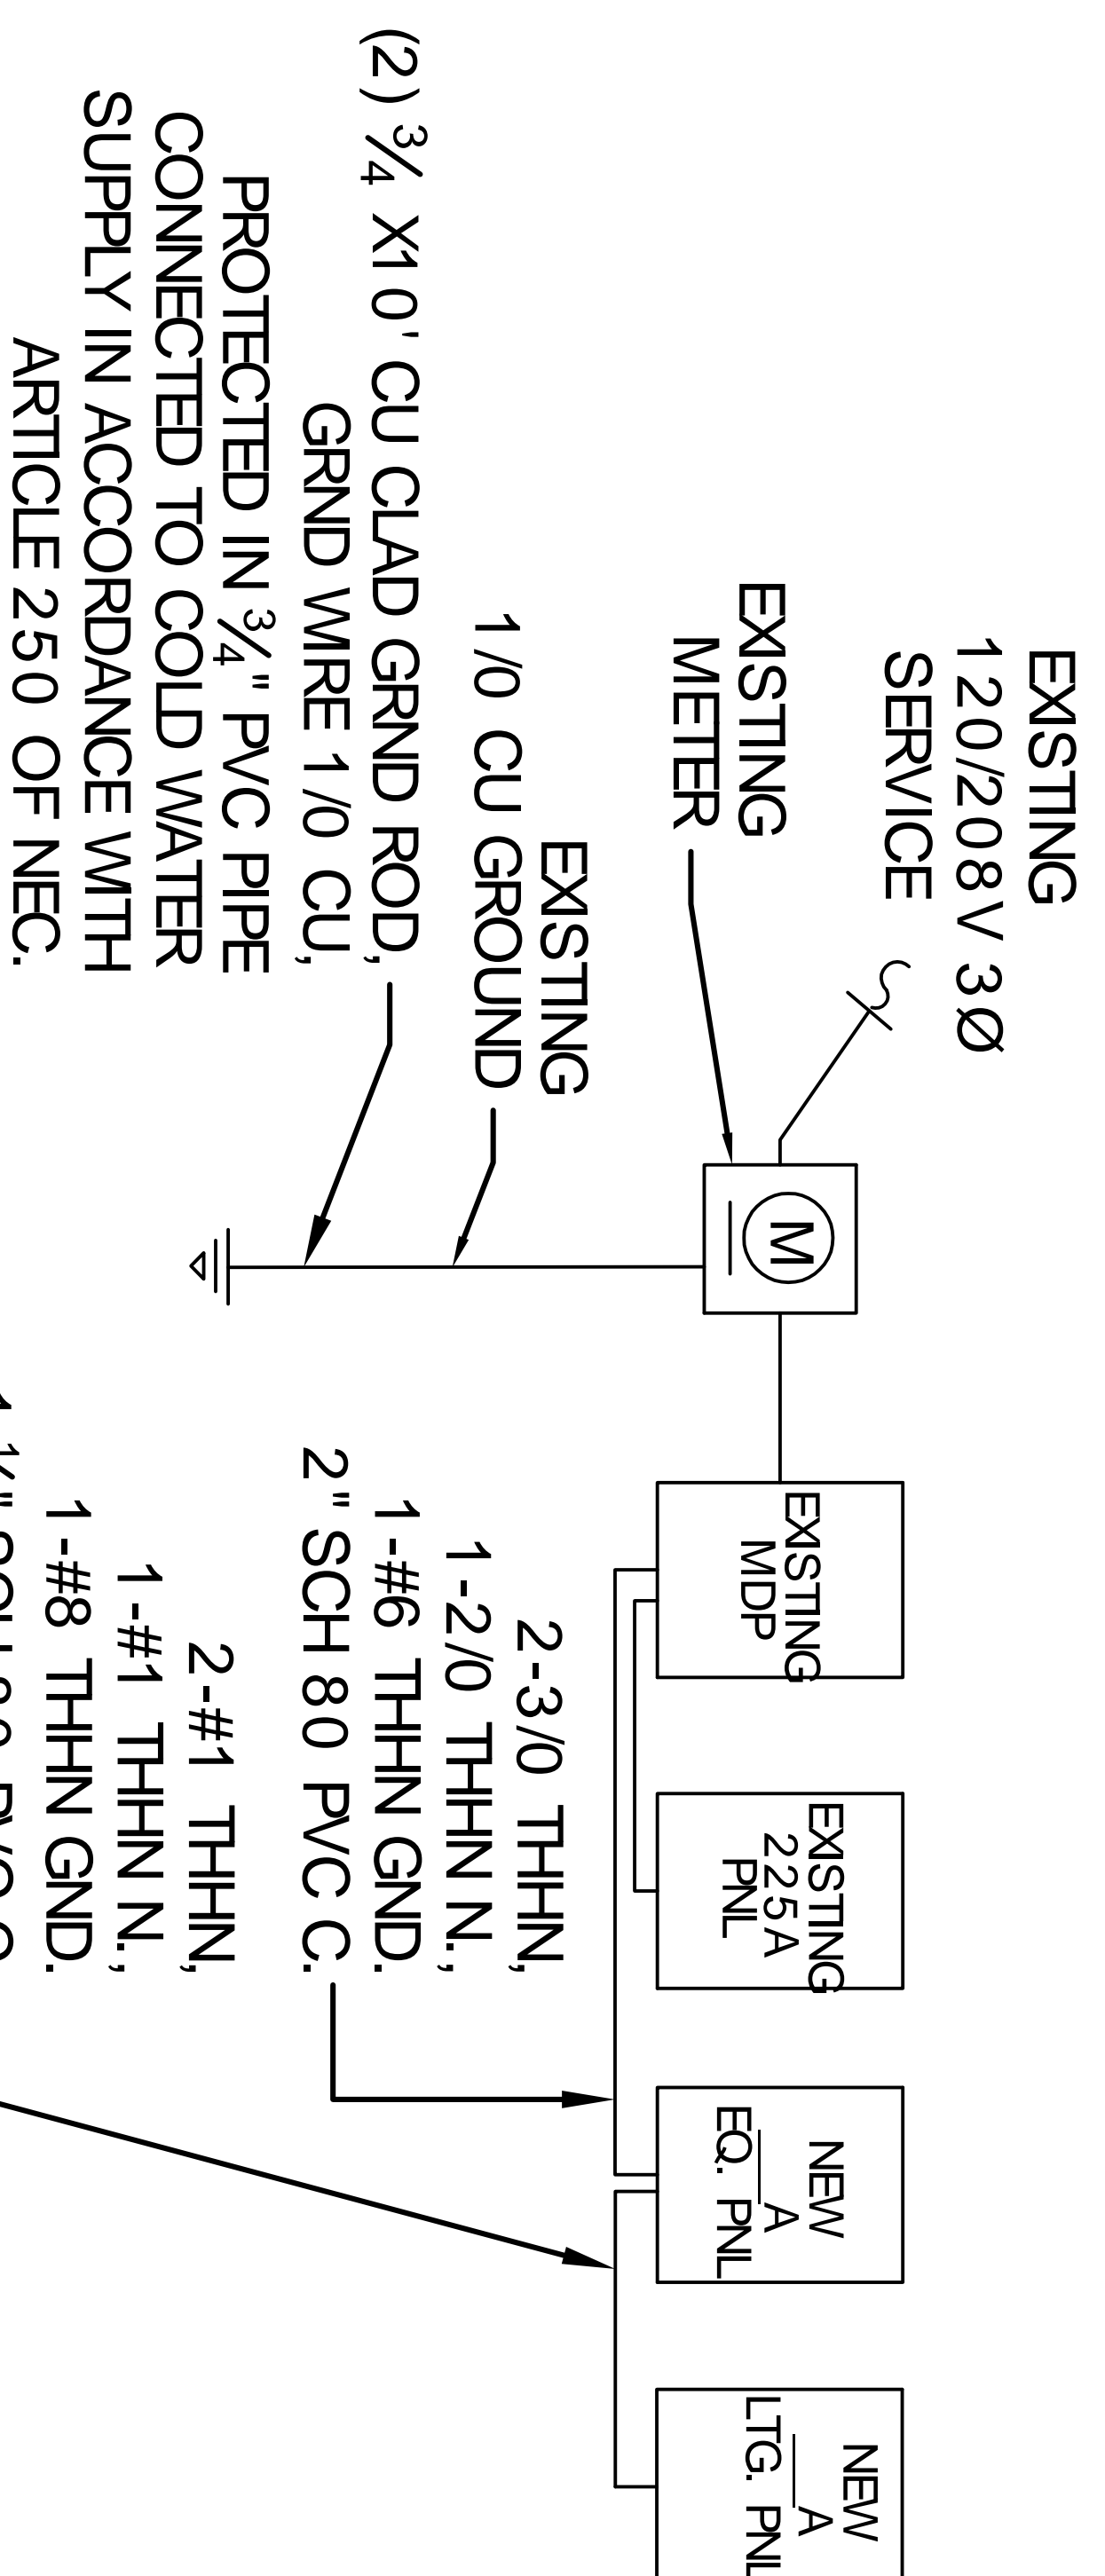

**ONE LINE DIAGRAM**  
 N.T.S.