


LEVEL 2 RCP
SCALE: 3/16"=1'-0"

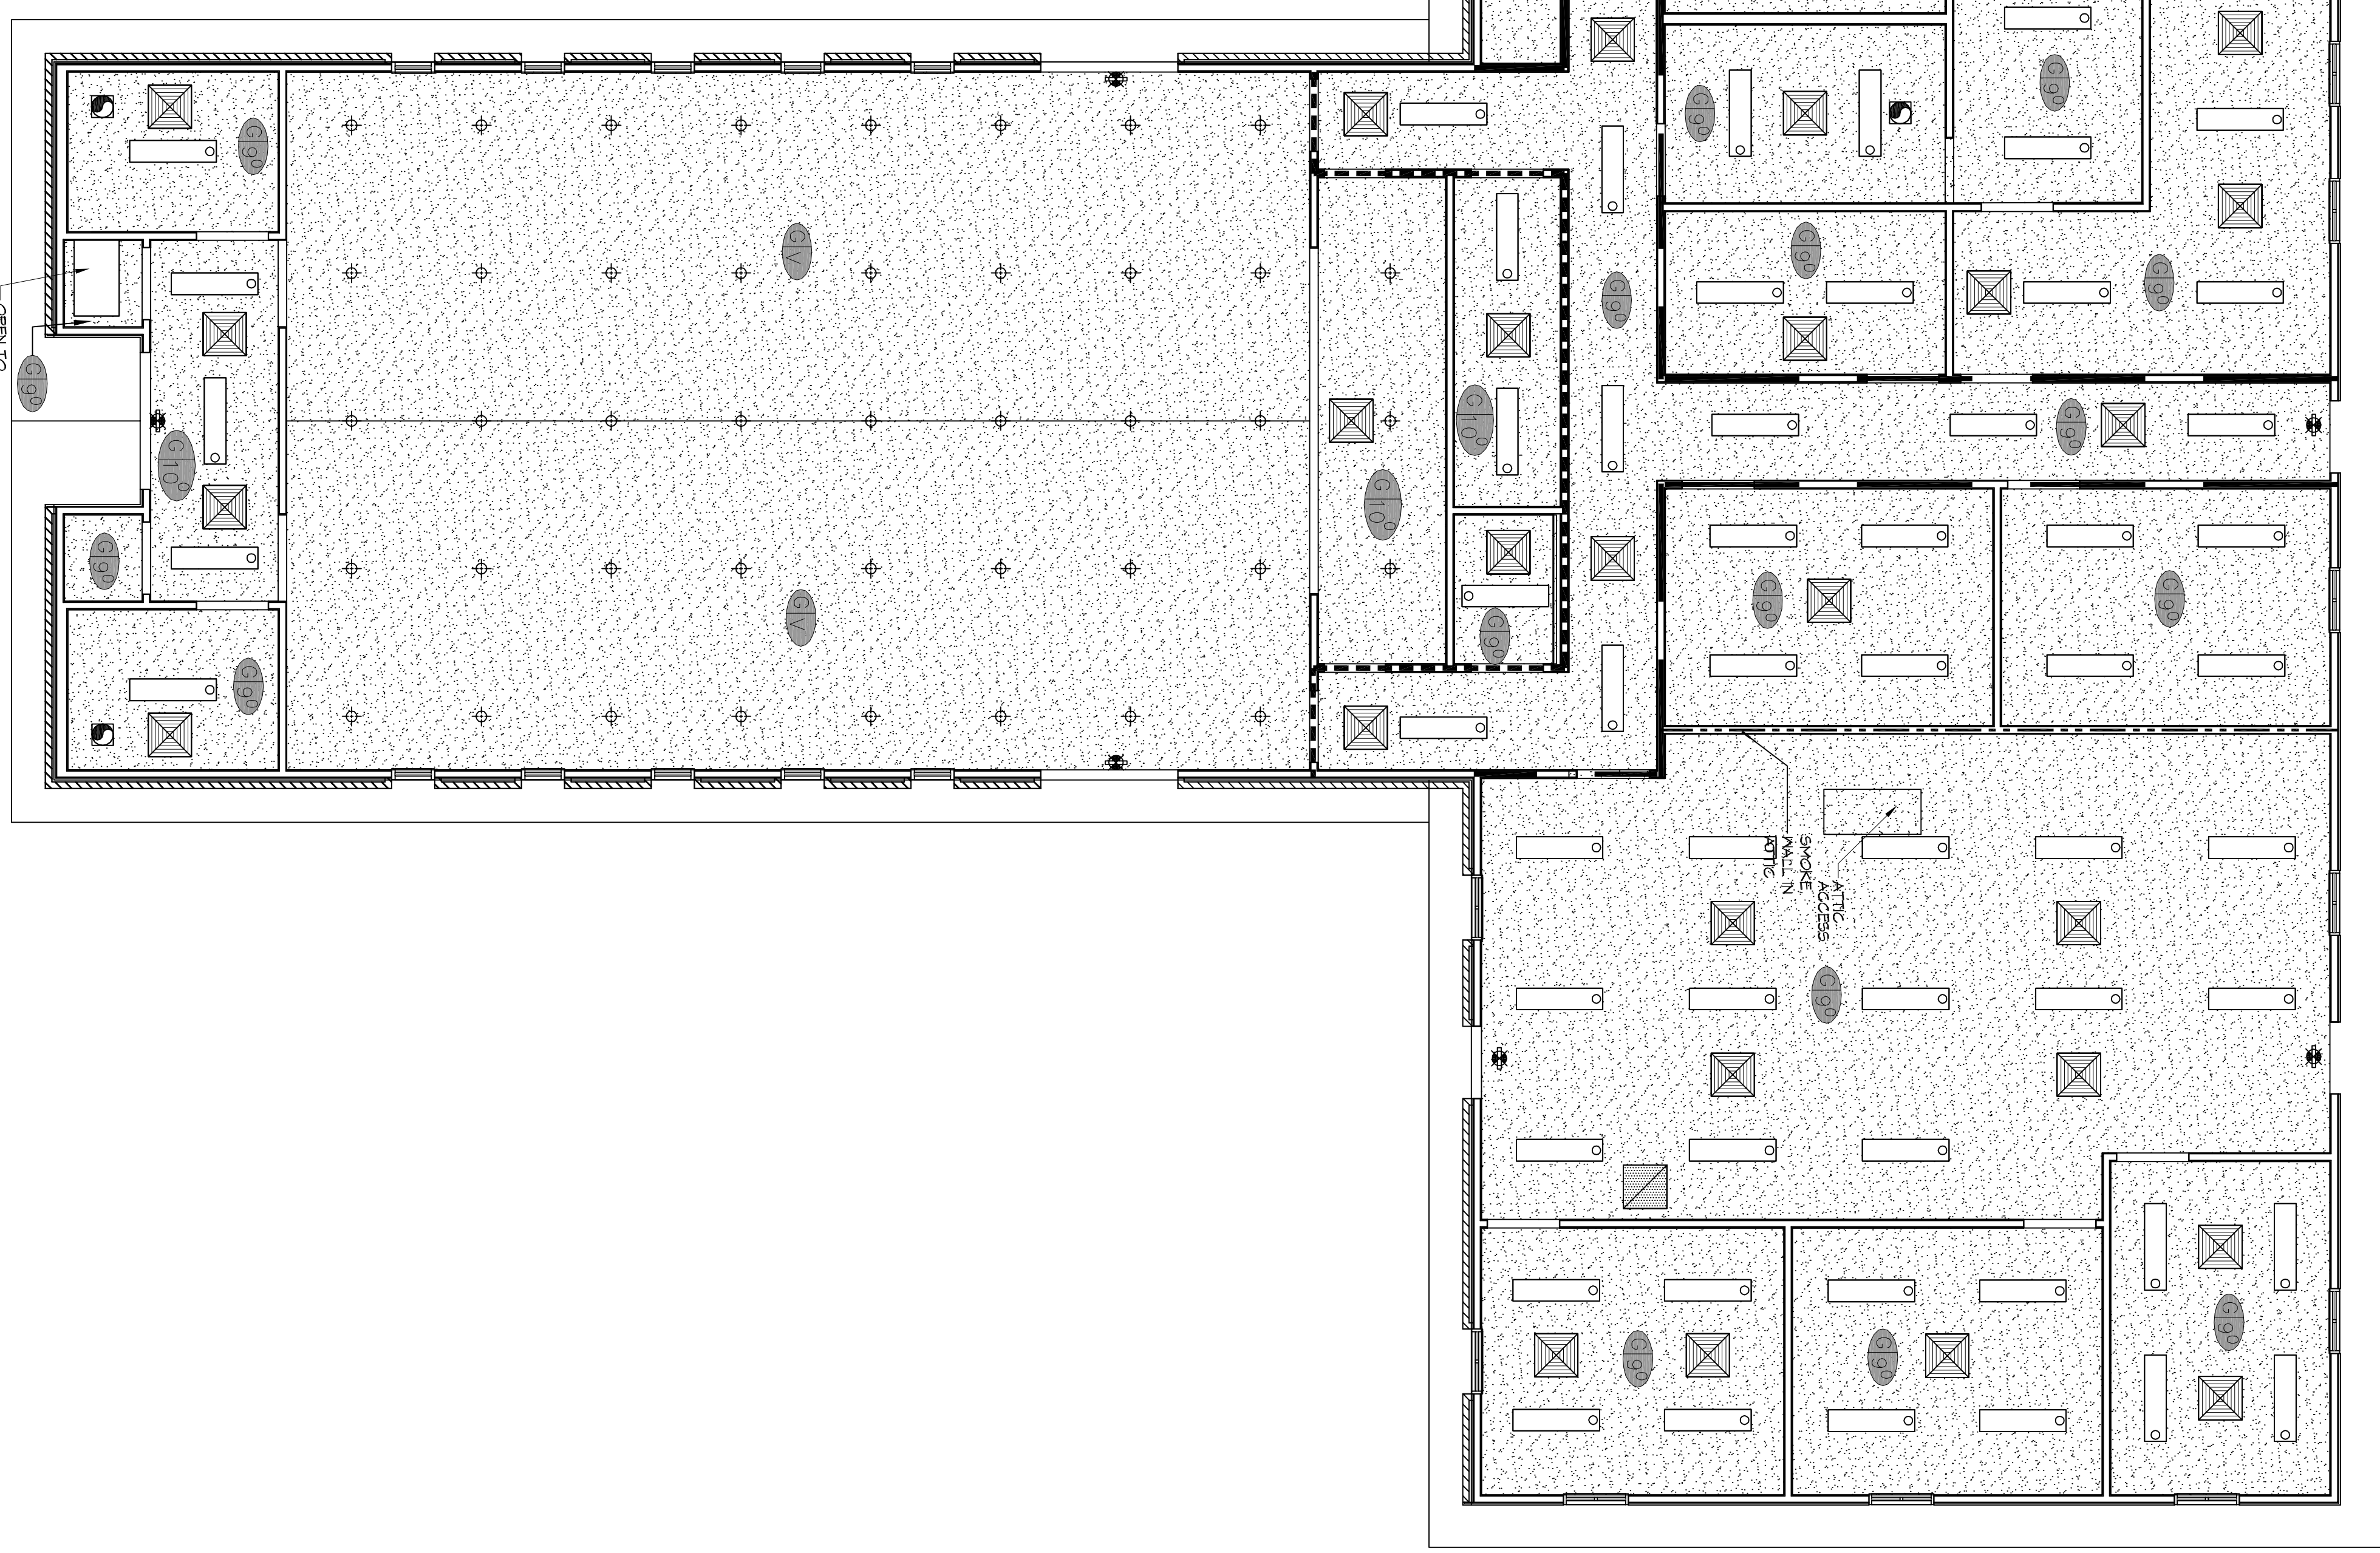

LEVEL 1 REFLECTED CEILING PLAN
SCALE: 3/16"=1'-0"

GENERAL NOTES

1. MECHANICAL MEZZANINE REFLECTED CEILING PLAN NOT SHOWN. NO MECHANICAL CEILING ASSEMBLY OR DEVICES AND IS OPEN TYPES AND EXPOSED INDOORS. SEE SHEET E101 FOR LIGHT FIXTURE TYPES AND LOCATIONS.
2. ALL CEILING HEIGHTS INDICATED ARE APPROXIMATE. ACTUAL CEILING HEIGHT TO BE DETERMINED BY STRUCTURE ELEVATION AND CEILING ASSEMBLY THICKNESS. INDICATED HEIGHT IS MEASURED ABOVE FINISH FLOOR (AFF).
3. REFER TO SHEET A501 FOR WALL/PARTITION ASSEMBLY AND INFORMATION.
4. SEE SHEET E101 FOR LIGHT FIXTURE TYPES. SEE SHEET M101 FOR DIFFUSER AND GRILLE TYPES.
5. REFER TO INTERIOR ELEVATIONS FOR MOUNTING HEIGHT OF WALL MOUNTED LIGHT FIXTURES.

RCP LEGEND

SYMBOL	DESCRIPTION
	2x4 SURFACE MOUNTED FLUORESCENT LIGHT FIXTURE
	1x4 SUSPENDED HIGH BAY LIGHT FIXTURES
	SURFACE MOUNTED FLUORESCENT LIGHT FIXTURE STRIP
	DIRECTIONAL SPOTLIGHT
	PENDANT LIGHT FIXTURE
	RECESSED LIGHT FIXTURE
	SURFACE MOUNTED LIGHT FIXTURE
	EXHAUST FAN
	HVAC SUPPLY AIR DIFFUSER
	HVAC RETURN AIR GRILL
	GYPSUM BOARD CEILING (GWB)
	CEILING TYPE/HEIGHT (G-GYP BD, V-VARIABLE) SEE FINISH SCHEDULE FOR MORE DETAILS

DAMMON ENGINEERING, INC.
LOUISIANA & MISSISSIPPI

Chief Engineer: Brian Mistich, PE
554 Old Spanish Trail
Slidell, LA 70458

www.dammonengineering.com
info@dammonengineering.com
PH: 985.649.5832 F: 985.641.5950

REVISIONS		DATE
#	DESCRIPTION	



W B A Y O U N C I A L B A P T I S T

1941 SULLIVAN DR.
SLIDELL, LA 70460

JOB No: 2274 DATE: 05/12/2016

DRAWN BY: KHM CHECKED BY: JMS

The above drawings are specific to this project and are not to be used for any other project without the express written consent of Dammon Engineering, Inc. Any reuse or modification of these drawings without the express written consent of Dammon Engineering, Inc. is strictly prohibited.

SHEET TITLE:
REFLECTED CEILING PLAN

DRAWING NUMBER:
A104

10 OF 17