


LEGEND
 □ - 30' LUMINAIRE 1-400W MH

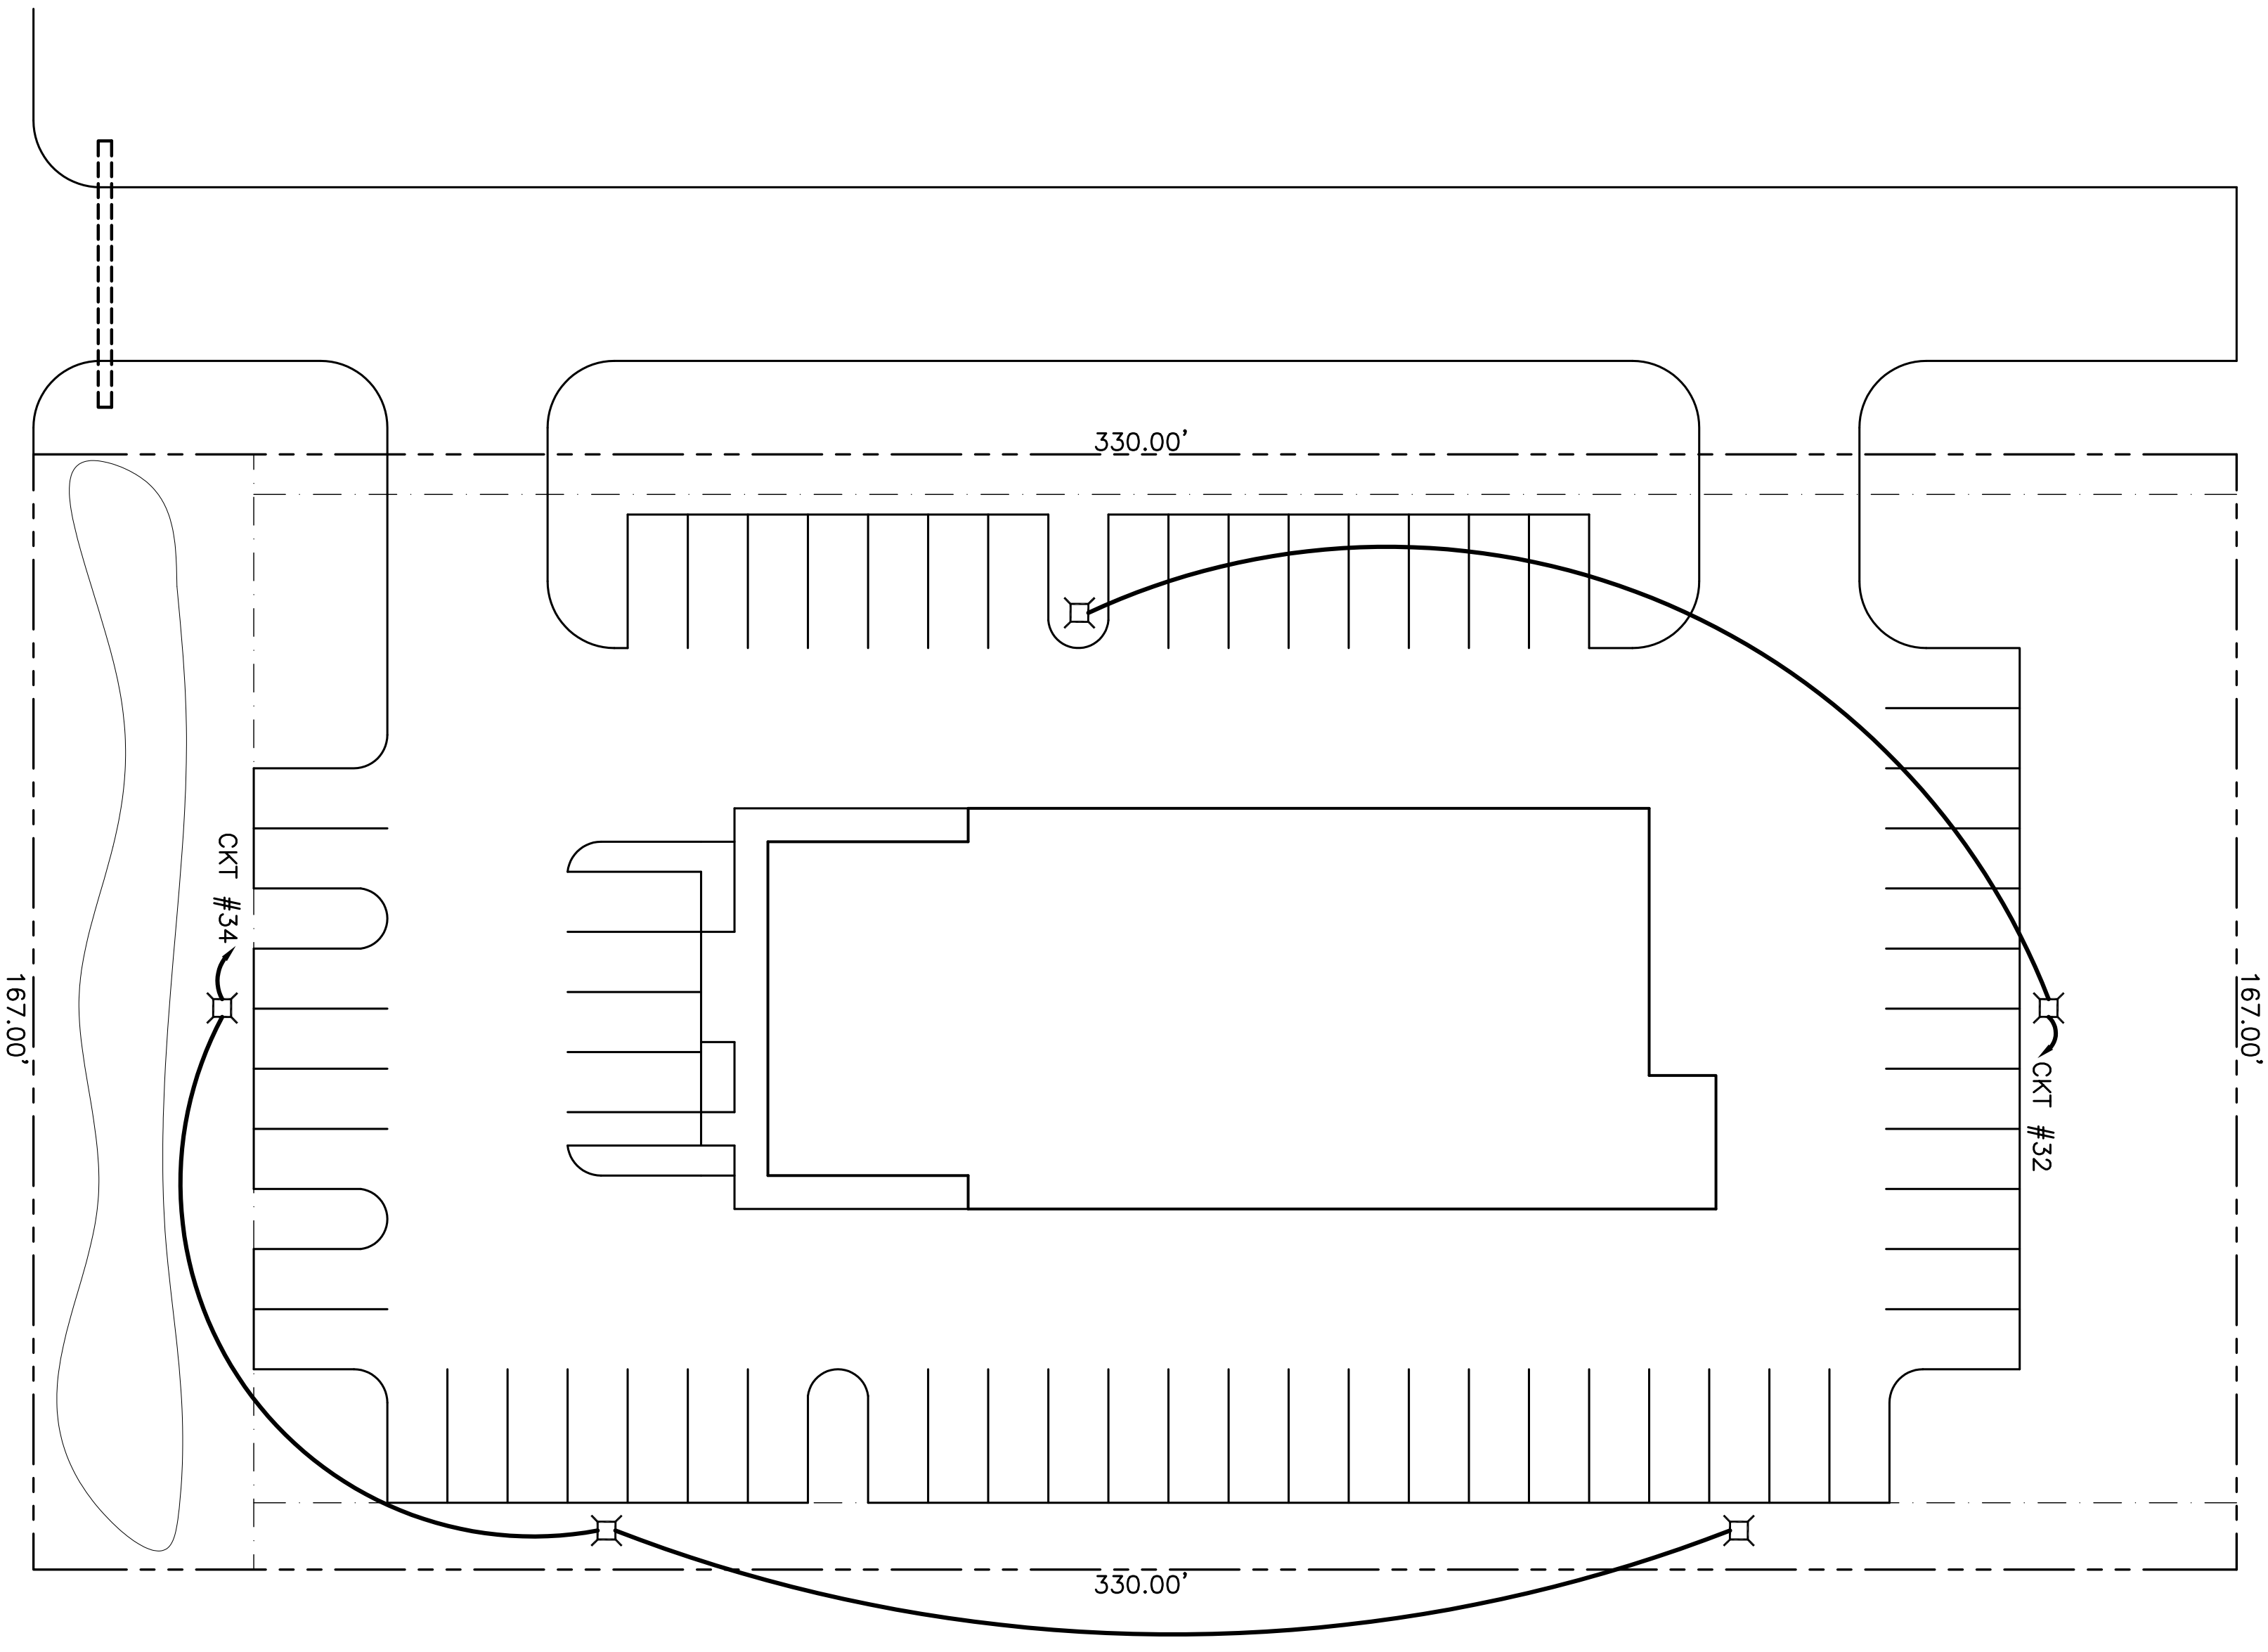

PARKING LOT LIGHTING PLAN
 SCALE: 1"=20'-0"

CROSSGATES TIRE AND AUTOMOTIVE CENTER

DAMMON ENGINEERING, INC.
 ARCHITECTS — ENGINEERS
 2000 OLD SPANISH TRAIL \ STE 100 985-649-5832 SLIDELL, LA. 70458
 DAMMONENGINEERING.COM

PARKING LOT LIGHTING PLAN

MCMATH CONSTRUCTION
 MILITARY ROAD
 SLIDELL, LOUISIANA

SCALE: AS NOTED

FILE:

JOB NO. 1153

DATE: 11-5-03

SHEET

E-2

OF