


SITE LEGEND

---	PROPERTY LINE
---	BUILDING SETBACK MINIMUM
---	NEW 2" WATER LINE
---	NEW SEWER LINE
---	NEW POWER LINE
---	EXISTING SEWER LINE
---	EXISTING WATER LINE
---	EXISTING GAS LINE
---	EXISTING POWER LINE

SITE UTILITIES PLAN
SCALE: 1"=20'-0"

CONTACT MISSISSIPPI POWER:
BUTCH HETH
W# 601-545-4091
C# 601-297-1633

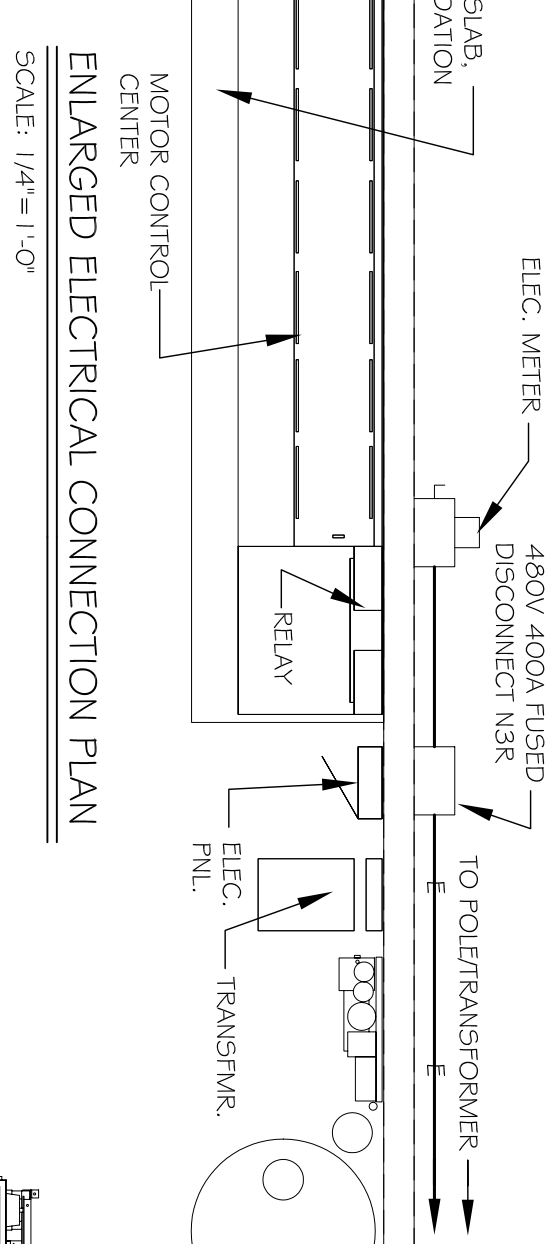

RAINFOREST CARWASH #2
6485 U.S. HWY. 49

HATTIESBURG, MISSISSIPPI 39401

JOB No:	2212	DATE:	10-21-2014
DRAWN BY:	CKD/JTL	CHECKED BY:	CKD

The above drawings and specifications, designs and arrangements represented hereby are and shall remain the property of Dammon Engineering, and no part thereof shall be copied, disposed of, stored, used in connection with any work or project other than the specific project for which they have been prepared and delivered without written consent of Dammon Engineering. Your contact with these drawings or specifications shall constitute conclusive evidence of acceptance of these restrictions.



DAMMON
ENGINEERING, INC.
Architects & Engineers

CHIEF ENGINEER, BRIAN MISTICH, P.E.
554 OLD SPANISH TRAIL
SLIDELL, LA 70458

dammonengineering.com
dammoneng@bellsouth.net
PHONE: 985-649-5832
FAX: 985-641-5950

REVISIONS		DATE
#	DESCRIPTION	

SITE UTILITY PLAN

SHEET No: 04 OF 14

C2