



FIRST FLOOR REFLECTED CEILING PLAN

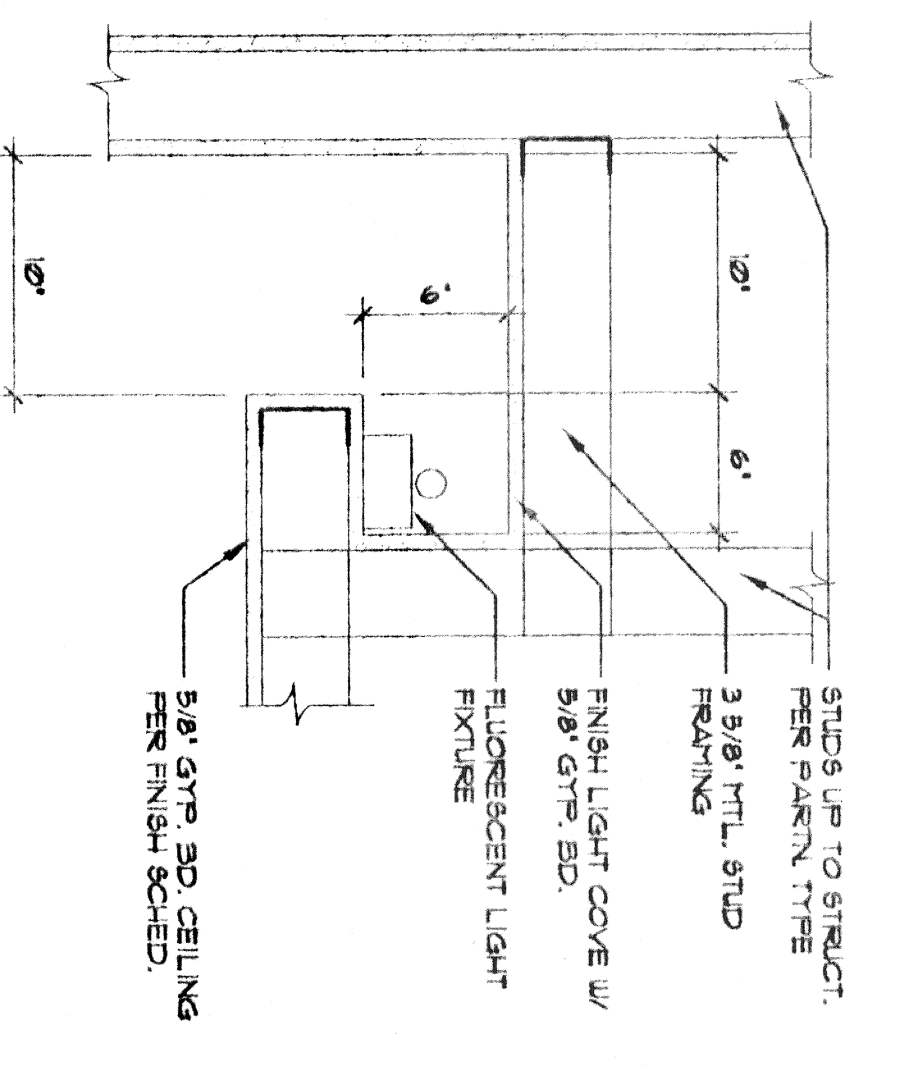

2 LIGHT COVER
1/2" = 1'-0"

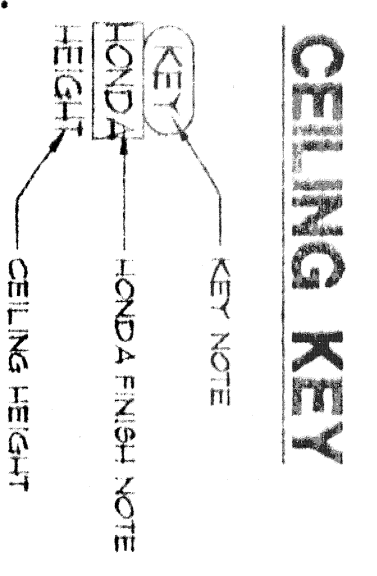

CEILING KEY

- KEYED NOTES**
- (21) RE. CIVIL FOR EXTERIOR PAVING
 - (22) 1/2" EXP. JT.
 - (33) CONCRETE FOUNDATION RE. STRUCT.
 - (33) CONC. SLAB ON PREPARED GRADE
 - (33) CONC. FLOOR ON HIL. DECK
 - (43) CH. WALL. RE. STRUCT. FOR REIN.
 - (51) STEEL BEAM. RE. STRUCT.
 - (52) STEEL COLUMN. RE. STRUCT.
 - (53) STEEL JOIST. RE. STRUCT.
 - (53) STEEL DECK. RE. STRUCT.
 - (53) COLD FORMED STEEL RAFTERS. RE. STRUCT.
 - (53) 3/8" GYM. SHEATHING
 - (53) AIR INTILATION BARRIER
 - (53) 1/2" DIA. RIG. PIPE. MAXIMUM SPACING 48" ON CENTER
 - (53) 6" DIA. PIPE BOLTED PL. W/WOOD
 - (61) WOOD BLOOR ON CONTE.
 - (62) F.L.G. LAM. COUNTERTOP
 - (62) F.L.G. LAM. CABINETS
 - (62) WOOD SHELVES
 - (71) BATT INSUL. WHERE REQUIRED. RE. SECTION
 - (72) ACoustICAL BATT INSULATION
 - (73) EJRA. HECAL ATTACH.
 - (73) EJRA. TORPEDO REVEAL
 - (73) HONDA CANOPY. HAVE
 - (73) 2x4x8x16. SHT. TYP. CORNING
 - (73) BEALANT JOINT
 - (81) HIL. DOOR AND RAYE
 - (81) 8x8 WOOD DOOR
 - (81) ACCESS PANEL
 - (82) COLLING FINE DOOR. I.H.R.
 - (83) OVERHEAD SECTIONAL DOOR
 - (83) COLLING COMPART. SHUTTER
 - (84) HAND ALUM. STORAGE/STORAGE
 - (84) HAND ALUM. STORAGE/STORAGE
 - (84) 1" x 6" B. GLASSING
 - (84) METAL STUD PARTITION OR PARTING. RE. SCHED.
 - (84) SLIP JOINT
 - (84) 8/8" GYM. SO. CEILING
 - (84) 5/8" GYM. SO. THE. W.
 - (84) 5/8" GYM. SOFT. BO.
 - (84) CERAMIC TILE
 - (84) PORCELAIN TILE
 - (84) ACoustICAL PANEL CEILING (GAT/C)
 - (84) RESILIENT TILE FLOORING
 - (84) RESILIENT BASE
 - (84) CARPET
 - (84) PAINT
 - (84) FRONT PAINT
 - (84) FIBERGLASS PANEL (FRP)
 - (84) VINYL WALL COVERING (VWC)
 - (84) TOILET COMPARTMENT
 - (84) SINK
 - (84) LOCKERS
 - (84) FINE EXHAUST FAN
 - (84) TOILET ACCESSORIES
 - (84) RE. SCHED.
 - (84) EQUIPMENT BY OWNER
 - (84) 5/8" RAINWATER BY OTHERS
 - (84) 6" x 6" CORR. INSULATION
 - (84) METAL BUILDING SYSTEM
 - (84) GUTTER
 - (84) FLASHING
 - (84) RE. MESH FOR PLUMBING FIXTURES
 - (84) RE. MESH FOR W/C
 - (84) RE. ELEC. OR LIGHTING

THOMAS PARTNERSHIP
ARCHITECTURE-PLANNING

3000 SOUTH VINE STREET, DENVER, COLORADO 80210 PHONE (303) 589-7504 FAX (303) 691-9790

HONDA OF SLIDELL
NEW FACILITY
SLIDELL, LA.

DATE: 2/12/03
DRAWN BY: CBT/LM
SCALE: AS NOTED
JOB NUMBER: 2002.1
DRAWING TITLE: FIRST FLOOR REF.L. CLG. PLAN

A8.1