



WELL SYSTEM SCHEMATIC  
N.T.S.

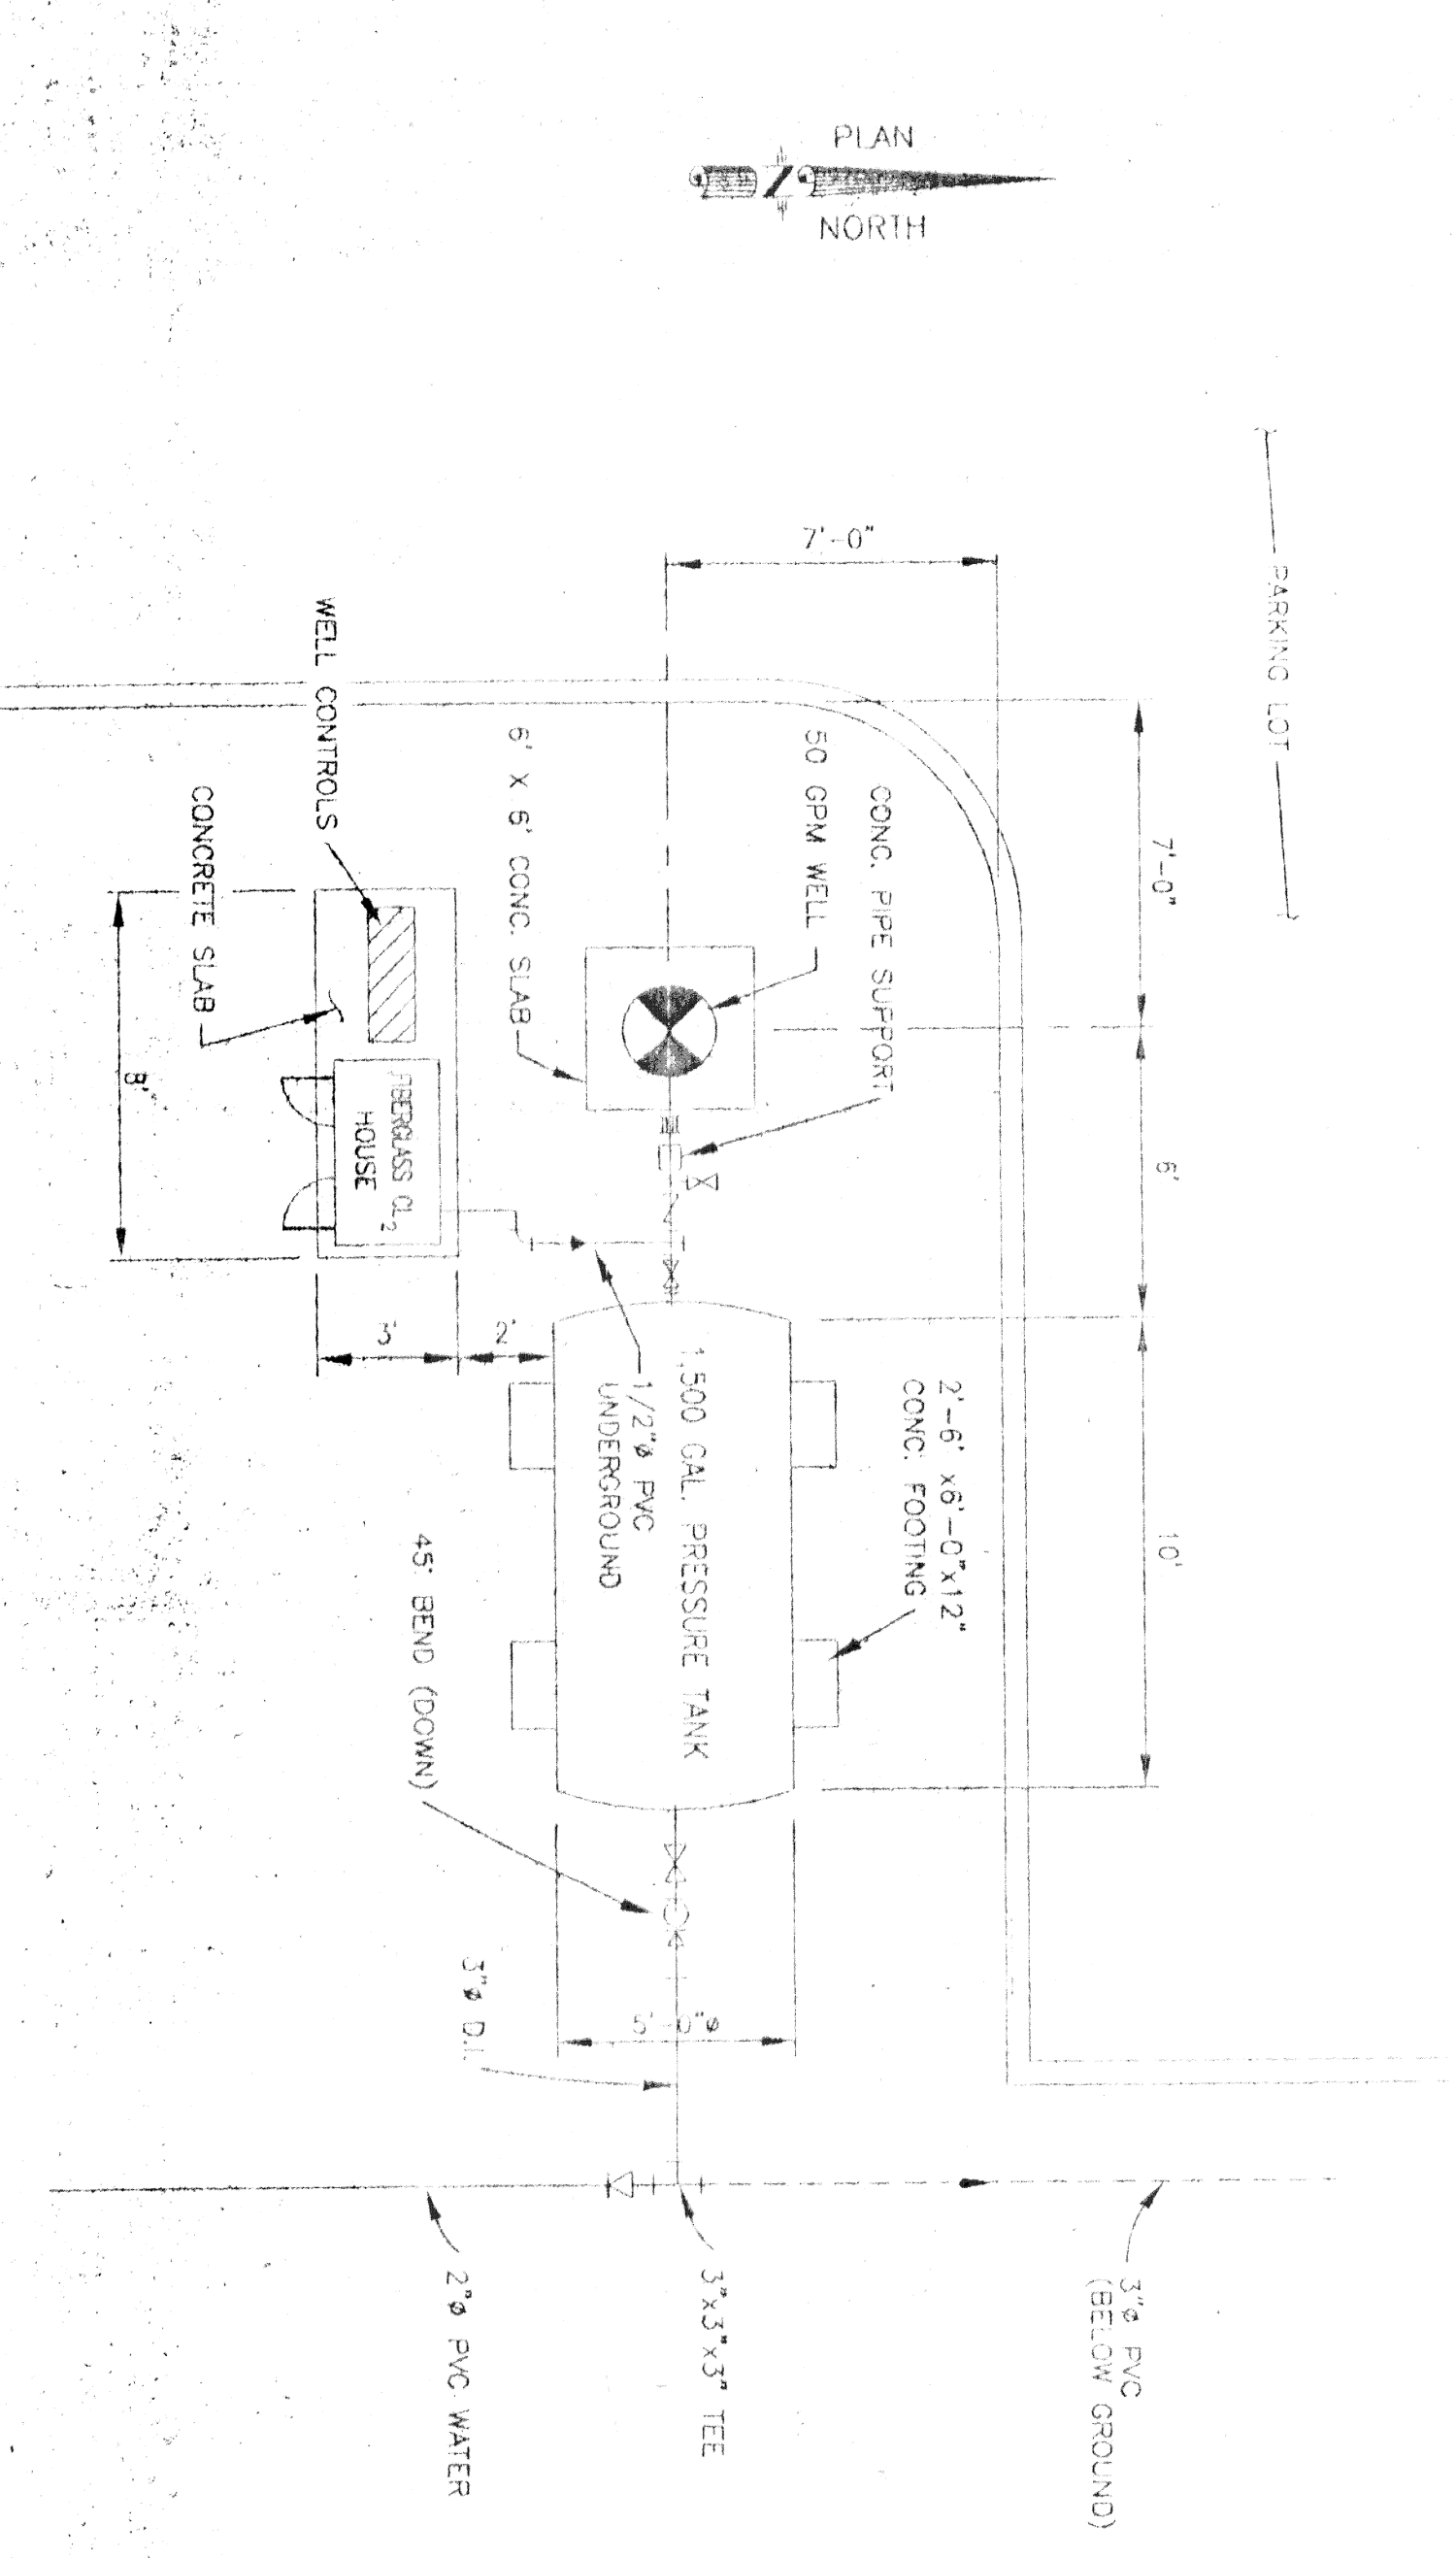

WATER WELL SITE PLAN  
SCALE: 1" = 4'-0"

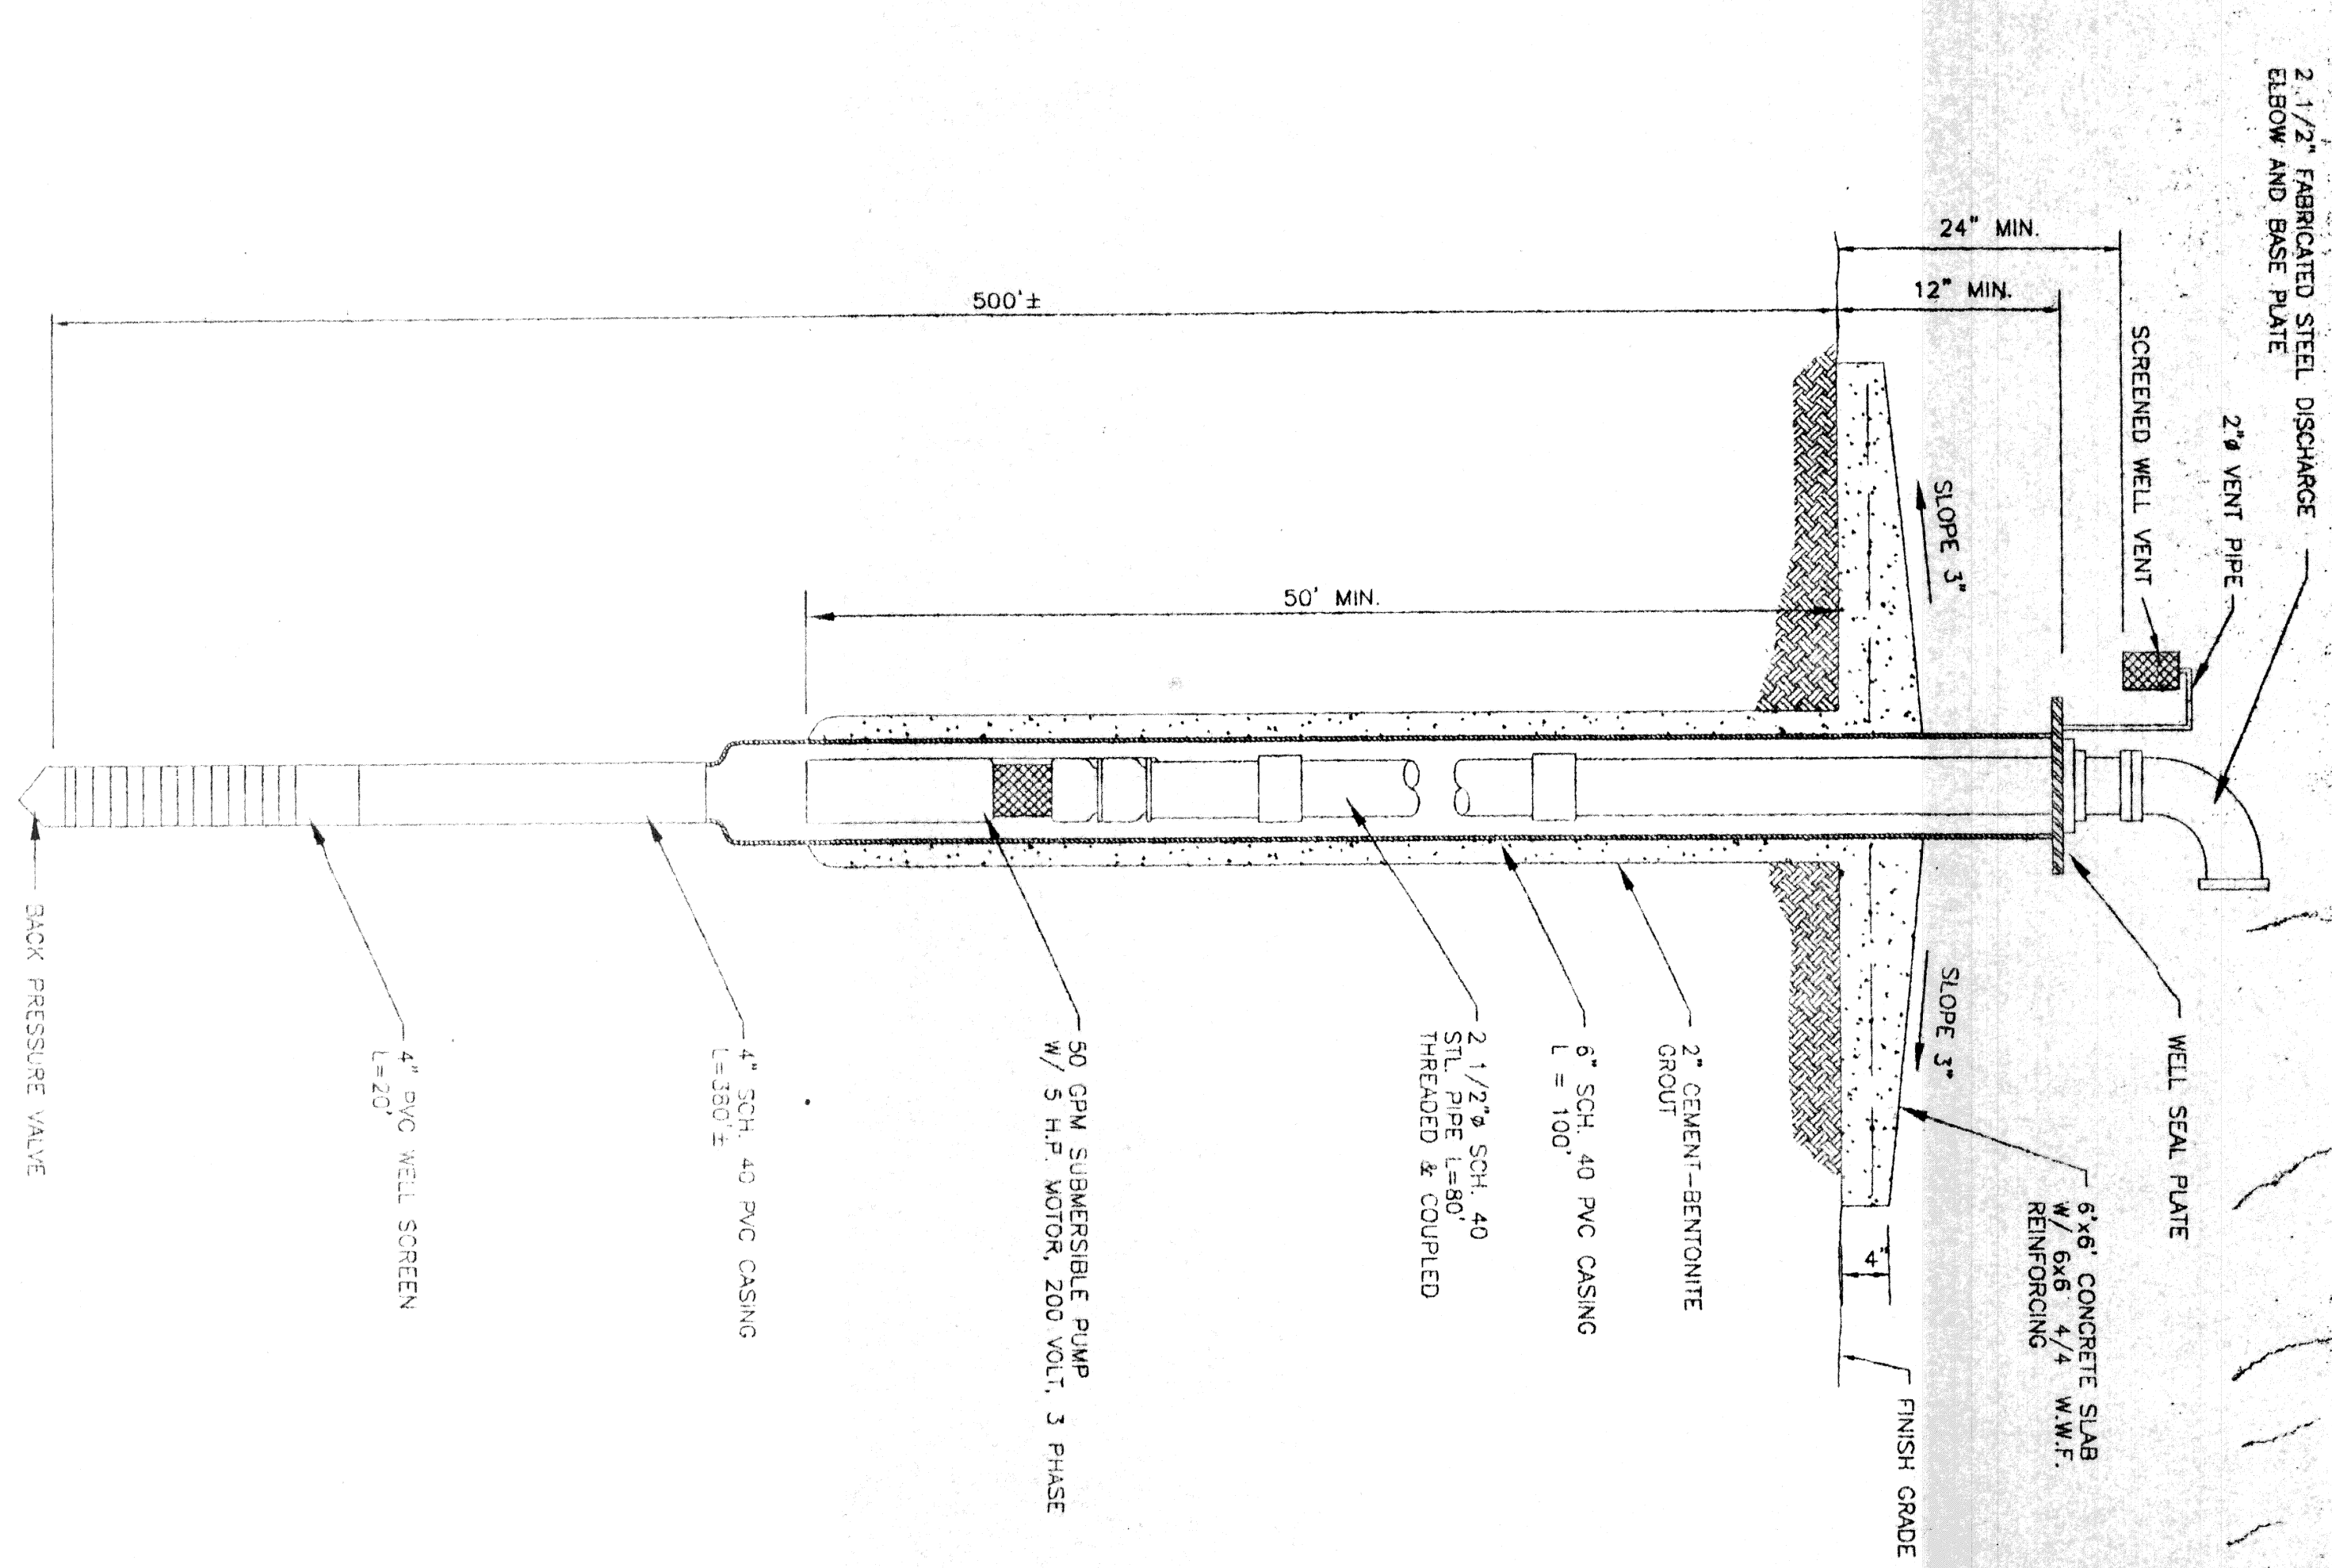

WATER WELL  
N.T.S.

- WATER WELL NOTES:
1. COMPLETED WATER WELL SHALL PRODUCE 50 GPM AT 60 PS (AT GROUND LEVEL).
  2. ALL WORK SHALL COMPLY WITH L.A. D.O.T.D. AND HEALTH DEPT. AND REGULATIONS.
  3. CONCRETE FOR SLABS AND FOUNDATIONS SHALL BE 3000 PS @ 28 DAYS WITH 5 W/6.6 4/4 W.W.F.
  4. Submit and file LF for 1" Add Depth

**HONDA DEALERSHIP**  
LAKESHORE ESATES  
ST. TAMMANY PARISH, LA

**KREBS, LASALLE, LEMIBUX CONSULTANTS, INC.**  
ENGINEERING • PLANNING • SURVEYING • HYDROLOGY • ENVIRONMENTAL  
3013 27TH STREET, METairie, LA 70002 (504) 837-3870  
1107 N. CALLESTOWN BLVD. SUITE 1, MONROE, LA 70001 (504) 224-5123

NO.	DESCRIPTION	DATE	DESIGNED BY	CHECKED BY	SCALE	REVISION

WATER WELL DETAILS & NOTES

DESIGNED BY: [Signature] DATE: 11/2/07  
CHECKED BY: [Signature] DATE: 11/2/07