


FILE NAME: A:_Common\1303 - New Building\1303 - New Building.dwg, PLOT DATE: 8/26/18, 10:11:15 AM

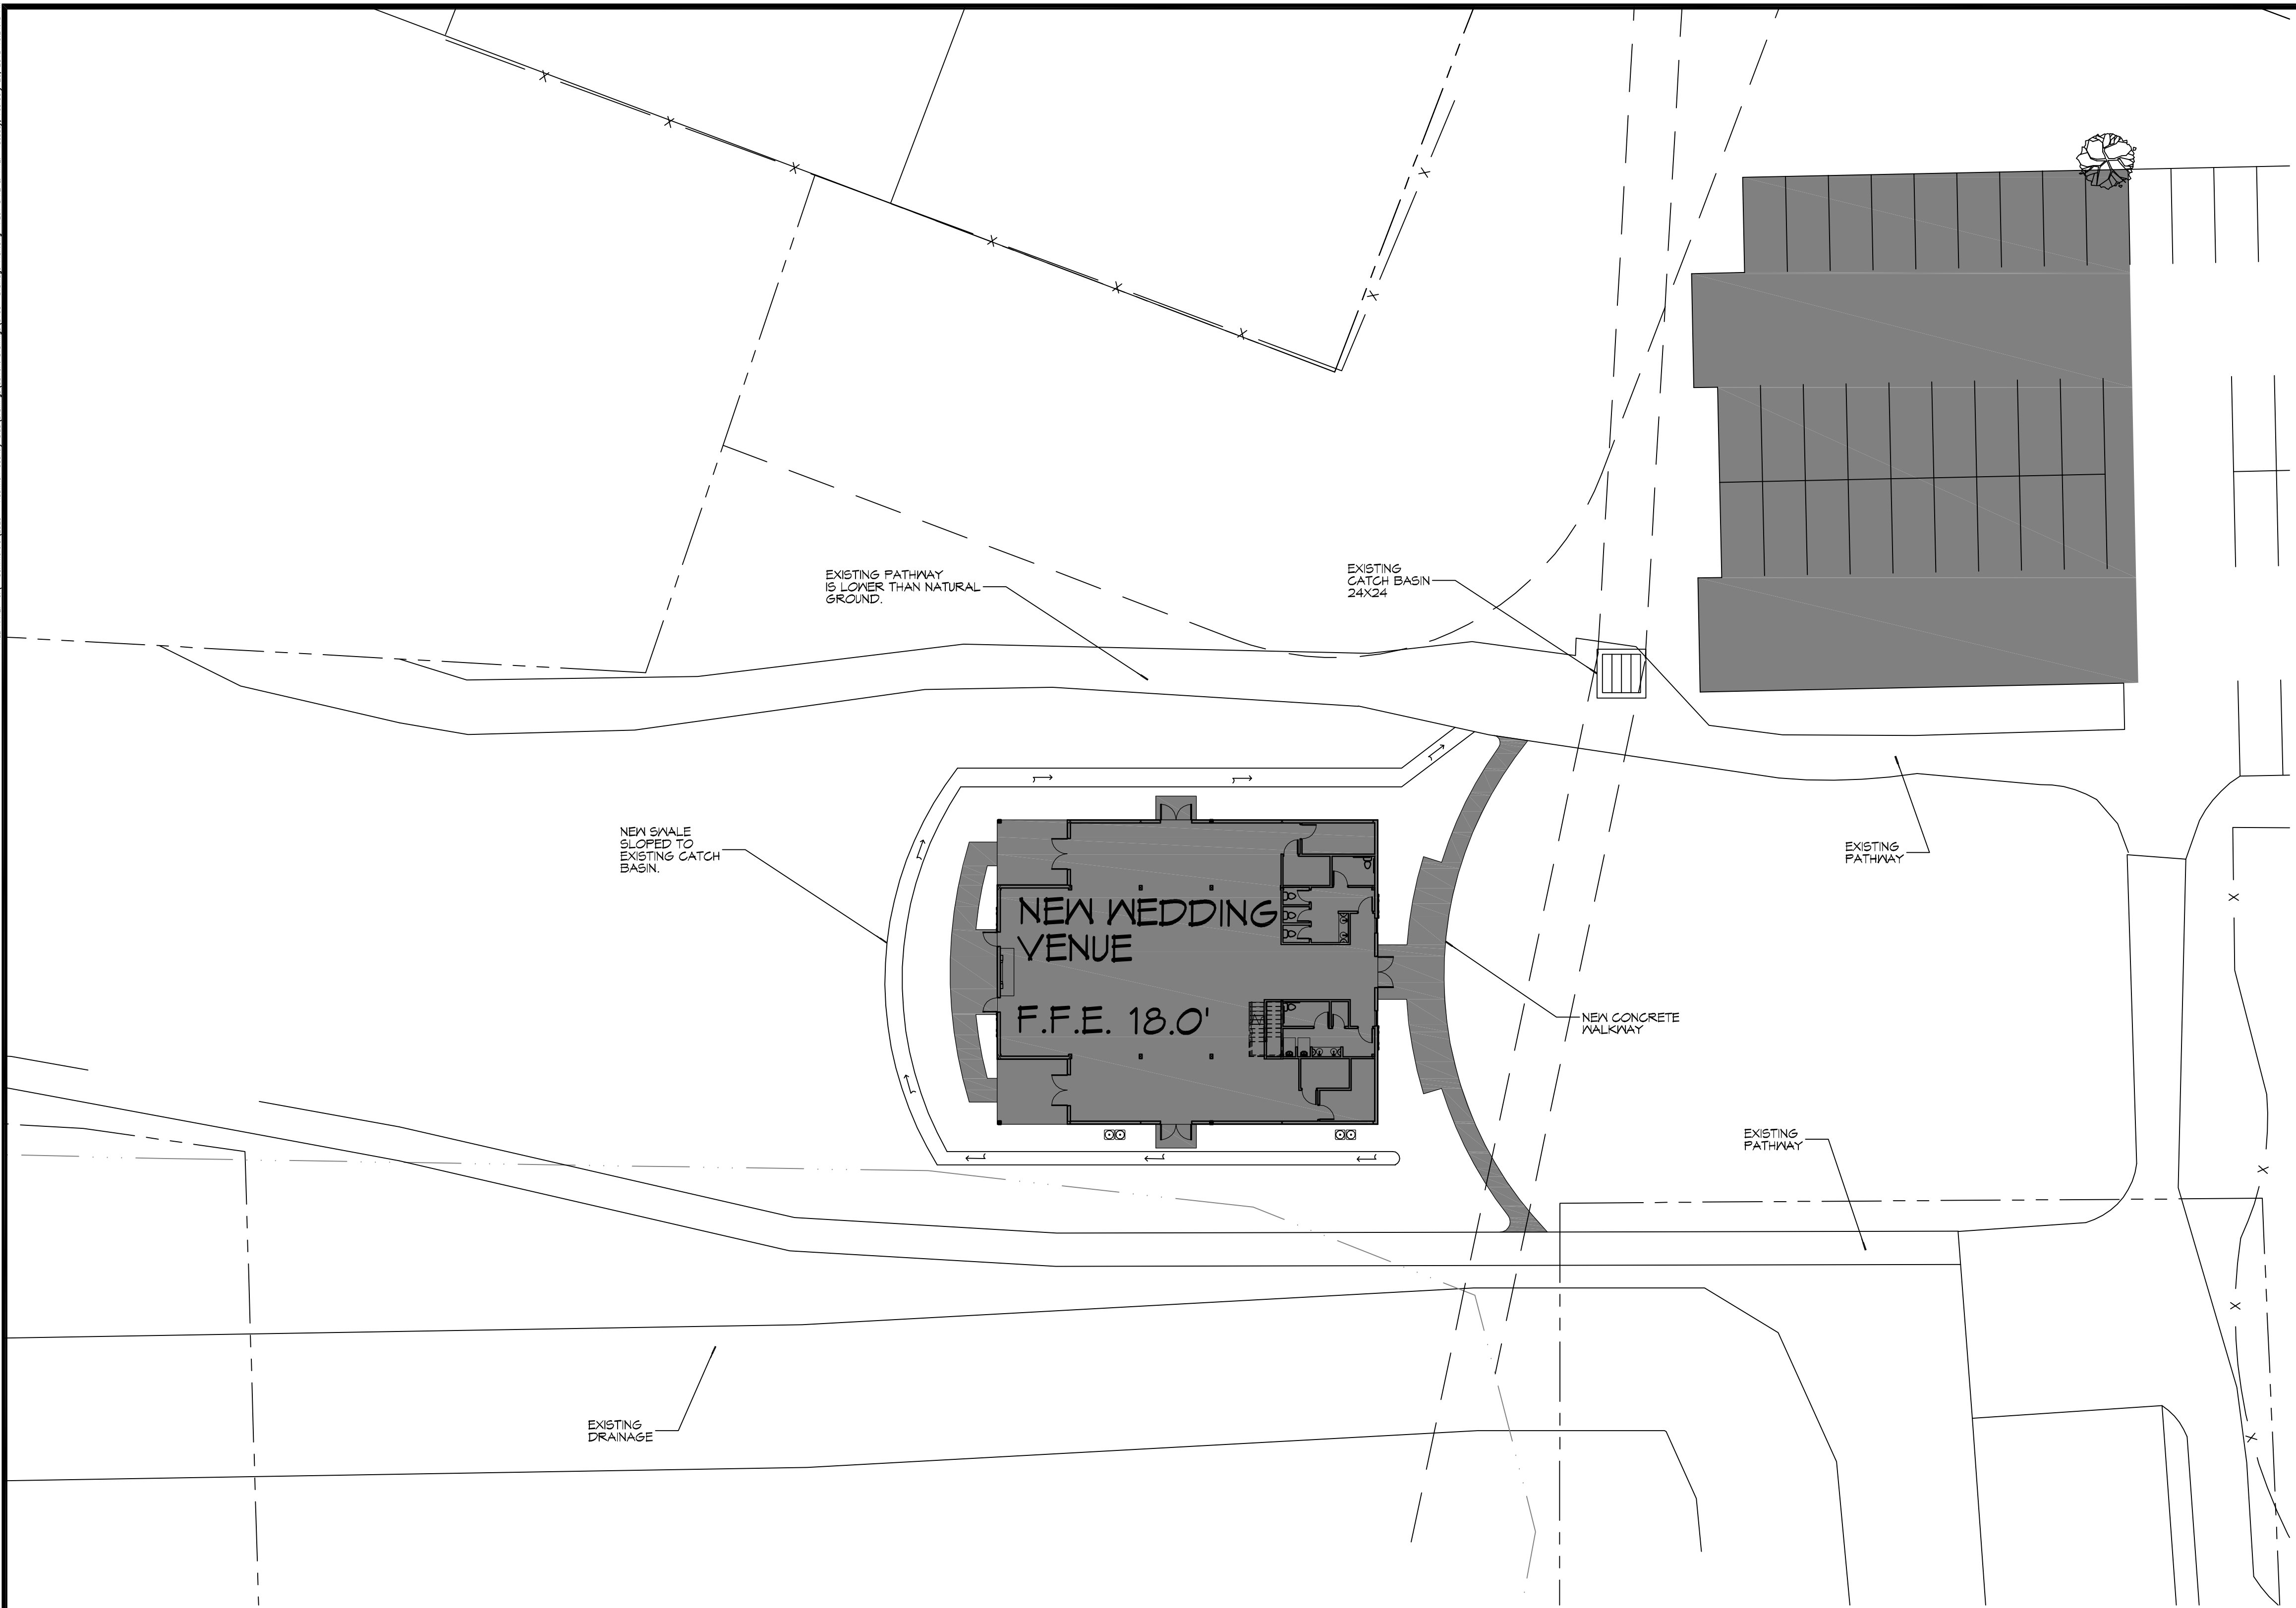


1 DRAINAGE SITE PLAN
SCALE: 1"=20'-0"

DAMMON
ENGINEERING, INC.
LOUISIANA & MISSISSIPPI

Chief Engineer: Brian Mistich, PE
554 Old Spanish Trail
Slidell, LA 70468
www.dammonengineering.com
info@dammonengineering.com
PH: 985.649.9832

#	DESCRIPTION	REVISIONS	DATE

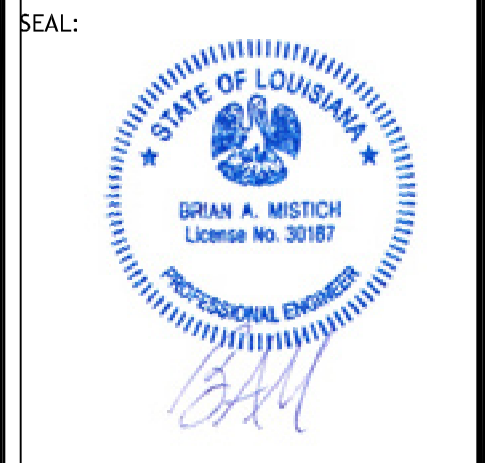

NEW BUILDING
PINEDOOD VENUE

405 COUNTRY CLUB BLVD.
SLIDELL, LA, 70468

JOB No: 2224 DATE: 01/30/18
DRAWN BY: C&D CHECKED BY: BAW

SHEET TITLE:
DRAINAGE
PLAN

DRAWING NUMBER:
C103

SHEET No: 1 of 2