



ELECTRICAL NOTES:

1. ALL INSTALLATION SHALL BE DONE PER THE LATEST EDITION OF THE NATIONAL ELECTRICAL CODE AND SHALL COMPLY WITH ALL APPLICABLE LOCAL AND PARISH REQUIREMENTS. ALL DEVICES SHALL BE UL AND NEMA RATED AND APPROVED. INSTALL ARC FAULT RECEPTACLES IN BEDROOMS. INSTALL UL APPROVED SMOKE DETECTORS WITH DIRECT WIRING TO THE 110V AC DEDICATED CIRCUIT AND BATTERY BACKUP. INTERCONNECT DETECTORS PER THE MANUFACTURER'S SPECIFIC WRITTEN INSTRUCTIONS.
2. ELECTRICAL SERVICE ENTRANCE AND DISTRIBUTION PANEL SHALL BE LOCATED BY THE ELECTRICAL CONTRACTOR AND BY THE OWNER, WITHIN THE APPLICABLE CODE REQUIREMENTS. ALL ELECTRICAL FIXTURES, LIGHTING, CEILING FANS, VENTS, HOODS, HEATERS, ETC. SHALL BE OWNER APPROVED PRIOR TO INSTALLATION.
3. INSTALL TELEPHONE AND CABLE T.V. JACKS LOCATED BY OWNER. COORDINATE JACK LOCATIONS WITH THE INSTALLING CONTRACTOR. (INCLUDE ALL WIRE, CABLE, JACKS, BOXES, DEVICES, TERMINAL BLOCKS, ETC.) PROVIDE/INSTALL ATTIC LIGHT AND DUPLEX RECEPTACLE FOR ATTIC ACCESS.
4. INSTALL ELECTRIC "DEMAND" TYPE WATER HEATER, OUTDOOR TANKLESS TYPE, PER OWNER AND INSTALLING CONTRACTOR. COORDINATE ELECTRICAL INSTALLATION WITH THE ELECTRICAL CONTRACTOR. ROUTE CONDUIT, POWER, AND CONTROL WIRING TO HVAC EQUIPMENT LOCATED BY OWNER AND HVAC CONTRACTOR. INSTALL A PROGRAMMABLE THERMOSTAT.

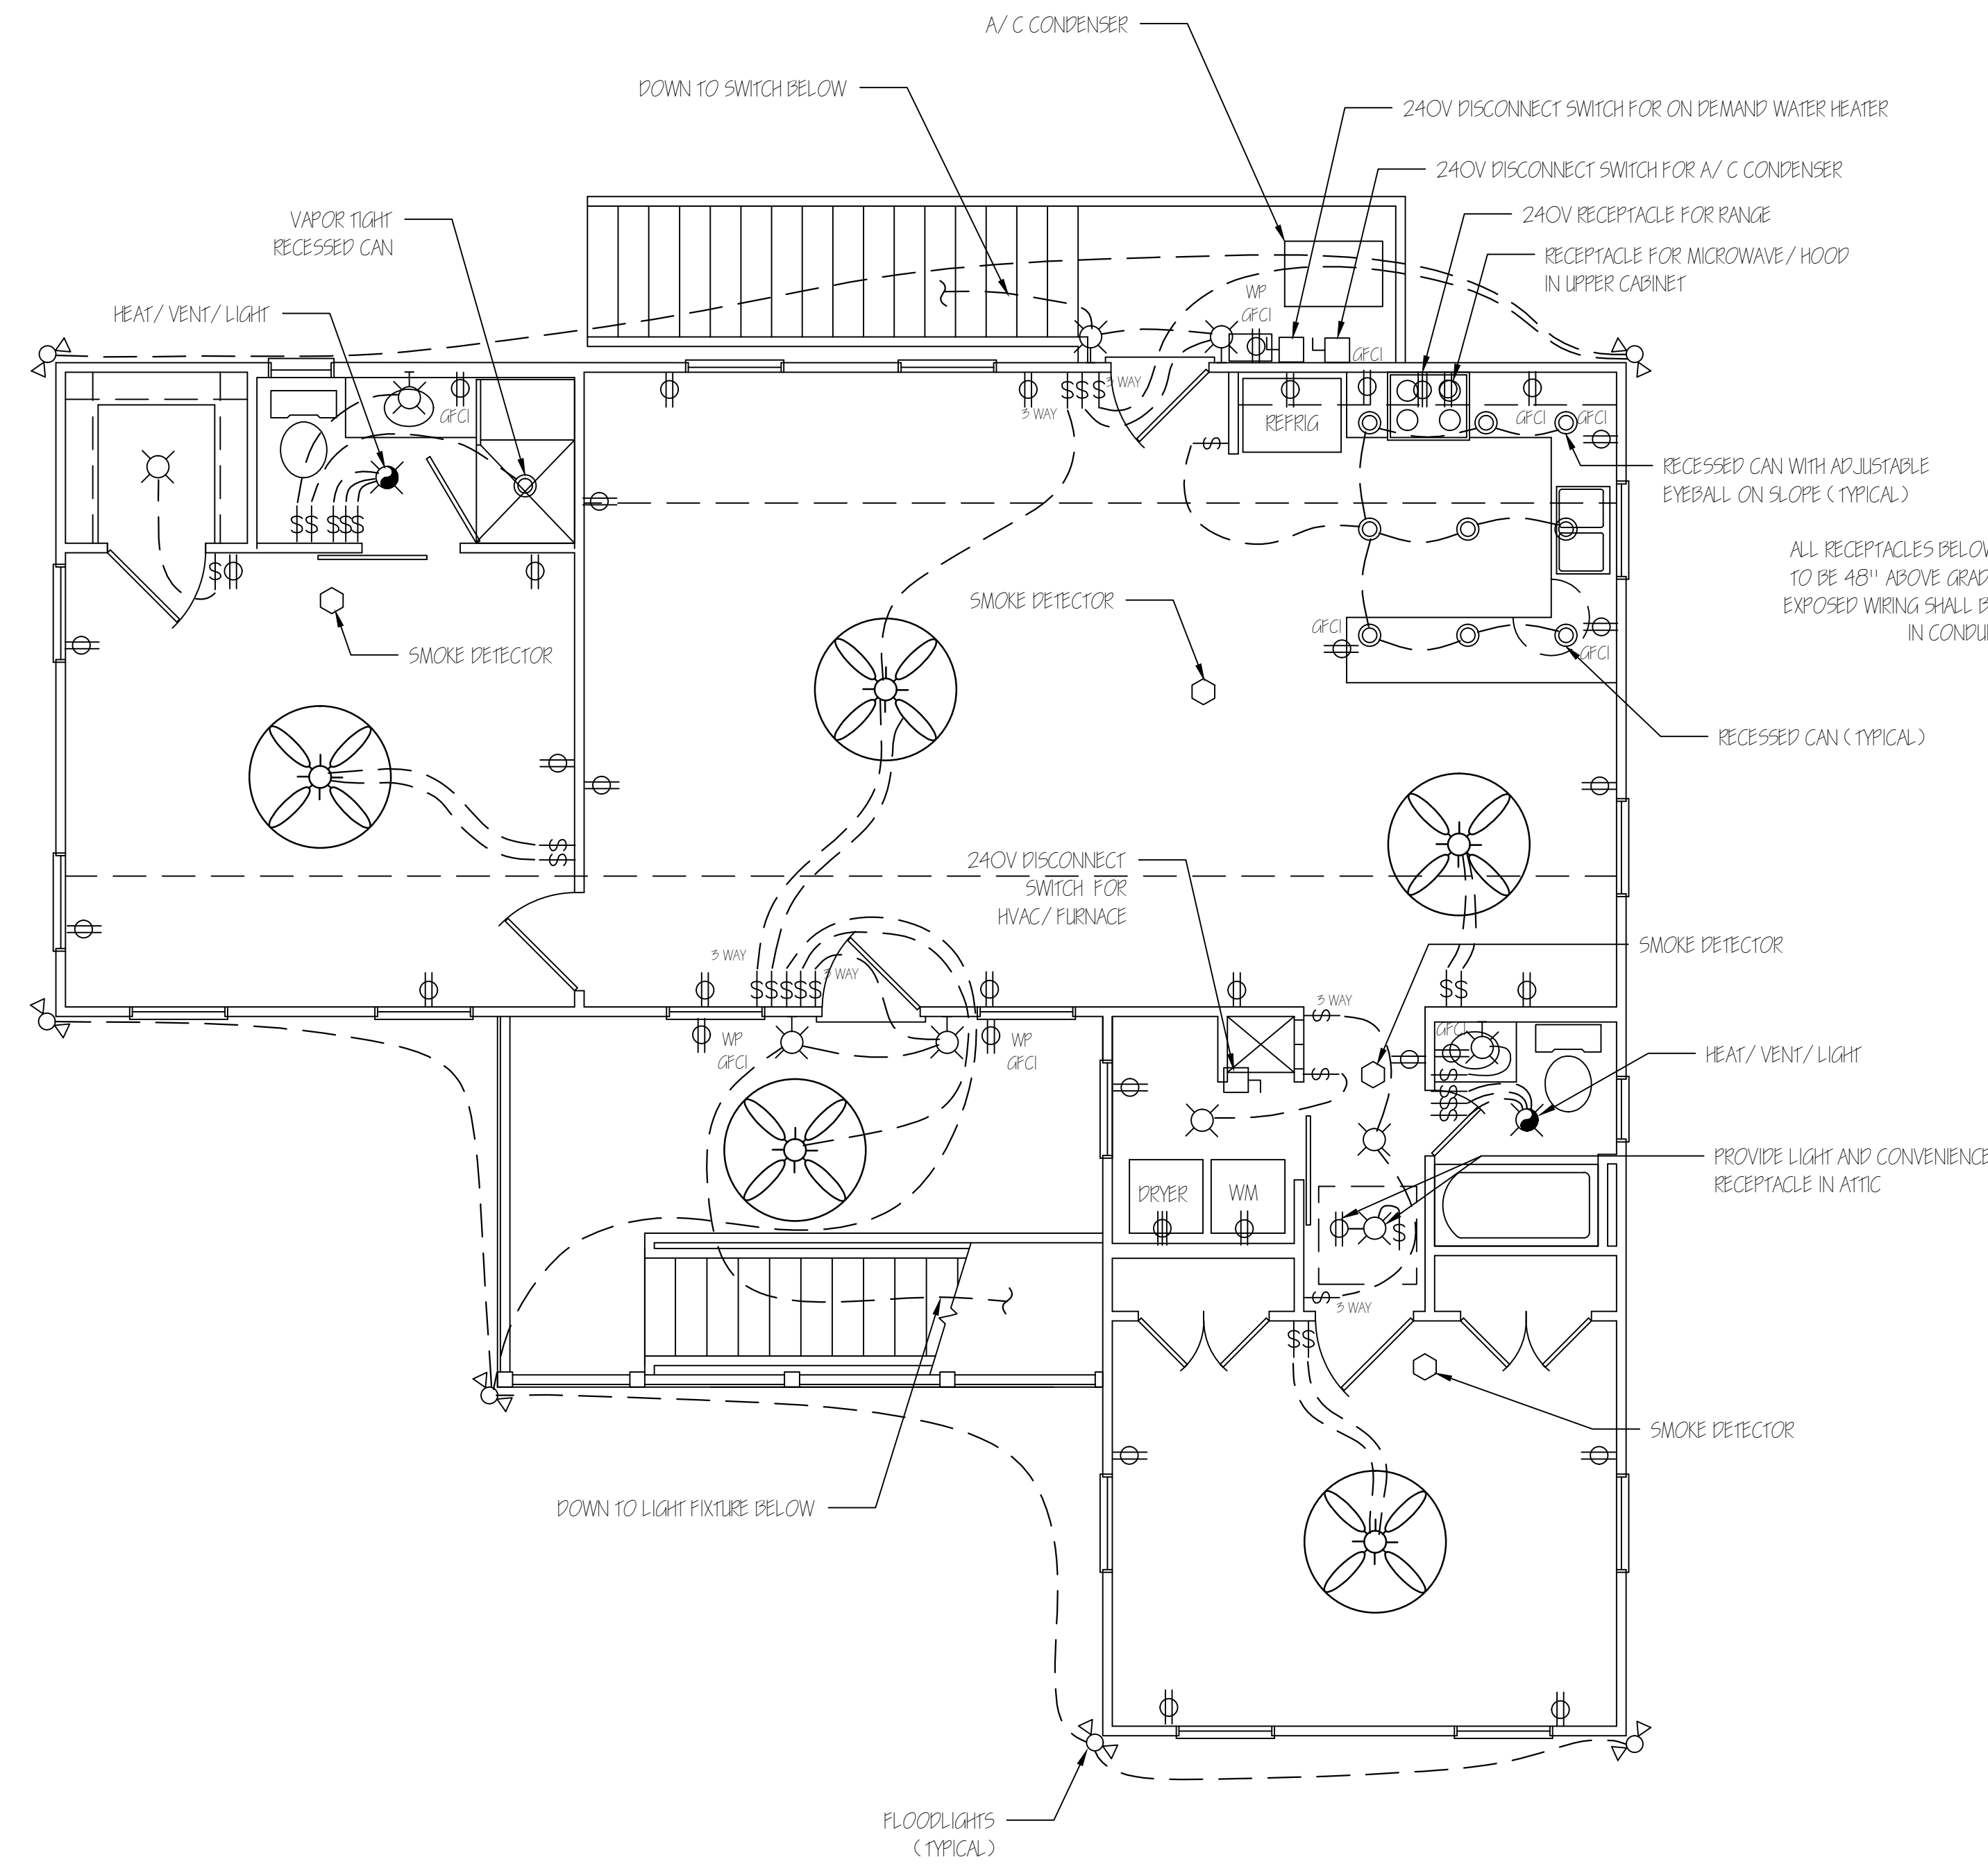

MAIN FLOOR PLAN
SCALE: 3/4" = 1'-0"

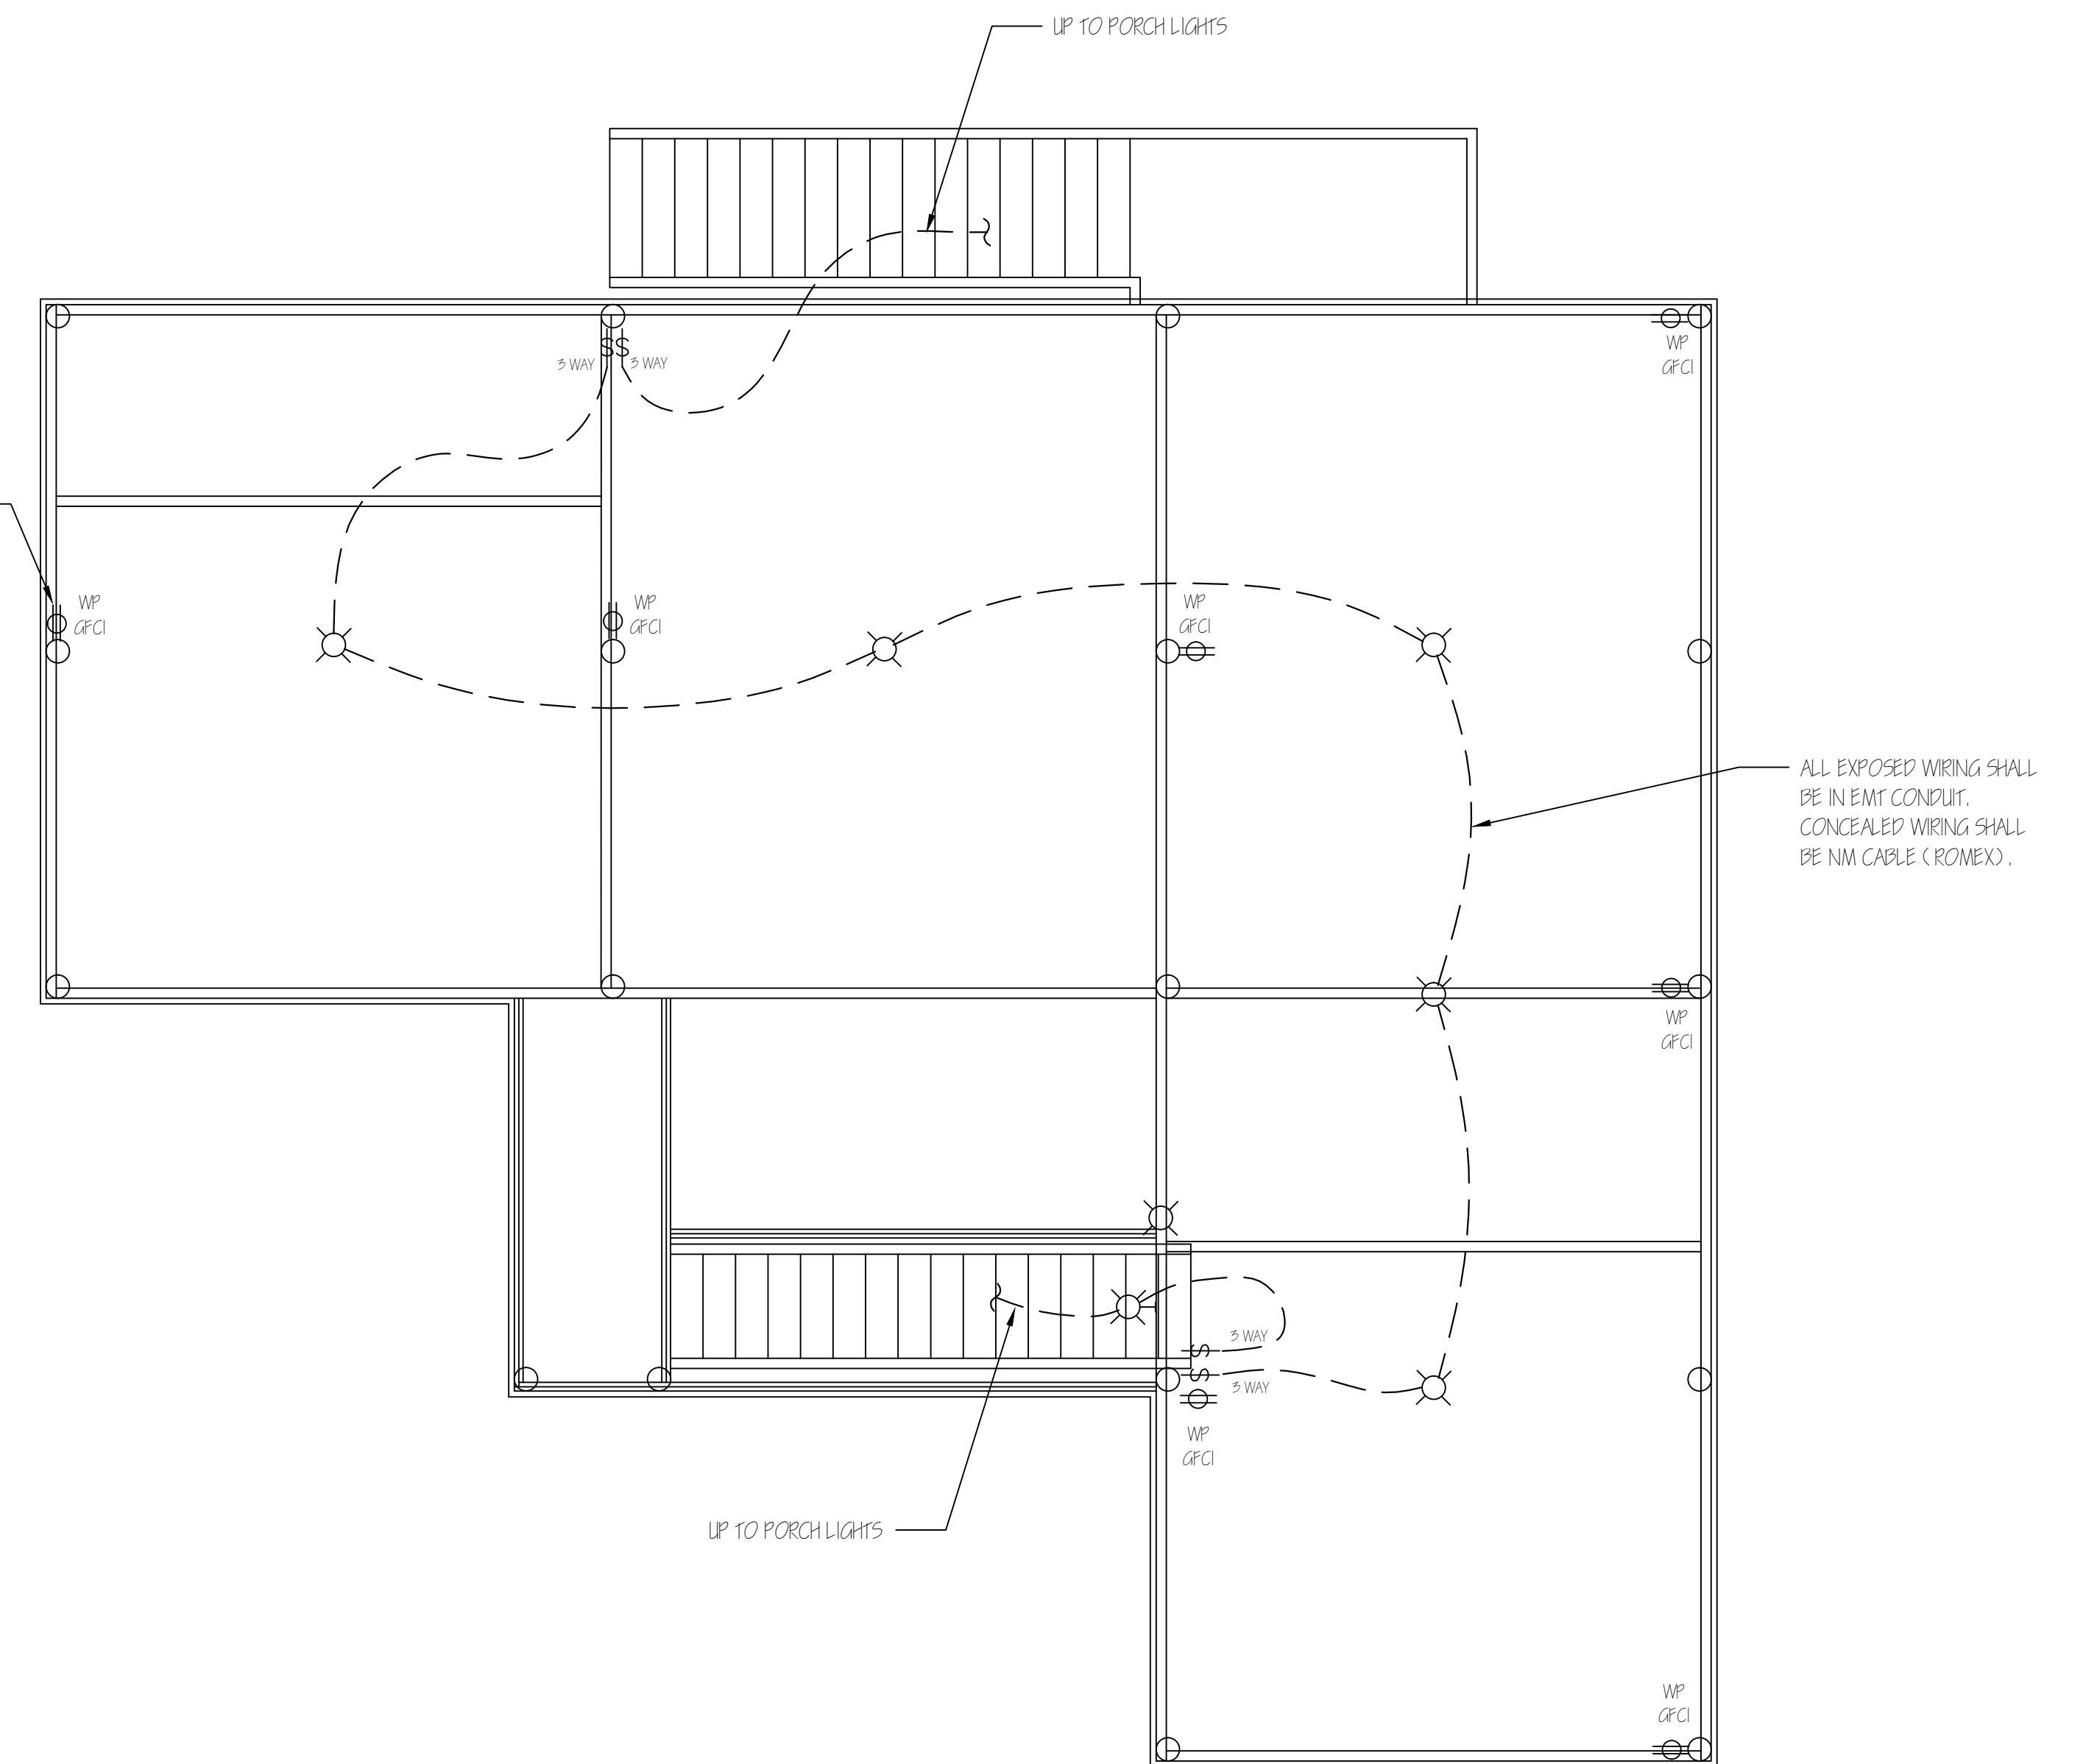

LOWER FLOOR PLAN
SCALE: 3/4" = 1'-0"

ALL EXPOSED WIRING SHALL BE IN EMT CONDUIT. CONCEALED WIRING SHALL BE NM CABLE (ROMEX).

| | |
|--|-------------------------|
| A RESIDENCE FOR: MR. AND MRS. KEITH P. JOURDAN LOT-6, SQUARE-2 OF BELLE ACRES SUBDIVISION, SUDBELL, LA. | |
| SCALE: 3/4" = 1'-0" | APPROVED BY: |
| DATE: | DRAWN BY: ARIANNE RINDE |
| ELECTRICAL POWER AND LIGHTING | |
| ELECTRICAL | |
| DRAWING NUMBER: | |

| | |
|-------|---|
| SHEET | 5 |
| 5 | |