


# NAVAIRSEFAC CALIBRATION BUILDING

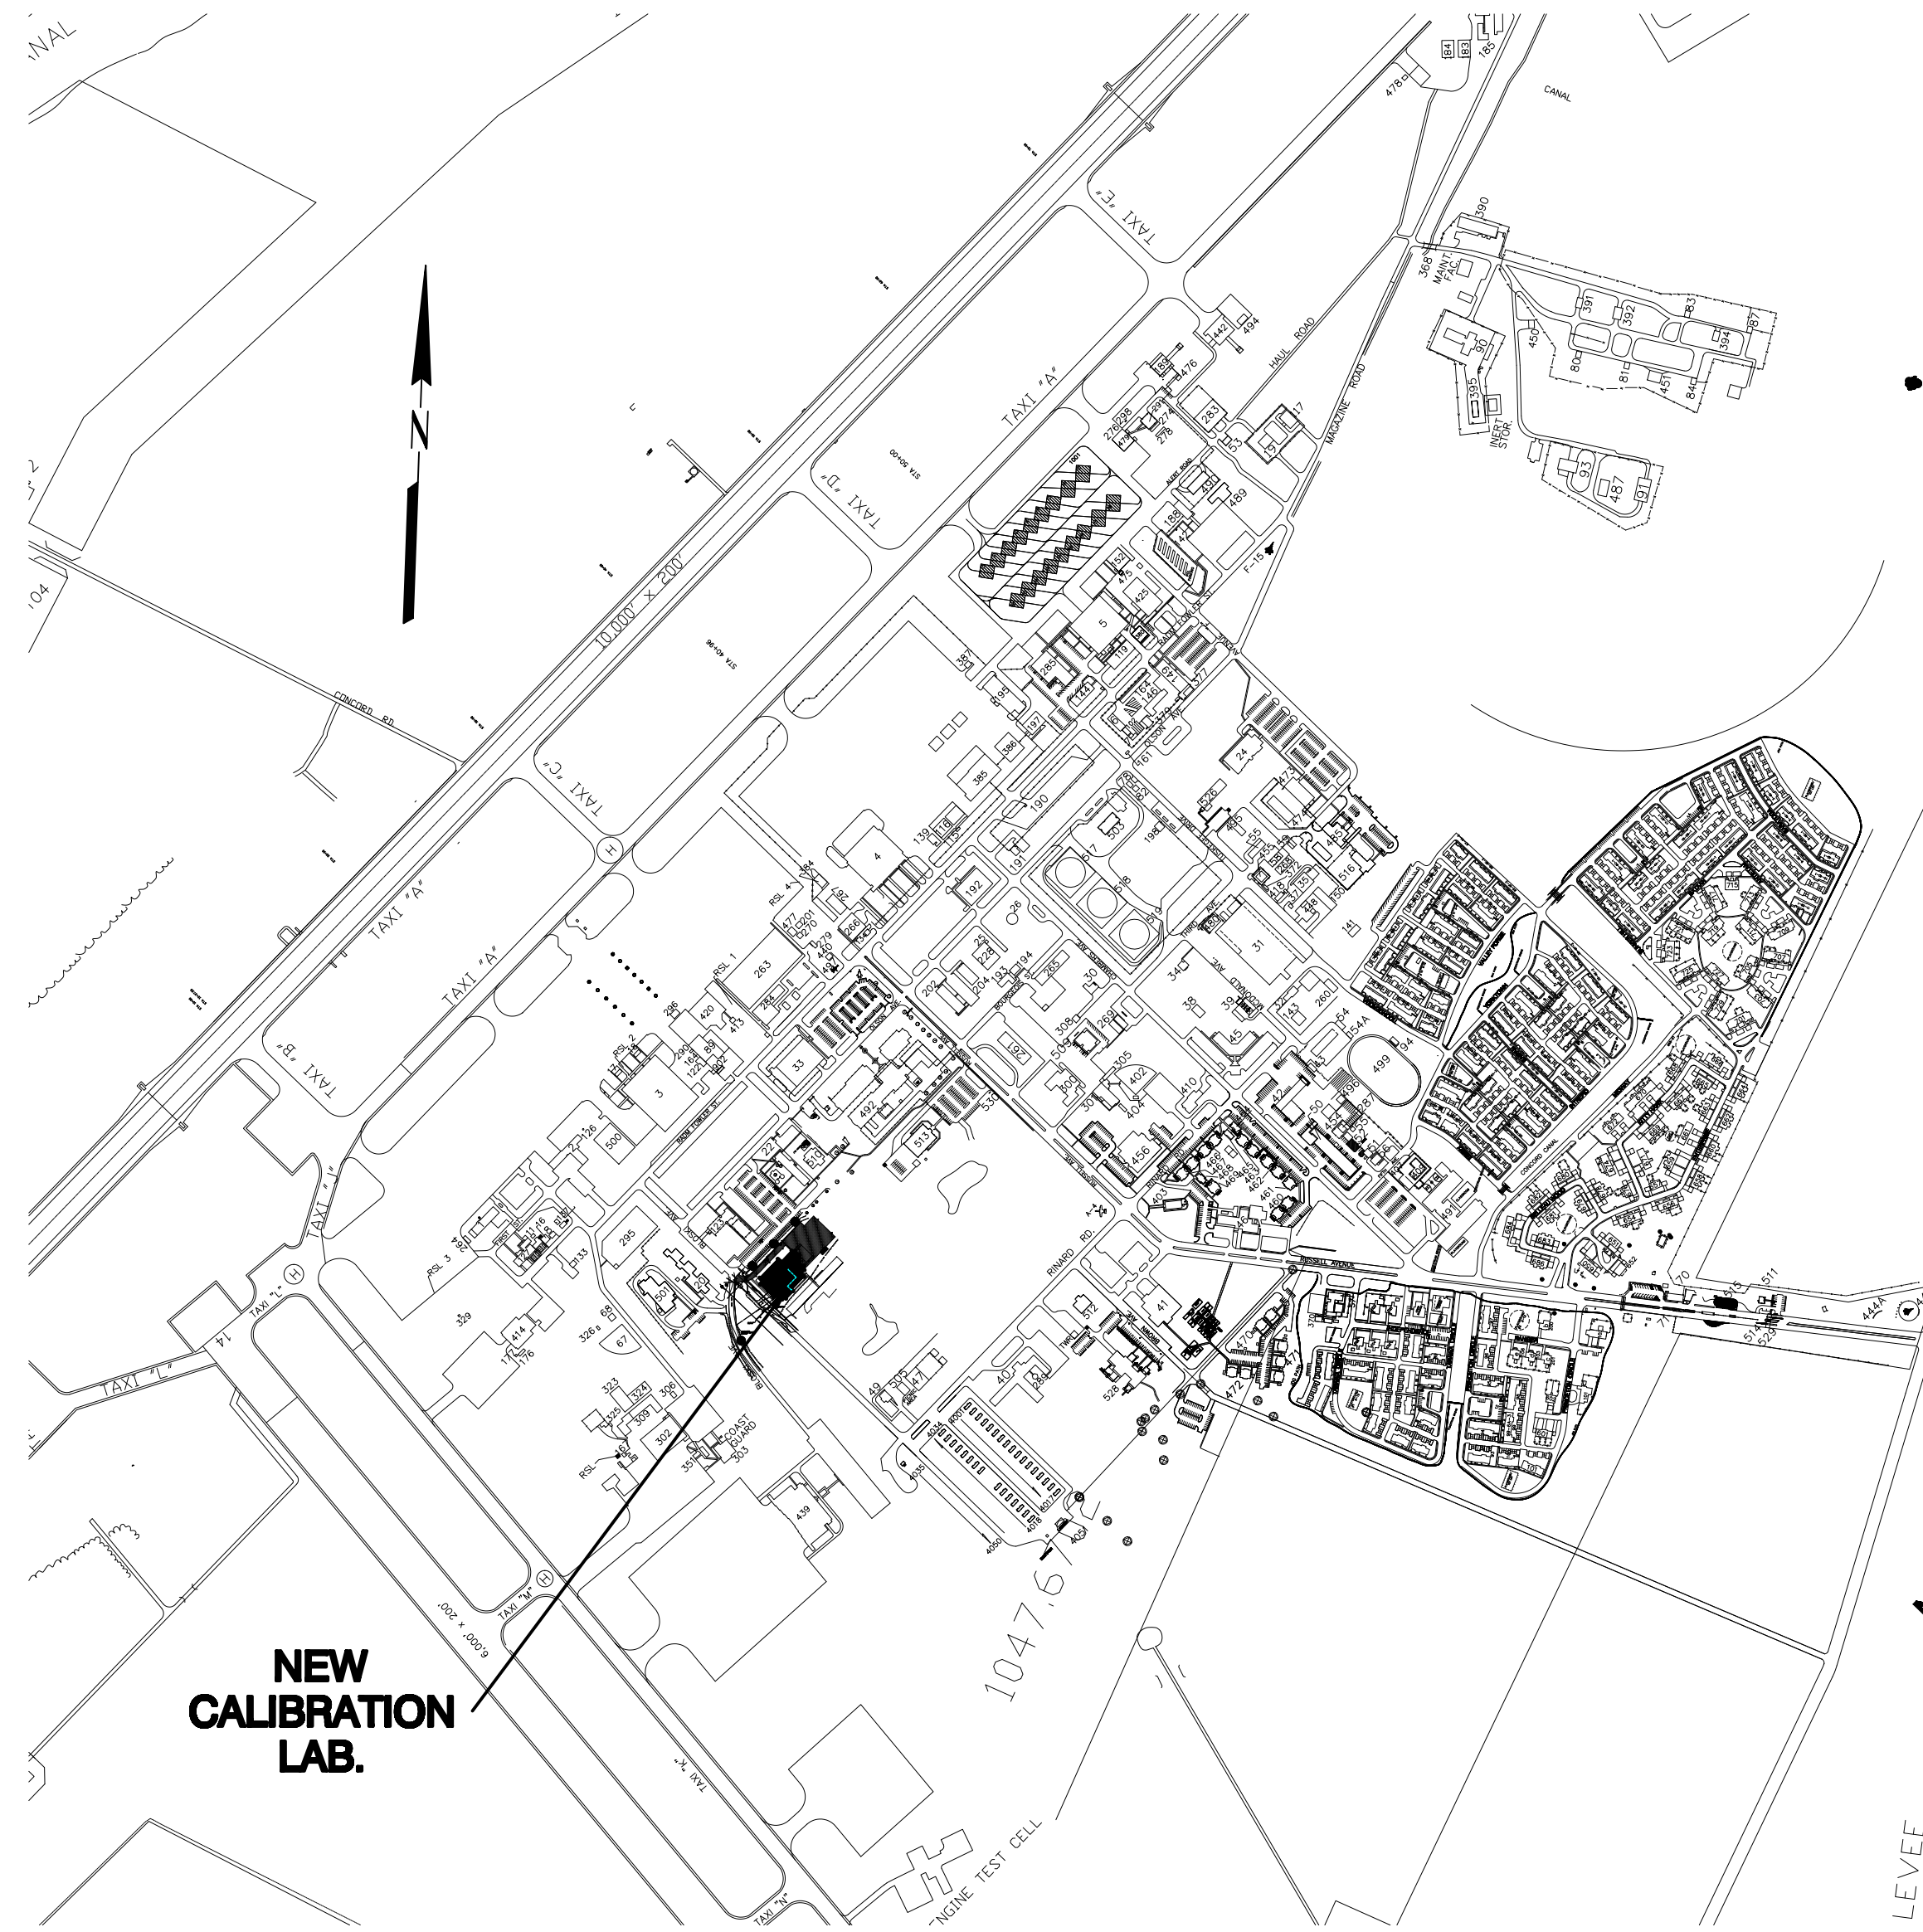

VICINITY MAP  
N.T.S.

ISSUED BY:  
Waldemar S. Nelson & Co.  
**FINAL DESIGN**  
29 / OCT / 2009

## DRAWING INDEX

SHEET No.	REV.	NAVFAC DRAWING No.	REV. DATE	DESCRIPTION	SHEET No.	REV.	NAVFAC DRAWING No.	REV. DATE	DESCRIPTION
T-01	0	15030863	10/29/2009	TITLE SHEET, VICINITY MAP, DRAWING INDEX	CID-01	0	15030922	10/29/2009	FURNITURE / EQUIPMENT PLAN
C1	0	15030867	10/29/2009	CIVIL SITE PLAN	SID-01	0	15030923	10/29/2009	SID FLOOR PLAN
C2	0	15030868	10/29/2009	UTILITIES PLAN	SID-02	0	15030924	10/29/2009	FINISH SCHEDULE, MATERIAL LEGEND
C3	0	15030869	10/29/2009	GRADING & DRAINAGE PLAN	SID-03	0	15030925	10/29/2009	INTERIOR ELEVATIONS
C4	0	15030870	10/29/2009	SECTIONS, DETAILS AND NOTES	SID-04	0	15030926	10/29/2009	FLOOR FINISH PLAN
S0	0	15030874	10/29/2009	STRUCTURAL GENERAL NOTES	M-00	0	15030930	10/29/2009	HVAC GENERAL NOTES
S1	0	15030875	10/29/2009	SLAB PLAN	M-01	0	15030931	10/29/2009	HVAC SCHEDULE - SHEET 1 OF 2
S2	0	15030876	10/29/2009	PILE PLAN	M-01.1	0	15030932	10/29/2009	HVAC SCHEDULE - SHEET 2 OF 2
S2.1	0	15030877	10/29/2009	SLAB REINFORCEMENT PLAN	M-02	0	15030933	10/29/2009	HVAC FIRST FLOOR PLAN
S3	0	15030878	10/29/2009	SECTIONS AND DETAILS - SHEET 1 OF 4	M-02.1	0	15030934	10/29/2009	HVAC MEZZANINE PLAN
S4	0	15030879	10/29/2009	SECTIONS AND DETAILS - SHEET 2 OF 4	M-03	0	15030935	10/29/2009	HVAC FIRST FLOOR PIPING
S5	0	15030880	10/29/2009	SECTIONS AND DETAILS - SHEET 3 OF 4	M-03.1	0	15030936	10/29/2009	HVAC MEZZANINE PIPING
S6	0	15030881	10/29/2009	SECTIONS AND DETAILS - SHEET 4 OF 4	M-04	0	15030937	10/29/2009	HVAC ROOF PLAN
S7	0	15030882	10/29/2009	PILE CAP SCHEDULE	M-05	0	15030938	10/29/2009	HVAC SECTIONS
S8	0	15030883	10/29/2009	STRUCTURAL MEZZANINE PLAN AND DETAILS	M-05.1	0	15030939	10/29/2009	HVAC ELEVATIONS
S9	0	15030884	10/29/2009	STRUCTURAL FRAMING DETAILS	M-06	0	15030940	10/29/2009	HVAC HEATING HOT WATER PIPING SCHEMATIC
S10	0	15030885	10/29/2009	BLAST RESISTANT DETAILS	M-06.1	0	15030941	10/29/2009	HVAC CHILLED WATER PIPING SCHEMATIC
A-01	0	15030888	10/29/2009	SITE PLAN	M-07	0	15030942	10/29/2009	HVAC CONTROL SCHEMATICS
A-02	0	15030889	10/29/2009	FLOOR PLAN	M-08	0	15030943	10/29/2009	HVAC DETAILS - SHEET 1 OF 2
A-02.1	0	15030890	10/29/2009	PARTIAL FLOOR PLAN	M-08.1	0	15030944	10/29/2009	HVAC DETAILS - SHEET 2 OF 2
A-02.2	0	15030891	10/29/2009	PARTIAL FLOOR PLAN	P-01	0	15030951	10/29/2009	PLUMBING NOTE AND SCHEDULES
A-02.3	0	15030892	10/29/2009	PARTIAL FLOOR PLAN	P-02	1	15030948	10/29/2009	UNDERGROUND PLUMBING FLOOR PLAN
A-02.4	0	15030893	10/29/2009	PARTIAL FLOOR PLAN	P-02.1	0	15030952	10/29/2009	PLUMBING FLOOR PLAN - SHEET 1 OF 2
A-03	0	15030894	10/29/2009	FLOOR PLAN AT MEZZANINE LEVEL	P-03	0	15030953	10/29/2009	PLUMBING FLOOR PLAN - SHEET 2 OF 2
A-03.1	0	15030895	10/29/2009	FLOOR PLAN AT ATTIC	P-04	0	15030951	10/29/2009	UNDERGROUND WASTE AND VENT RISER DIAGRAMS
A-04	0	15030896	10/29/2009	EXTERIOR ELEVATIONS	P-04.1	0	15030954	10/29/2009	PLUMBING WASTE AND VENT RISER DIAGRAM
A-05	0	15030897	10/29/2009	EXTERIOR ELEVATIONS	P-05	0	15030952	10/29/2009	UNDERGROUND PLUMBING WATER RISER DIAGRAM
A-06	0	15030898	10/29/2009	BUILDING SECTIONS	P-05.1	0	15030955	10/29/2009	PLUMBING WATER RISER DIAGRAM
A-07	0	15030899	10/29/2009	BUILDING SECTIONS	P-06	1	15030955	10/29/2009	UNDERGROUND PLUMBING DETAILS
A-08	0	15030900	10/29/2009	BUILDING SECTIONS	P-06.1	0	15030956	10/29/2009	PLUMBING DETAILS - SHEET 1 OF 2
A-09	0	15030901	10/29/2009	ROOM FINISH SCHEDULE	P-06.2	0	15030957	10/29/2009	PLUMBING DETAILS - SHEET 2 OF 2
A-09.1	-	-	-	NOT USED	E-1.0	0	15030961	10/29/2009	ELECTRICAL SYMBOL, LEGEND & NOTES
A-10	0	15030903	10/29/2009	ROOF PLAN	E-2.0	0	15030962	10/29/2009	ELECTRICAL SITE PLAN
A-11	0	15030904	10/29/2009	WALL SECTIONS	E-3.0	0	15030963	10/29/2009	LIGHTING PLAN - FIRST FLOOR
A-11.1	0	15030905	10/29/2009	WALL SECTIONS	E-3.1	0	15030964	10/29/2009	LIGHTING PLAN - MEZZANINE
A-11.2	0	15030906	10/29/2009	WALL SECTIONS	E-4.0	0	15030965	10/29/2009	POWER PLAN - FIRST FLOOR
A-11.3	0	15030907	10/29/2009	WALL SECTIONS	E-4.1	0	15030966	10/29/2009	POWER PLAN - MEZZANINE
A-12	0	15030908	10/29/2009	REFLECTED CEILING PLAN	E-5.0	0	15030967	10/29/2009	SPECIAL SYSTEM PLAN - FIRST FLOOR
A-13	0	15030909	10/29/2009	ENLARGED TOILET PLAN, ACCESSORIES SCHEDULE	E-5.1	0	15030968	10/29/2009	SPECIAL SYSTEM PLAN - MEZZANINE
A-13.1	0	15030910	10/29/2009	INTERIOR ELEVATIONS	E-6.0	0	15030969	10/29/2009	MECHANICAL POWER PLAN - FIRST FLOOR
A-14	0	15030911	10/29/2009	DOOR SCHEDULE AND ELEVATIONS	E-6.1	0	15030970	10/29/2009	MECHANICAL POWER PLAN - MEZZANINE
A-14.1	0	15030912	10/29/2009	DOOR DETAILS	E-7.0	0	15030971	10/29/2009	ELECTRICAL DETAILS
A-14.2	0	15030913	10/29/2009	DOOR DETAILS	E-8.0	0	15030972	10/29/2009	ELECTRICAL PANEL SCHEDULES
A-15	0	15030914	10/29/2009	WINDOW SCHEDULE, ELEVATION AND DETAILS	E-8.1	0	15030973	10/29/2009	ELECTRICAL PANEL SCHEDULES
LS-01	0	15030918	10/29/2009	LIFE SAFETY PLAN	E-9.0	0	15030974	10/29/2009	ELECTRICAL RISER DIAGRAM
					E-9.1	0	15030975	10/29/2009	ELECTRICAL GROUNDING DIAGRAM
					E-10	0	15030976	10/29/2009	ELECTRICAL SLAB ROUGH-IN - FIRST FLOOR

**BROADMOOR**  
BUILDING by DESIGN  
BROADMOOR, L.L.C.  
2740 North Acme Road  
Metairie, Louisiana 70002  
www.broadmoorllc.com

REV.	DESCRIPTION	DATE	BY	APP'D.
0	FINAL DESIGN	10/29/09		

NLS JRB New Orleans  
Belle Chasse, Louisiana  
**NAVAIRSEFAC CALIBRATION BLDG.**  
TITLE SHEET, VICINITY MAP  
DRAWING INDEX  
DATE: AUGUST 22, 2008  
ETD FOR COMMANDER, NAVFAC



RECORD DRAWING DATE: 05/27/09  
CODE I.D. NO.: -  
DRAWING SIZE: D  
SPEC. NO. 06- -  
CONSTR. CONTR. NO. -

NAVFAC DRAWING NO. 15030863  
SHEET 1 OF 1  
T-01

WALDEMAR S. NELSON AND COMPANY  
ENGINEERS AND ARCHITECTS  
1200 ST. CHARLES AVE. NEW ORLEANS, LA.