
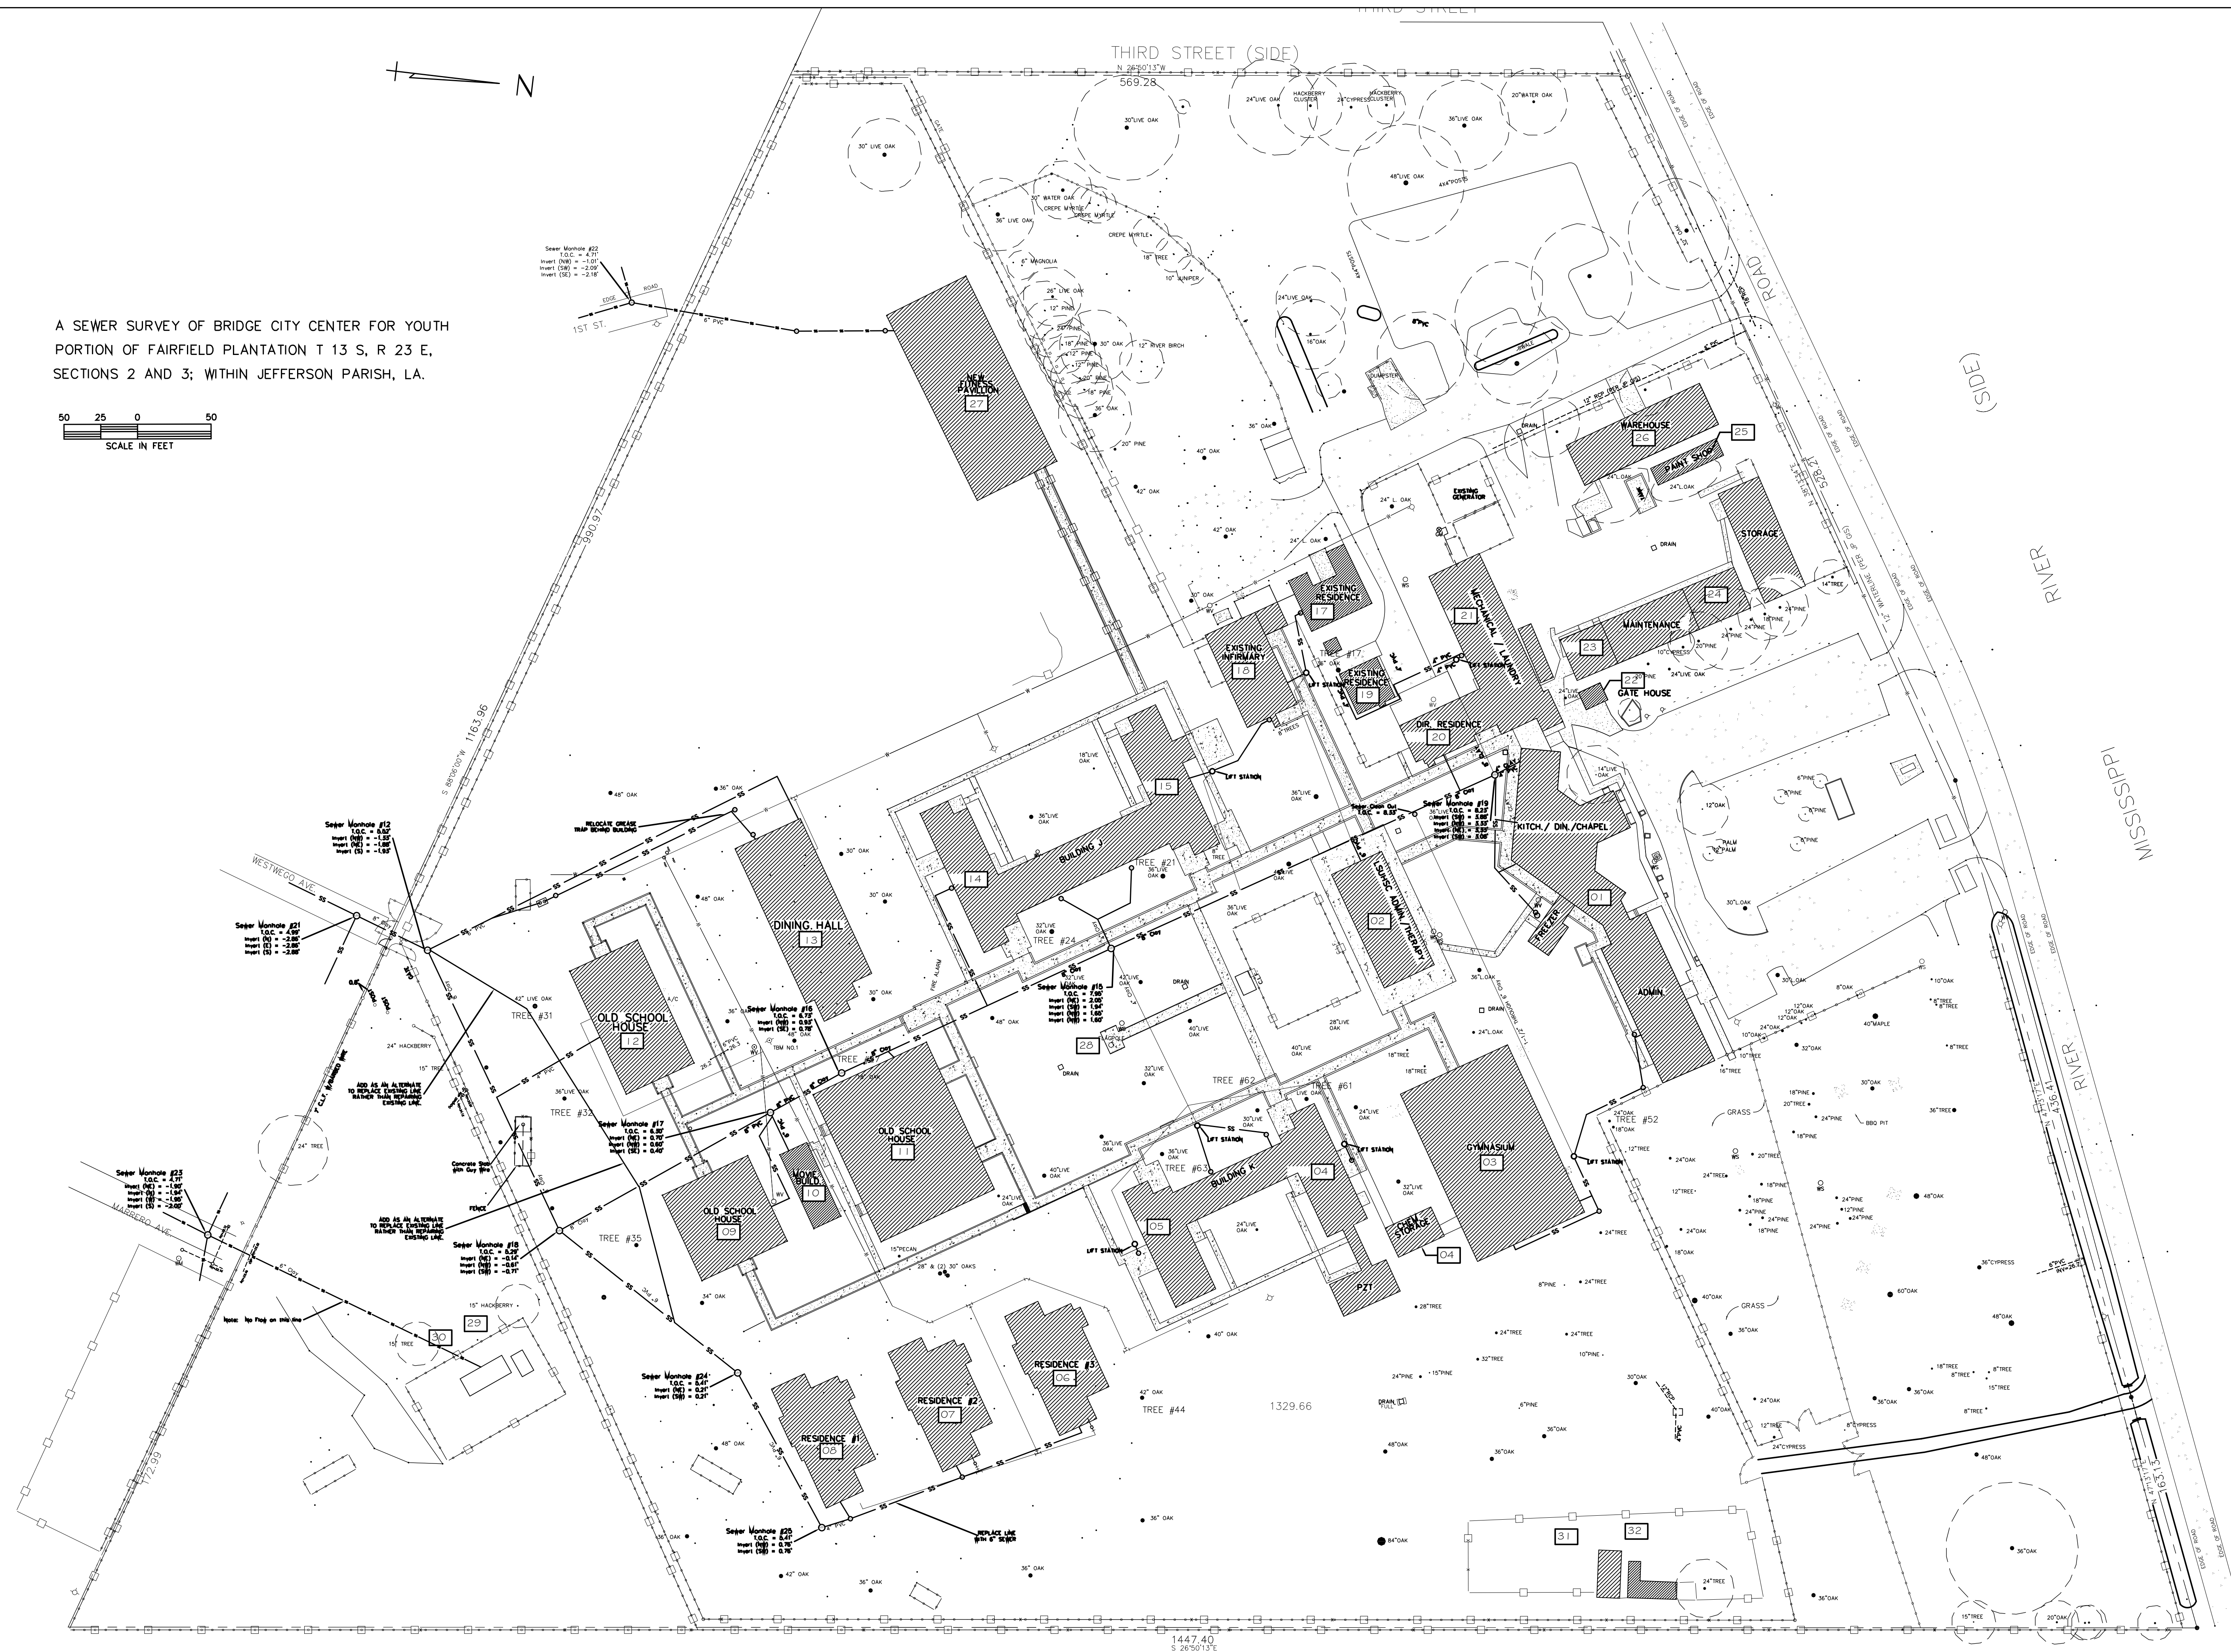


A SEWER SURVEY OF BRIDGE CITY CENTER FOR YOUTH
 PORTION OF FAIRFIELD PLANTATION T 13 S, R 23 E,
 SECTIONS 2 AND 3; WITHIN JEFFERSON PARISH, LA.

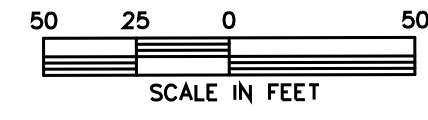

SEWER SYSTEM RENOVATION
 BRIDGE CITY CENTER FOR YOUTH
 PROJ. NO. 05-403-11-01 PART 1
 32.25 RIVER ROAD
 BRIDGE CITY, LA 70094

#	DESCRIPTION	DATE

JOB No: 2156 DATE: 2/14/2014
 DRAWN BY: DFD CHECKED BY: BM

SITE PLAN

SHEET No:
C-1

DAMMON
 ENGINEERING, INC.
Architects & Engineers

CHIEF ENGINEER: RICHIE DAMMON, P.E.
 PROJECT MANAGER: JEFFREY WITSE
 554 OLD SPANISH TRAIL
 SUITE 101, LA 70456
 PHONE: 985-649-5032
 FAX: 985-641-9990