



**CONDUIT DOOR LAYOUT SINGLE DOOR MAG LOCK**

ACCESS CONTROL DOUBLE DOOR WITH CARD READER, MAGNETIC LOCK, REX, JUNCTION BOX, DOOR CONTACT

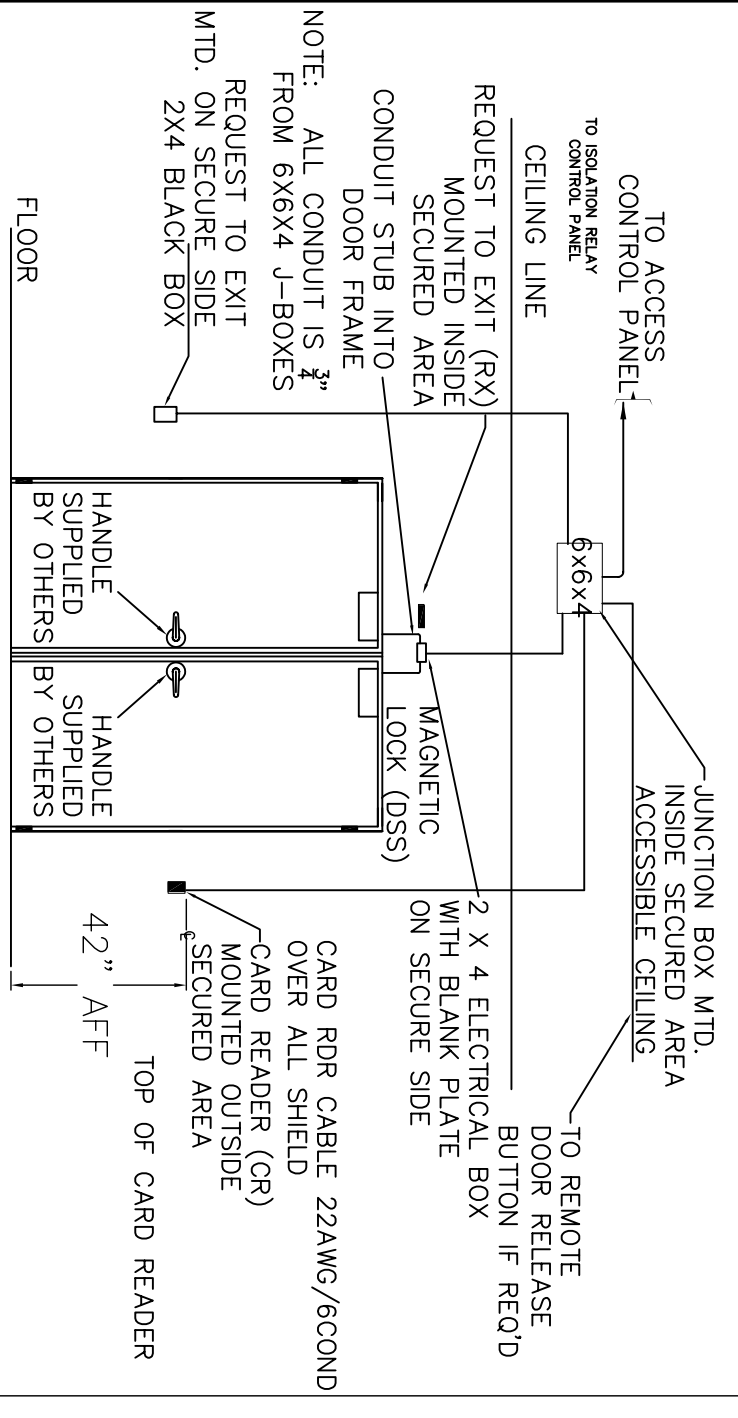


**CONDUIT DOOR LAYOUT DOUBLE DOOR MAG LOCK**

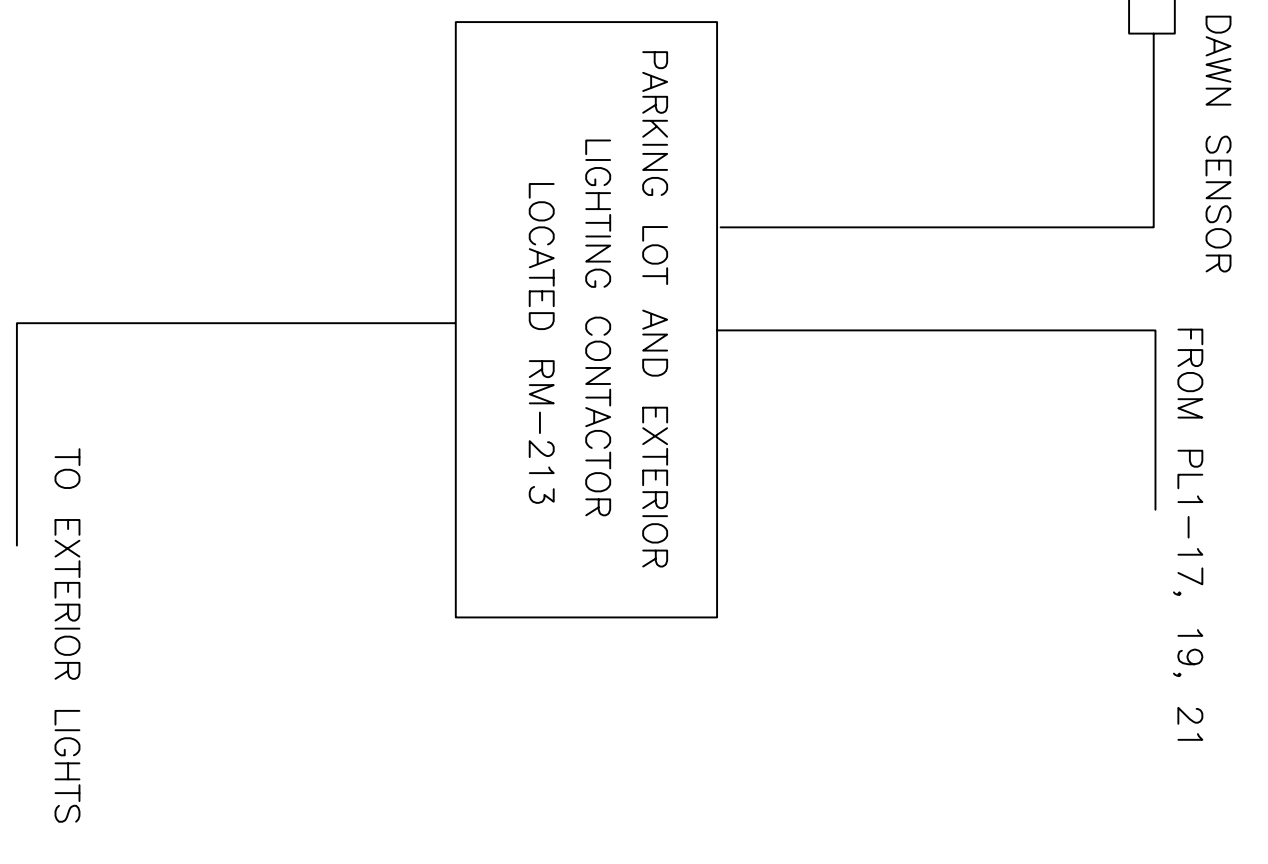

- LEGEND**
- ⊕ NEW DUPLEX RECEPTACLE
  - ⊙ EXHAUST FAN
  - ▲ SECURITY ACCESS DOOR (SCANNER BY OTHERS)
  - ⊙ COLUMN MOUNTED UTILITIES
  - ⊙ JUNCTION BOX

**NOTE**

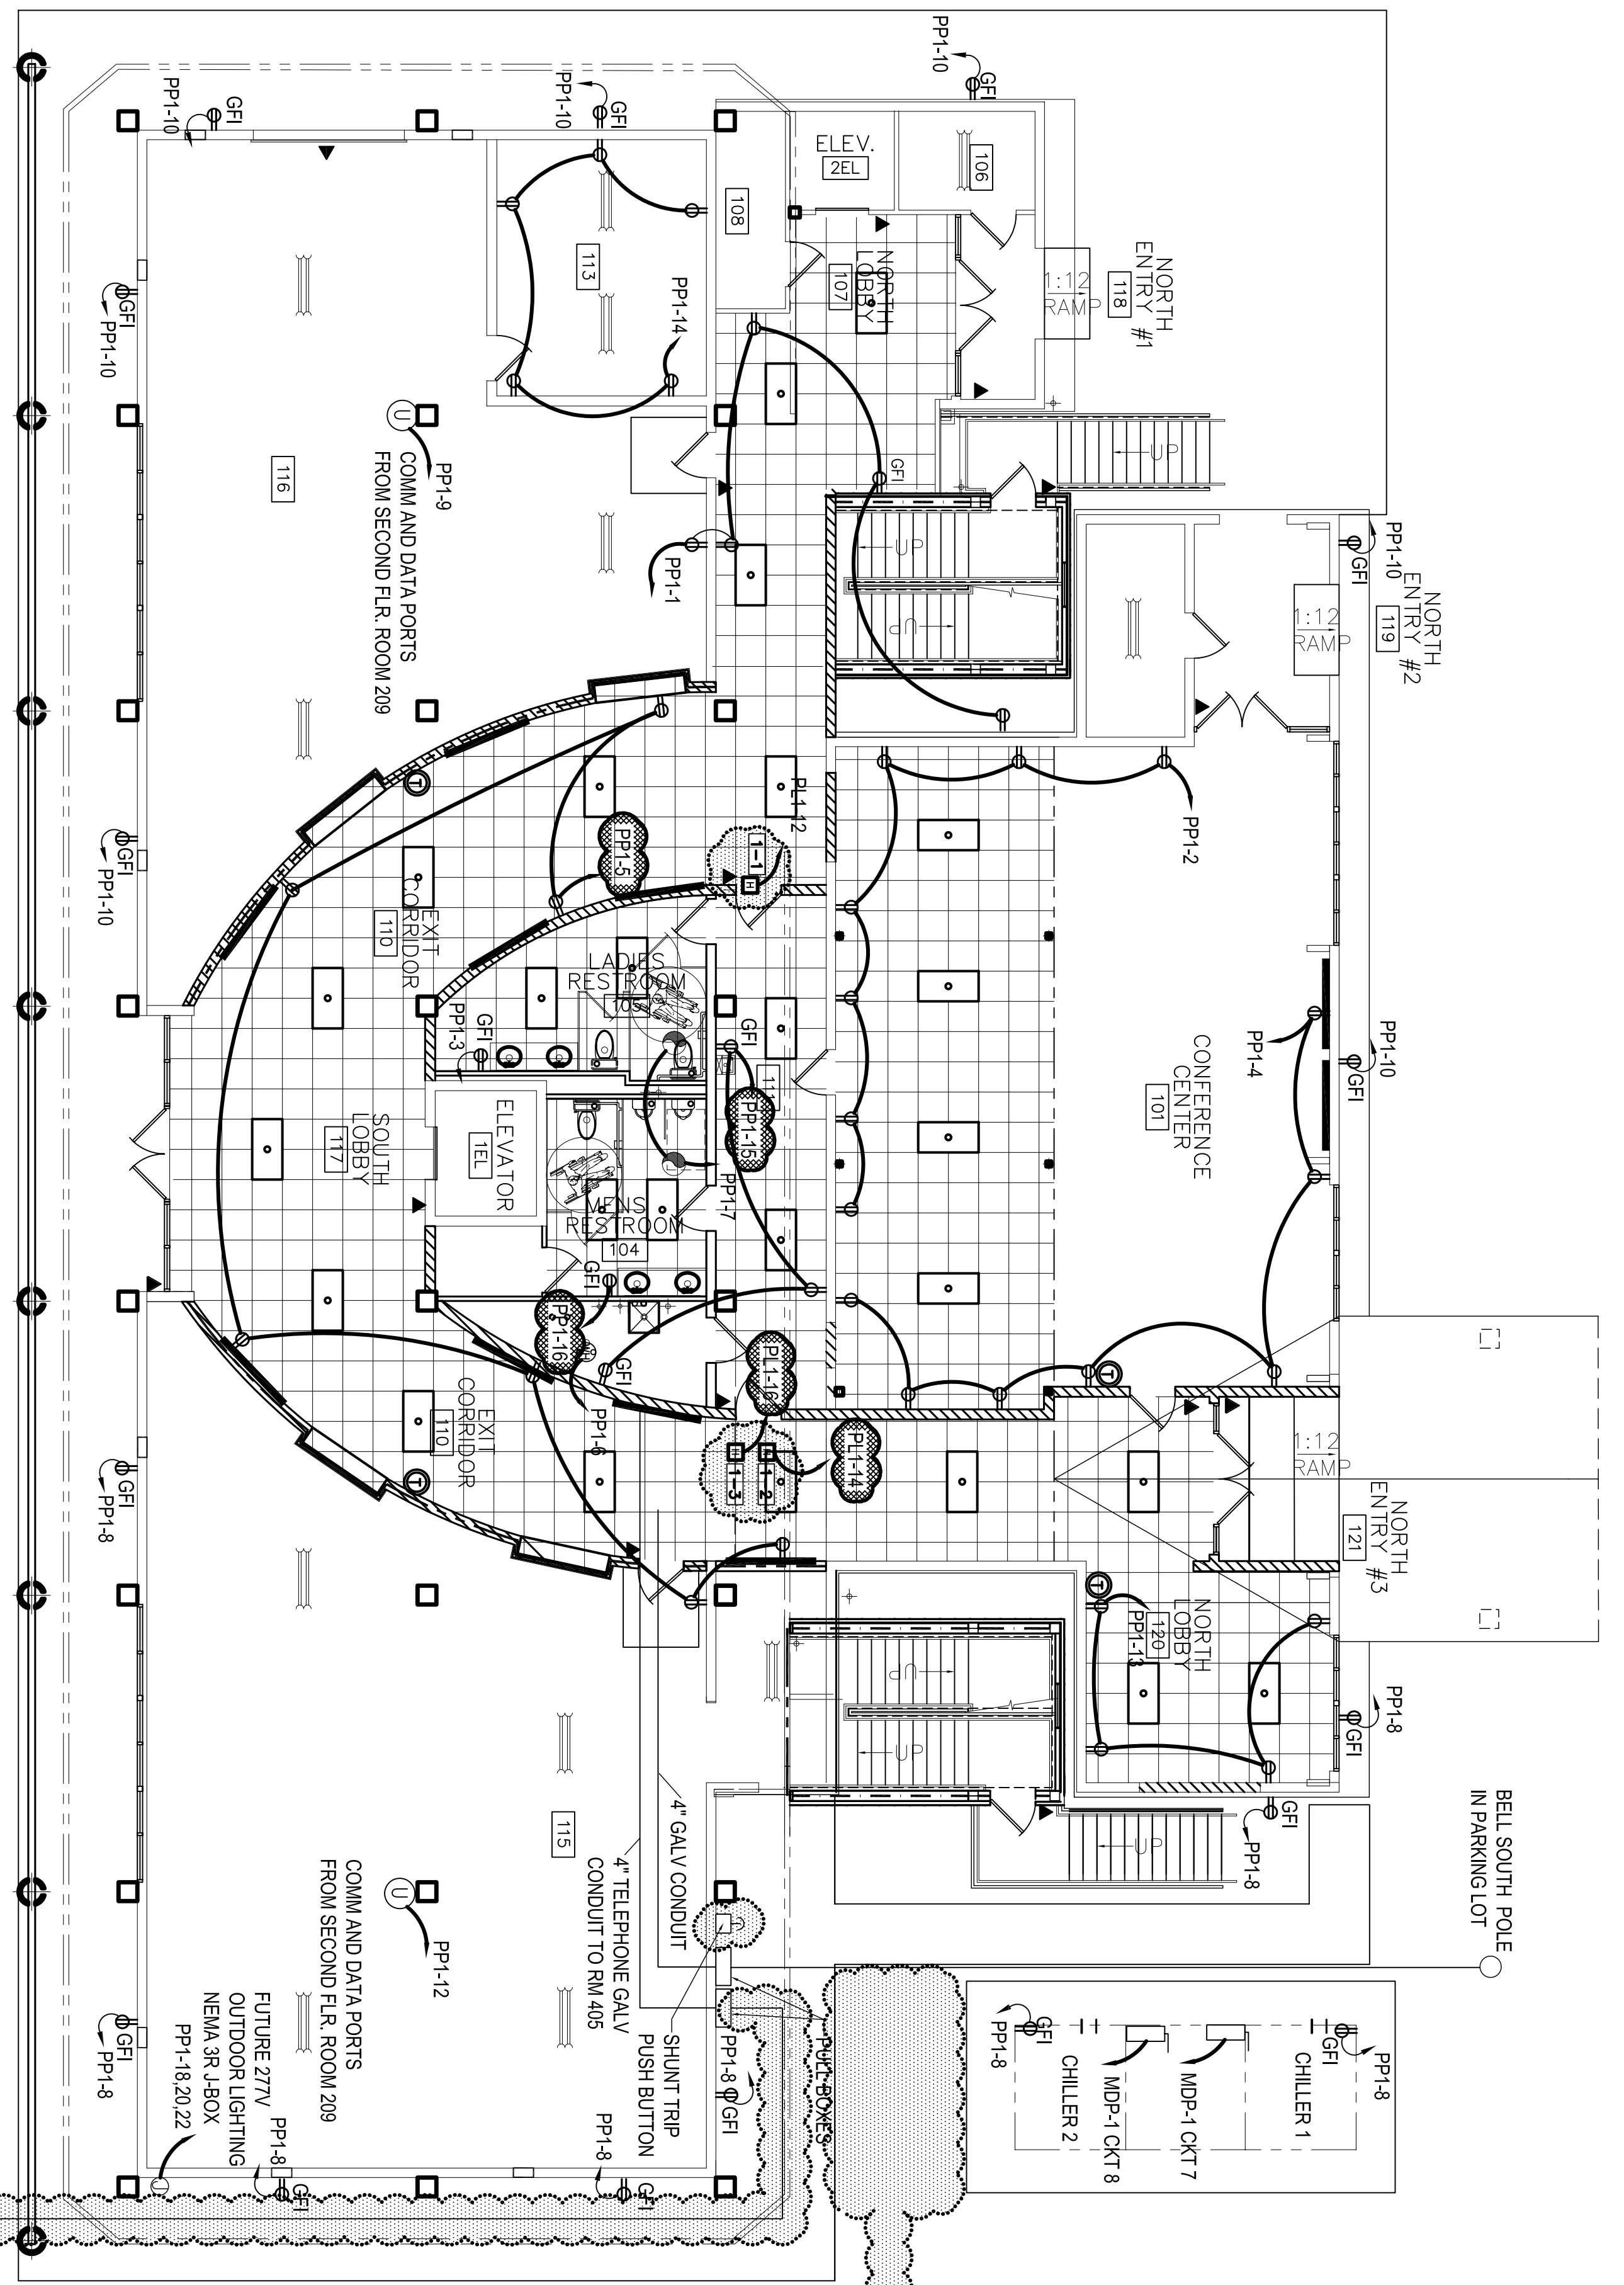

**FIRST FLOOR POWER PLAN**  
SCALE: 1/8" = 1'-0"

INDICATES ITEMS CHANGED - 06/27/08

INDICATES ITEMS CHANGED - 05/29/08

REVISSED: 06/27/08 ab  
STAR HVAC REVISED: 05/29/08 ab  
ELECT XFRM 02/07/08 KD  
HVAC CHANGES: 11/05/07 ab

RFP #2 11-13-07

**1ST FLOOR POWER PLAN**  
ST. TAMMANY PARISH ADMIN. COMPLEX  
OLD SPANISH TRAIL  
SLIDELL, LOUISIANA

RENOVATE OFFICE BUILDING

**DAMMON ENGINEERING, INC.**

1095 FLORIDA AVENUE 985-649-5832 SLIDELL, LA. 70458  
DAMMONENGINEERING.COM

SHEET **E1P** OF

SCALE: AS NOTED

FILE:

JOB NO. 1729

DATE: 1-8-07