


REVDATE: FILE NAME: C:\Scholarly ENGR\09010 SOF Riveline\Drawings\Elec\5-As-Built\Layout\FA1.4-1.5 as-built.dwg LAYOUT NAME: FA1.4 PLOTTED: Wednesday, June 09, 2010 - 1:08pm

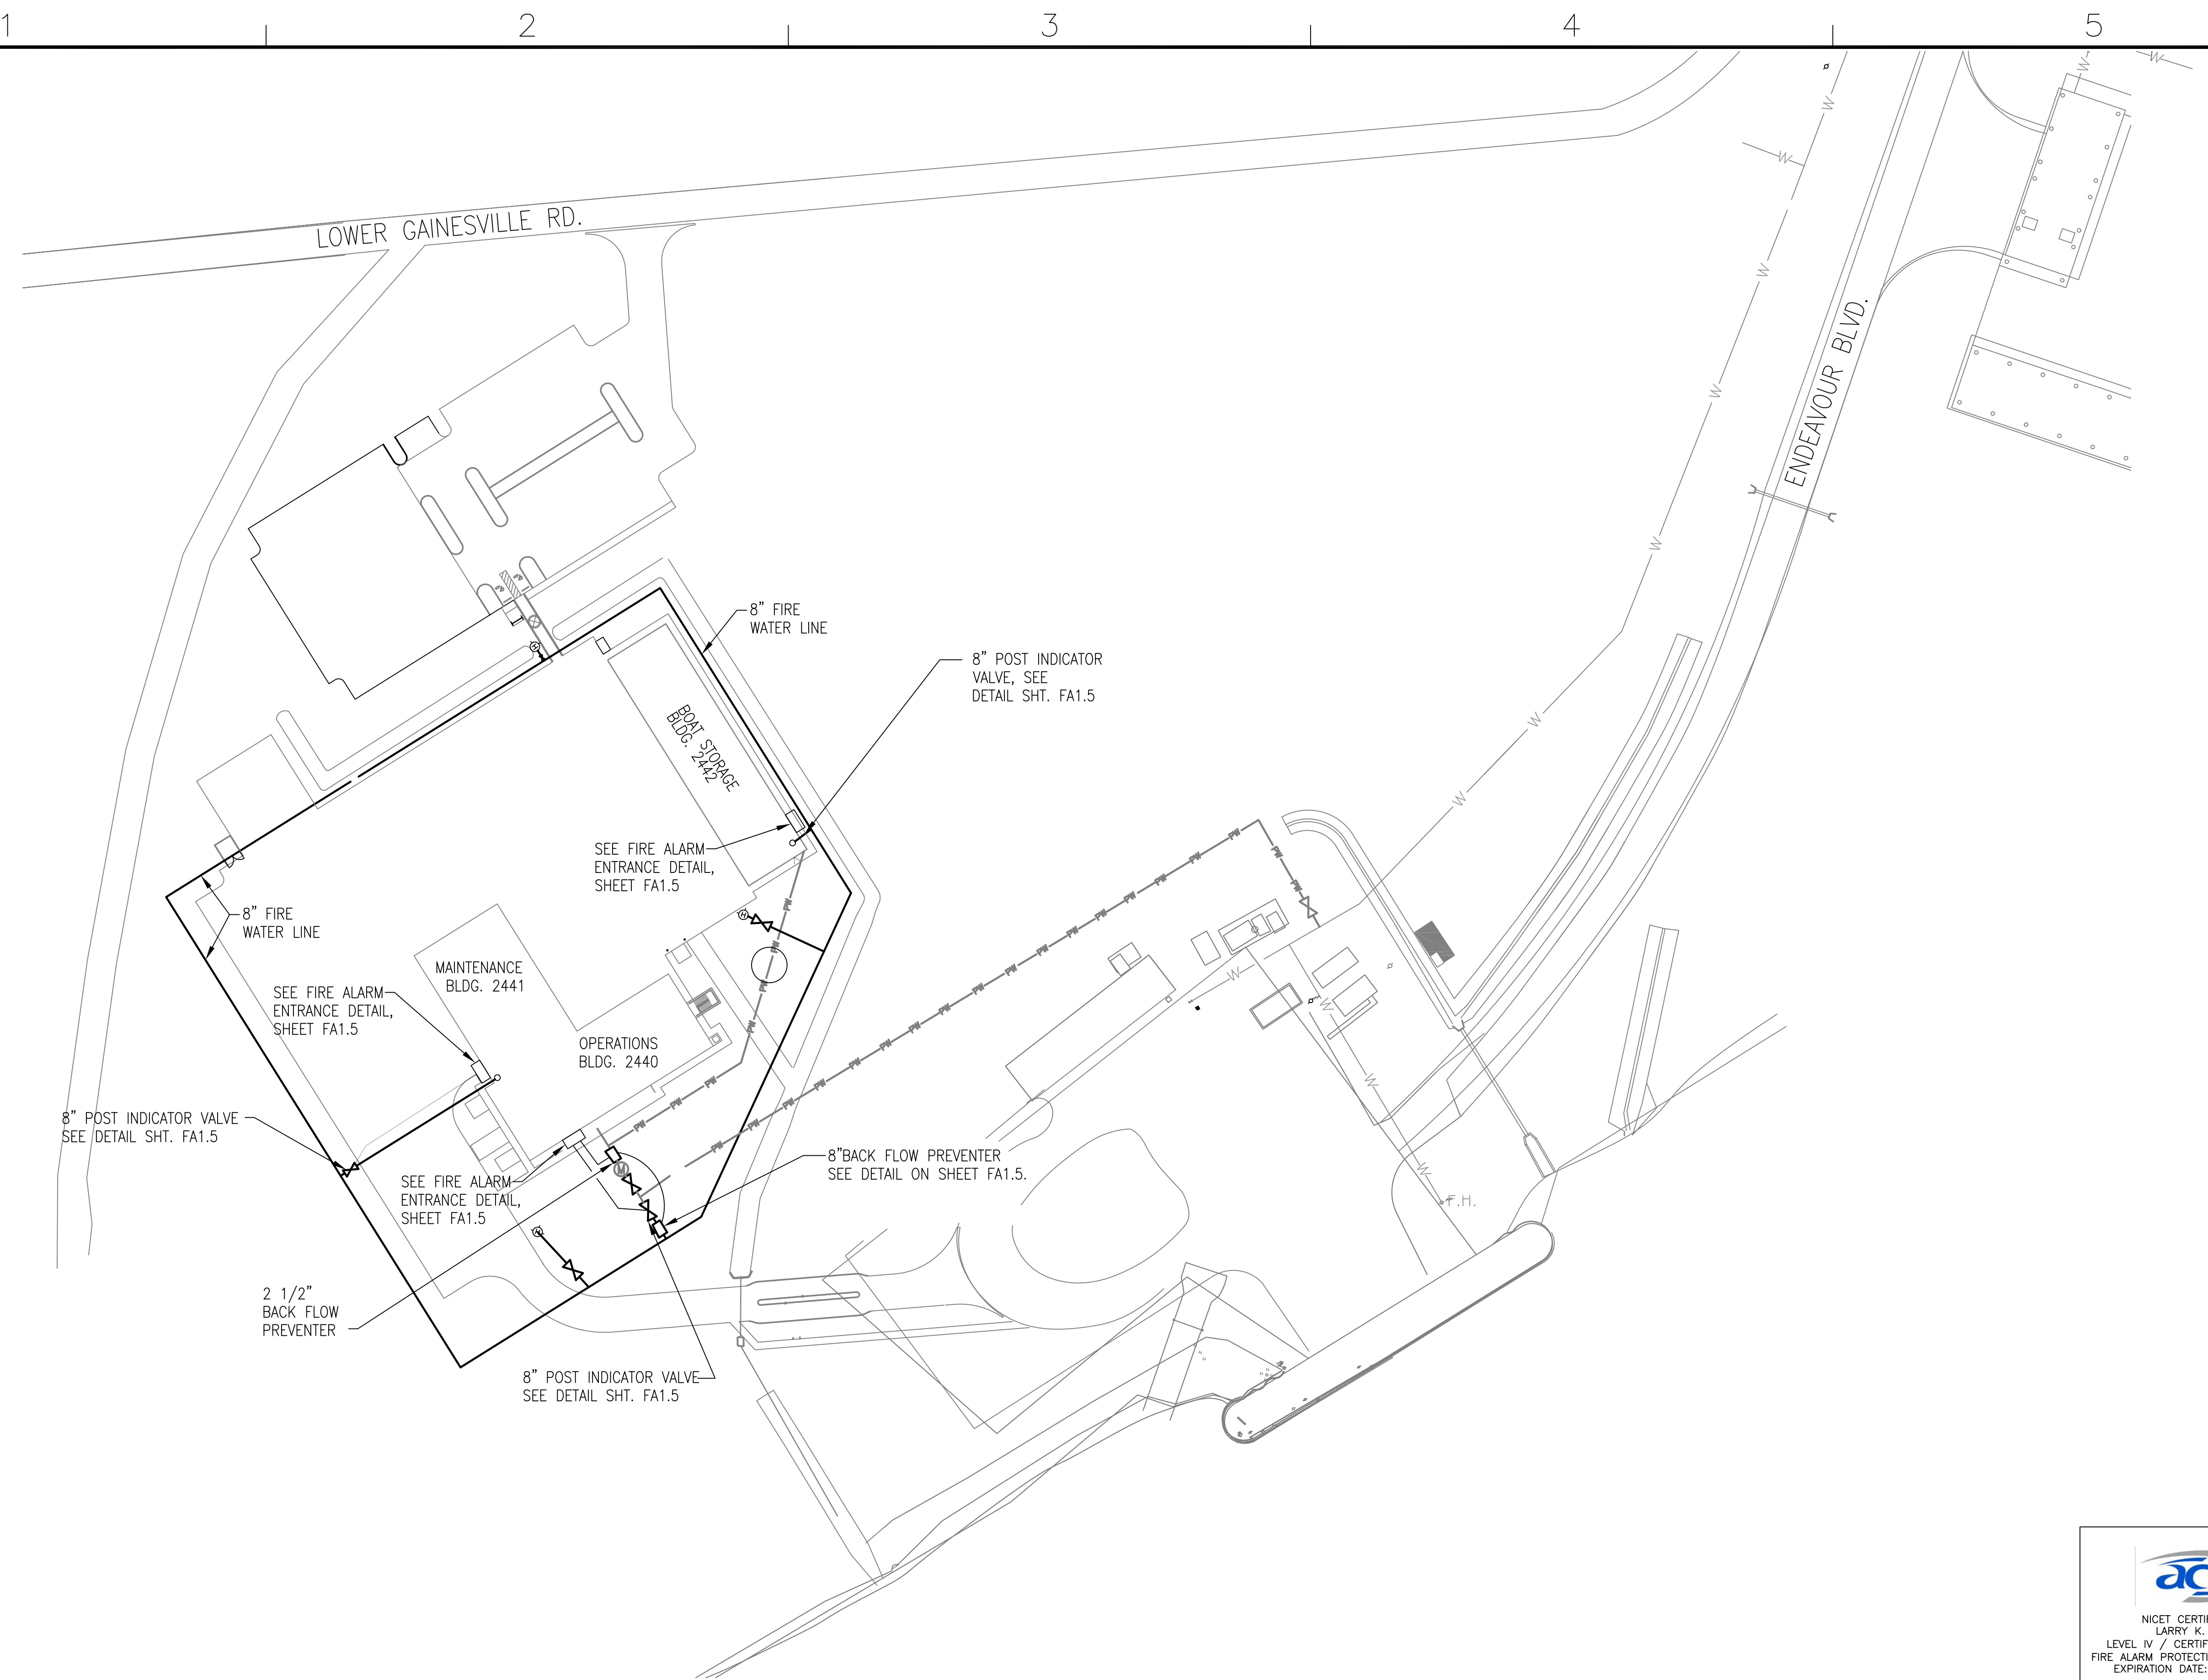


NOTE: FIELD VERIFY LOCATION OF ALL SUPERVISORY AND TAMPER SWITCHES.

**2** FIRE ALARM SYSTEM SITE PLAN  
 FA1.4  
 SCALE: NOT TO SCALE



**AS-BUILT**  
6-4-2010

REVISED PER URS AND NAVFAC COMMENTS		2/26/2010	DATE
SYMBOL	DESCRIPTION		APPR
 <b>NAVFAC</b>			
DEPARTMENT OF THE NAVY NAVAL FACILITIES ENGINEERING COMMAND SOUTHEAST NAVAL AIR STATION JACKSONVILLE FLPT SOUTH ATLANTIC JOHN C. STENNIS SPACE CENTER MISSISSIPPI <b>SOF RIVERINE AND COMBATANT CRAFT OPERATIONS FACILITY</b> <b>FIRE ALARM SITE PLAN</b>			
DESIGNER	DRW	SEAL	
REVIEWED BY: R. WILTSE			
PM/DM: T. ARTRIP			
CHIEF ENG/ARCH: P. DAMMON			
CODE ID. NO. N4412	SIZE D		
SCALE: 1/8"=1'-0"			
MAXIMO NO. #####			
STA. PROJ. NO. P-210			
WORK ORDER NO. 510247			
CONSTR. CONTR. NO. N62467-05-D-0096			
NAVFAC DRAWING NO. #####			
SHEET XXX OF XXX			
<b>FA1.4</b>			
DRAWFORM REVISION: 01 JAN 2009			