




Blitch Architects, Inc.
 757 St. Charles Avenue New Orleans, Louisiana 70130 (504) 524-4634
Brice-Morris Associates, Inc.
 230 South Tryon Street Charlotte, North Carolina 28202 (704) 334-7339
 A Joint Venture
 Architects

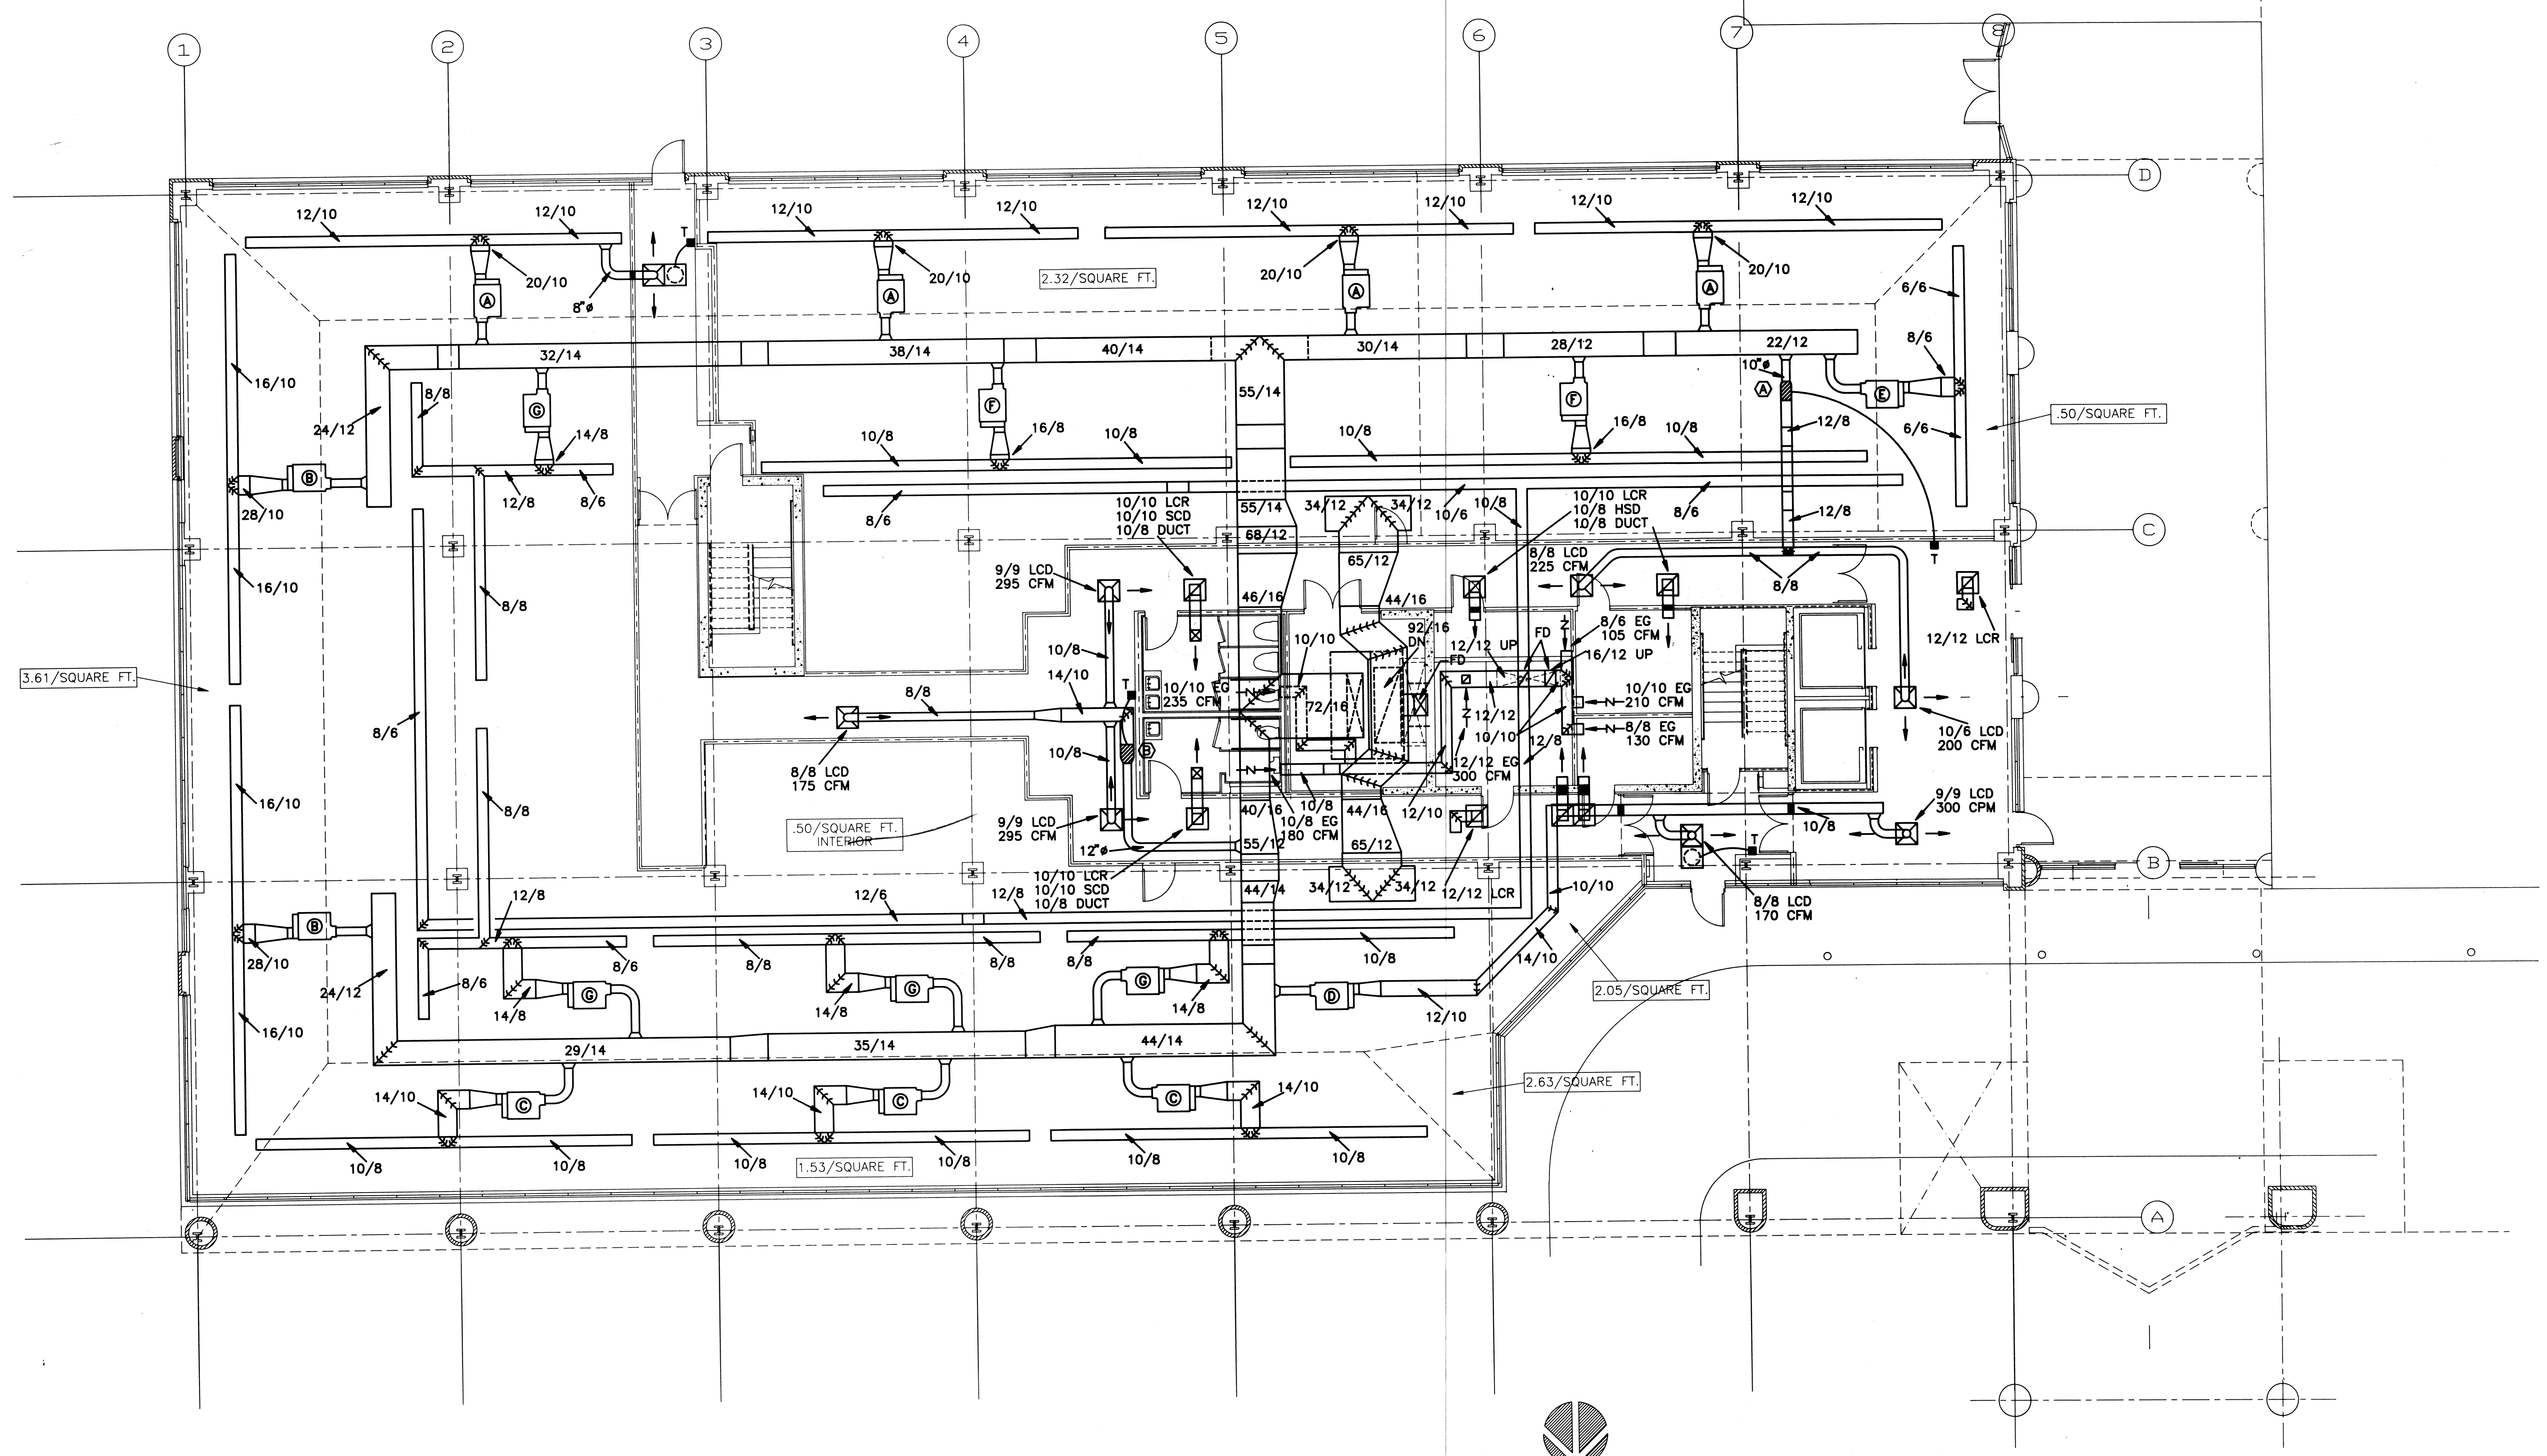

1
M1.1

FIRST FLOOR PLAN - HVAC

SCALE: 1/8" = 1'-0"

REVISION DATES	PROJECT ARCHITECT	DATE	FILE NO.
	JOB CAPTAIN	24 JAN 1991	9013J
	DRAWN BY		
	APPROVED		

MEDICAL OFFICE BUILDING AND PARKING DECK
SLIDELL MEMORIAL HOSPITAL — SLIDELL, LA
 First Floor HVAC Plan
 TITLE