
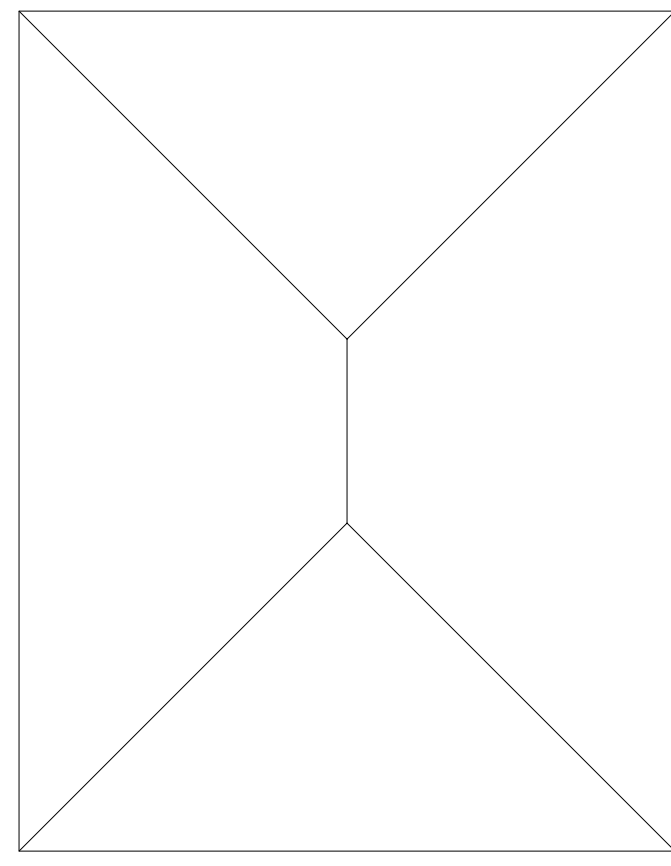


REFLECTED CEILING PLAN - LEVEL 3

SCALE: 1/8" = 1'-0"

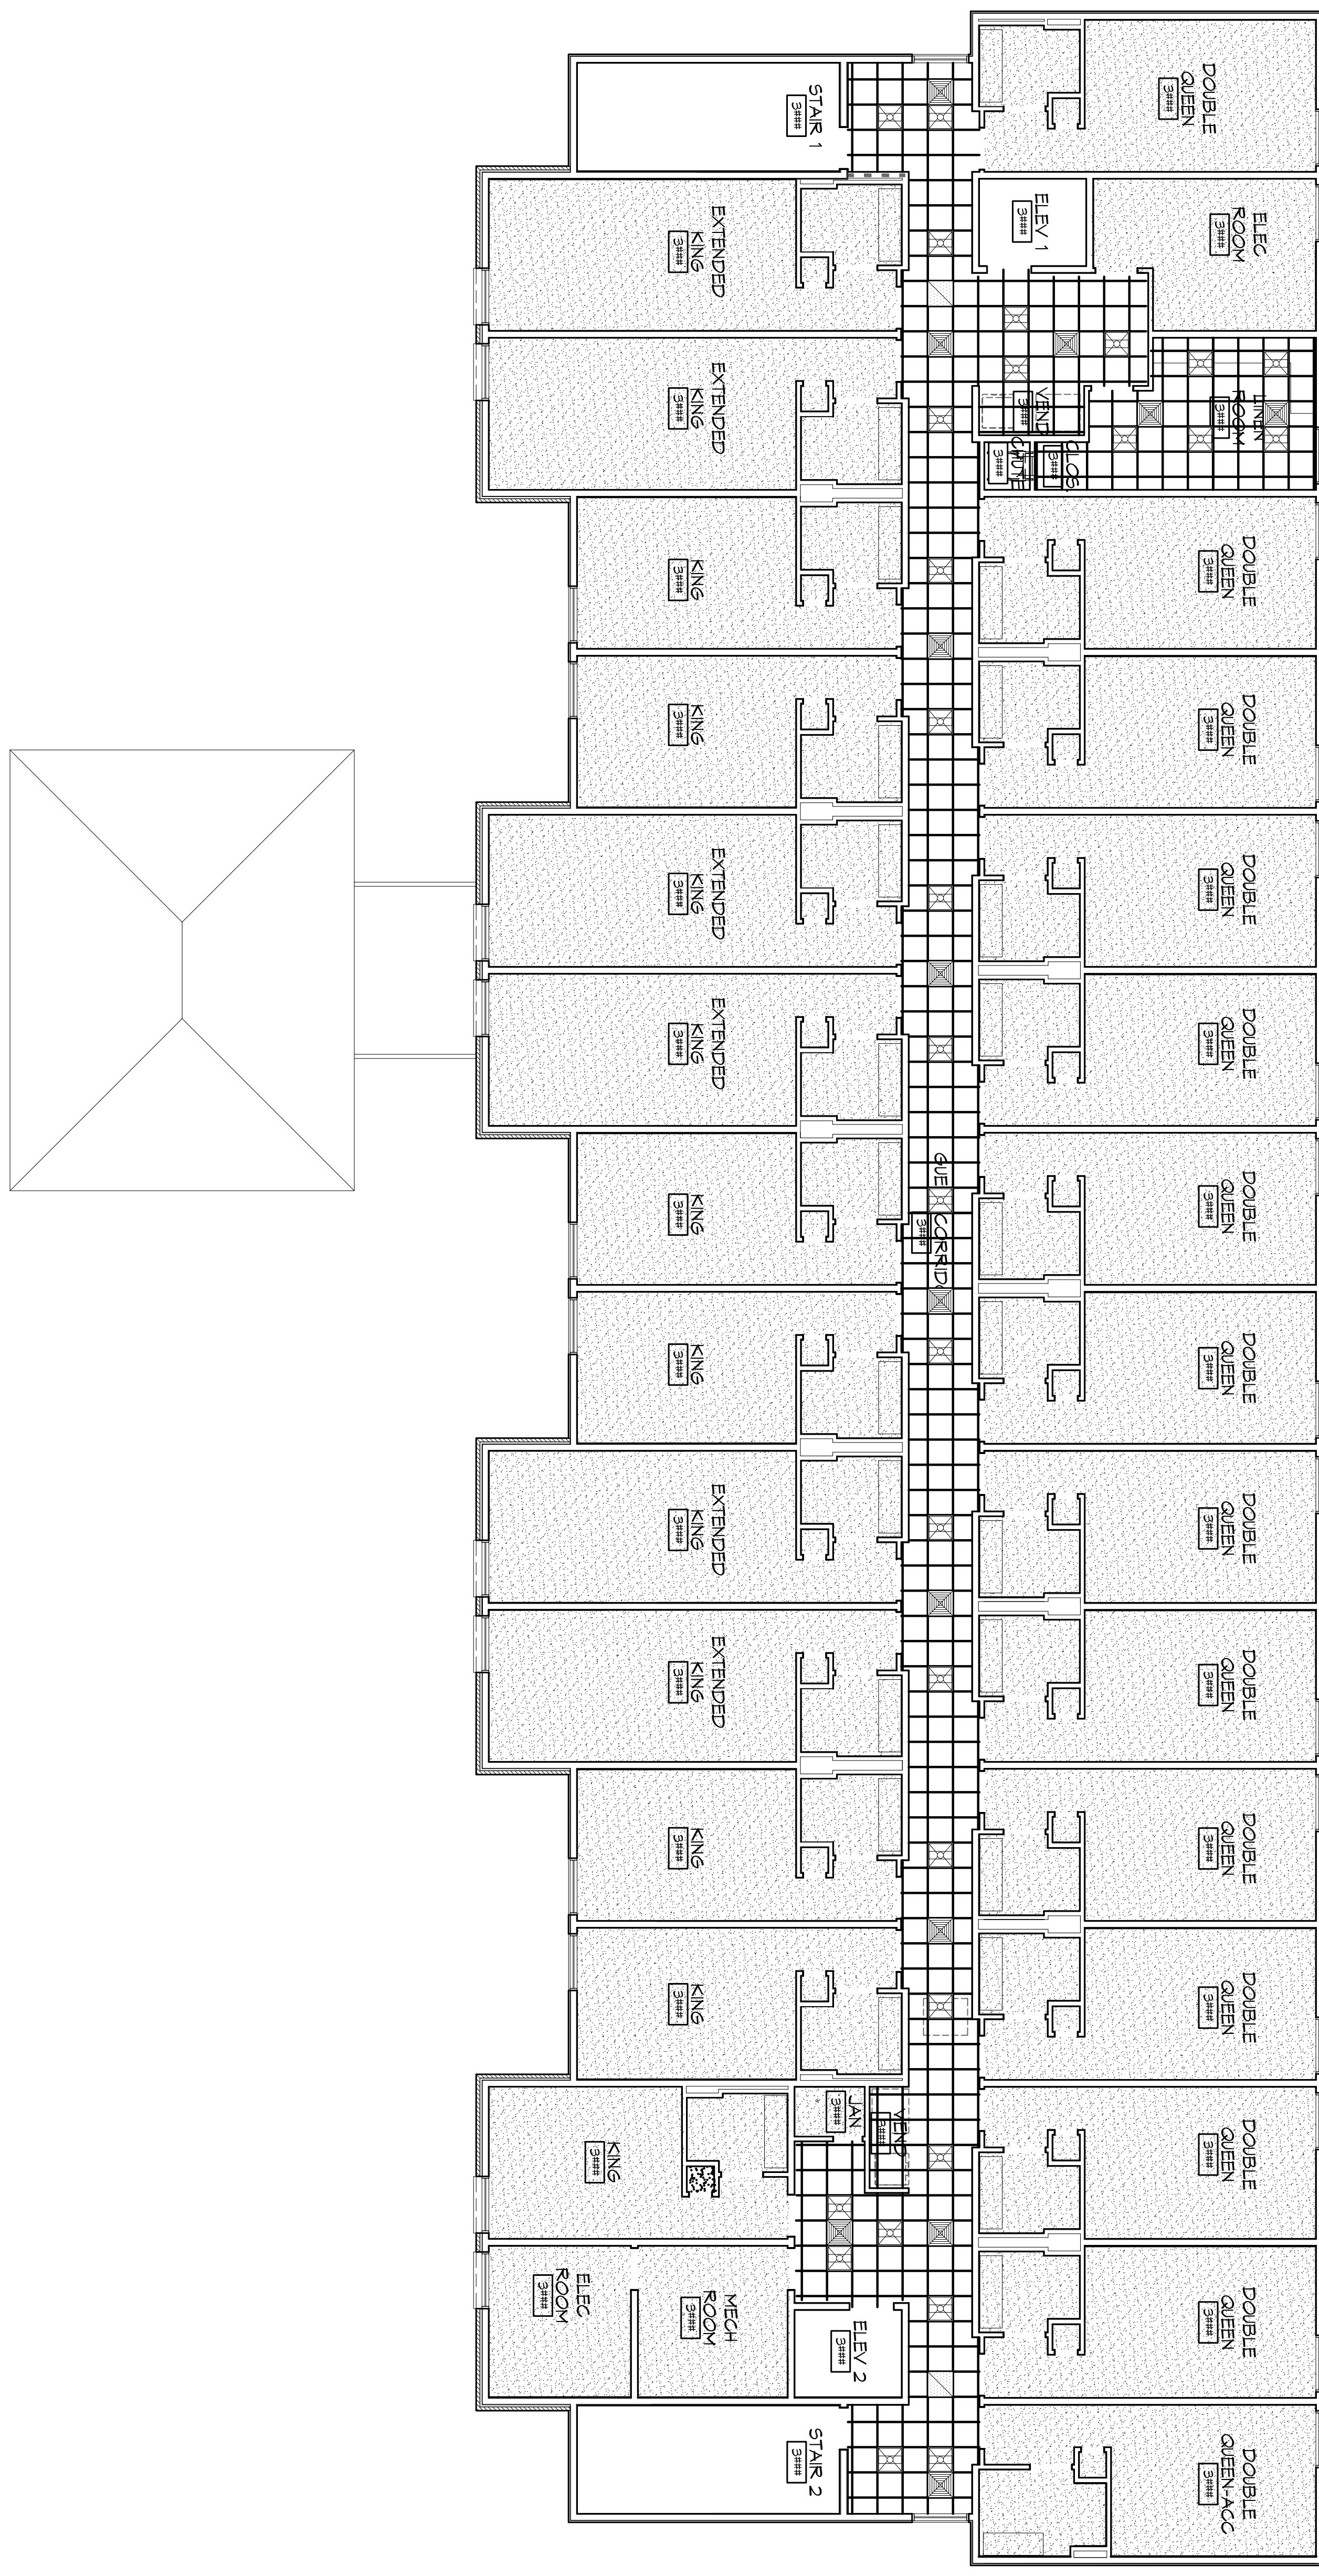

SHEET NO. **A107** VALUE OF \$

DRAWING NUMBER: **SPORTSMAN - LEVEL 3**

SPORTSMAN - LEVEL 3
 REFLECTED CEILING PLAN
 SHEET TITLE:
 LOT #1 LA HWY 27
 HACKBERRY, LA 70645
 JOB No: 2141 DATE: JUN 2015
 DRAWN BY: CKD/JTL CHECKED BY: KJK

**PRELIMINARY
 NOT FOR
 CONSTRUCTION**

#	DESCRIPTION	DATE

DAMMON ENGINEERING, INC.
Architects & Engineers
 Chief Architect: Kevin J. Kinchen, NCARB
 Chief Engineer: Brian Mistich, PE
 554 Old Spanish Trail
 Stidell, LA 70458
 www.dammonengineering.com
 info@dammonengineering.com
 PH: 985.649.5832
 F: 985.641.5950