



C:\Users\jmc\OneDrive\Documents\Projects\2023\051123\051123.dwg - Sheet 001 - 5/11/2023 10:11:33 AM

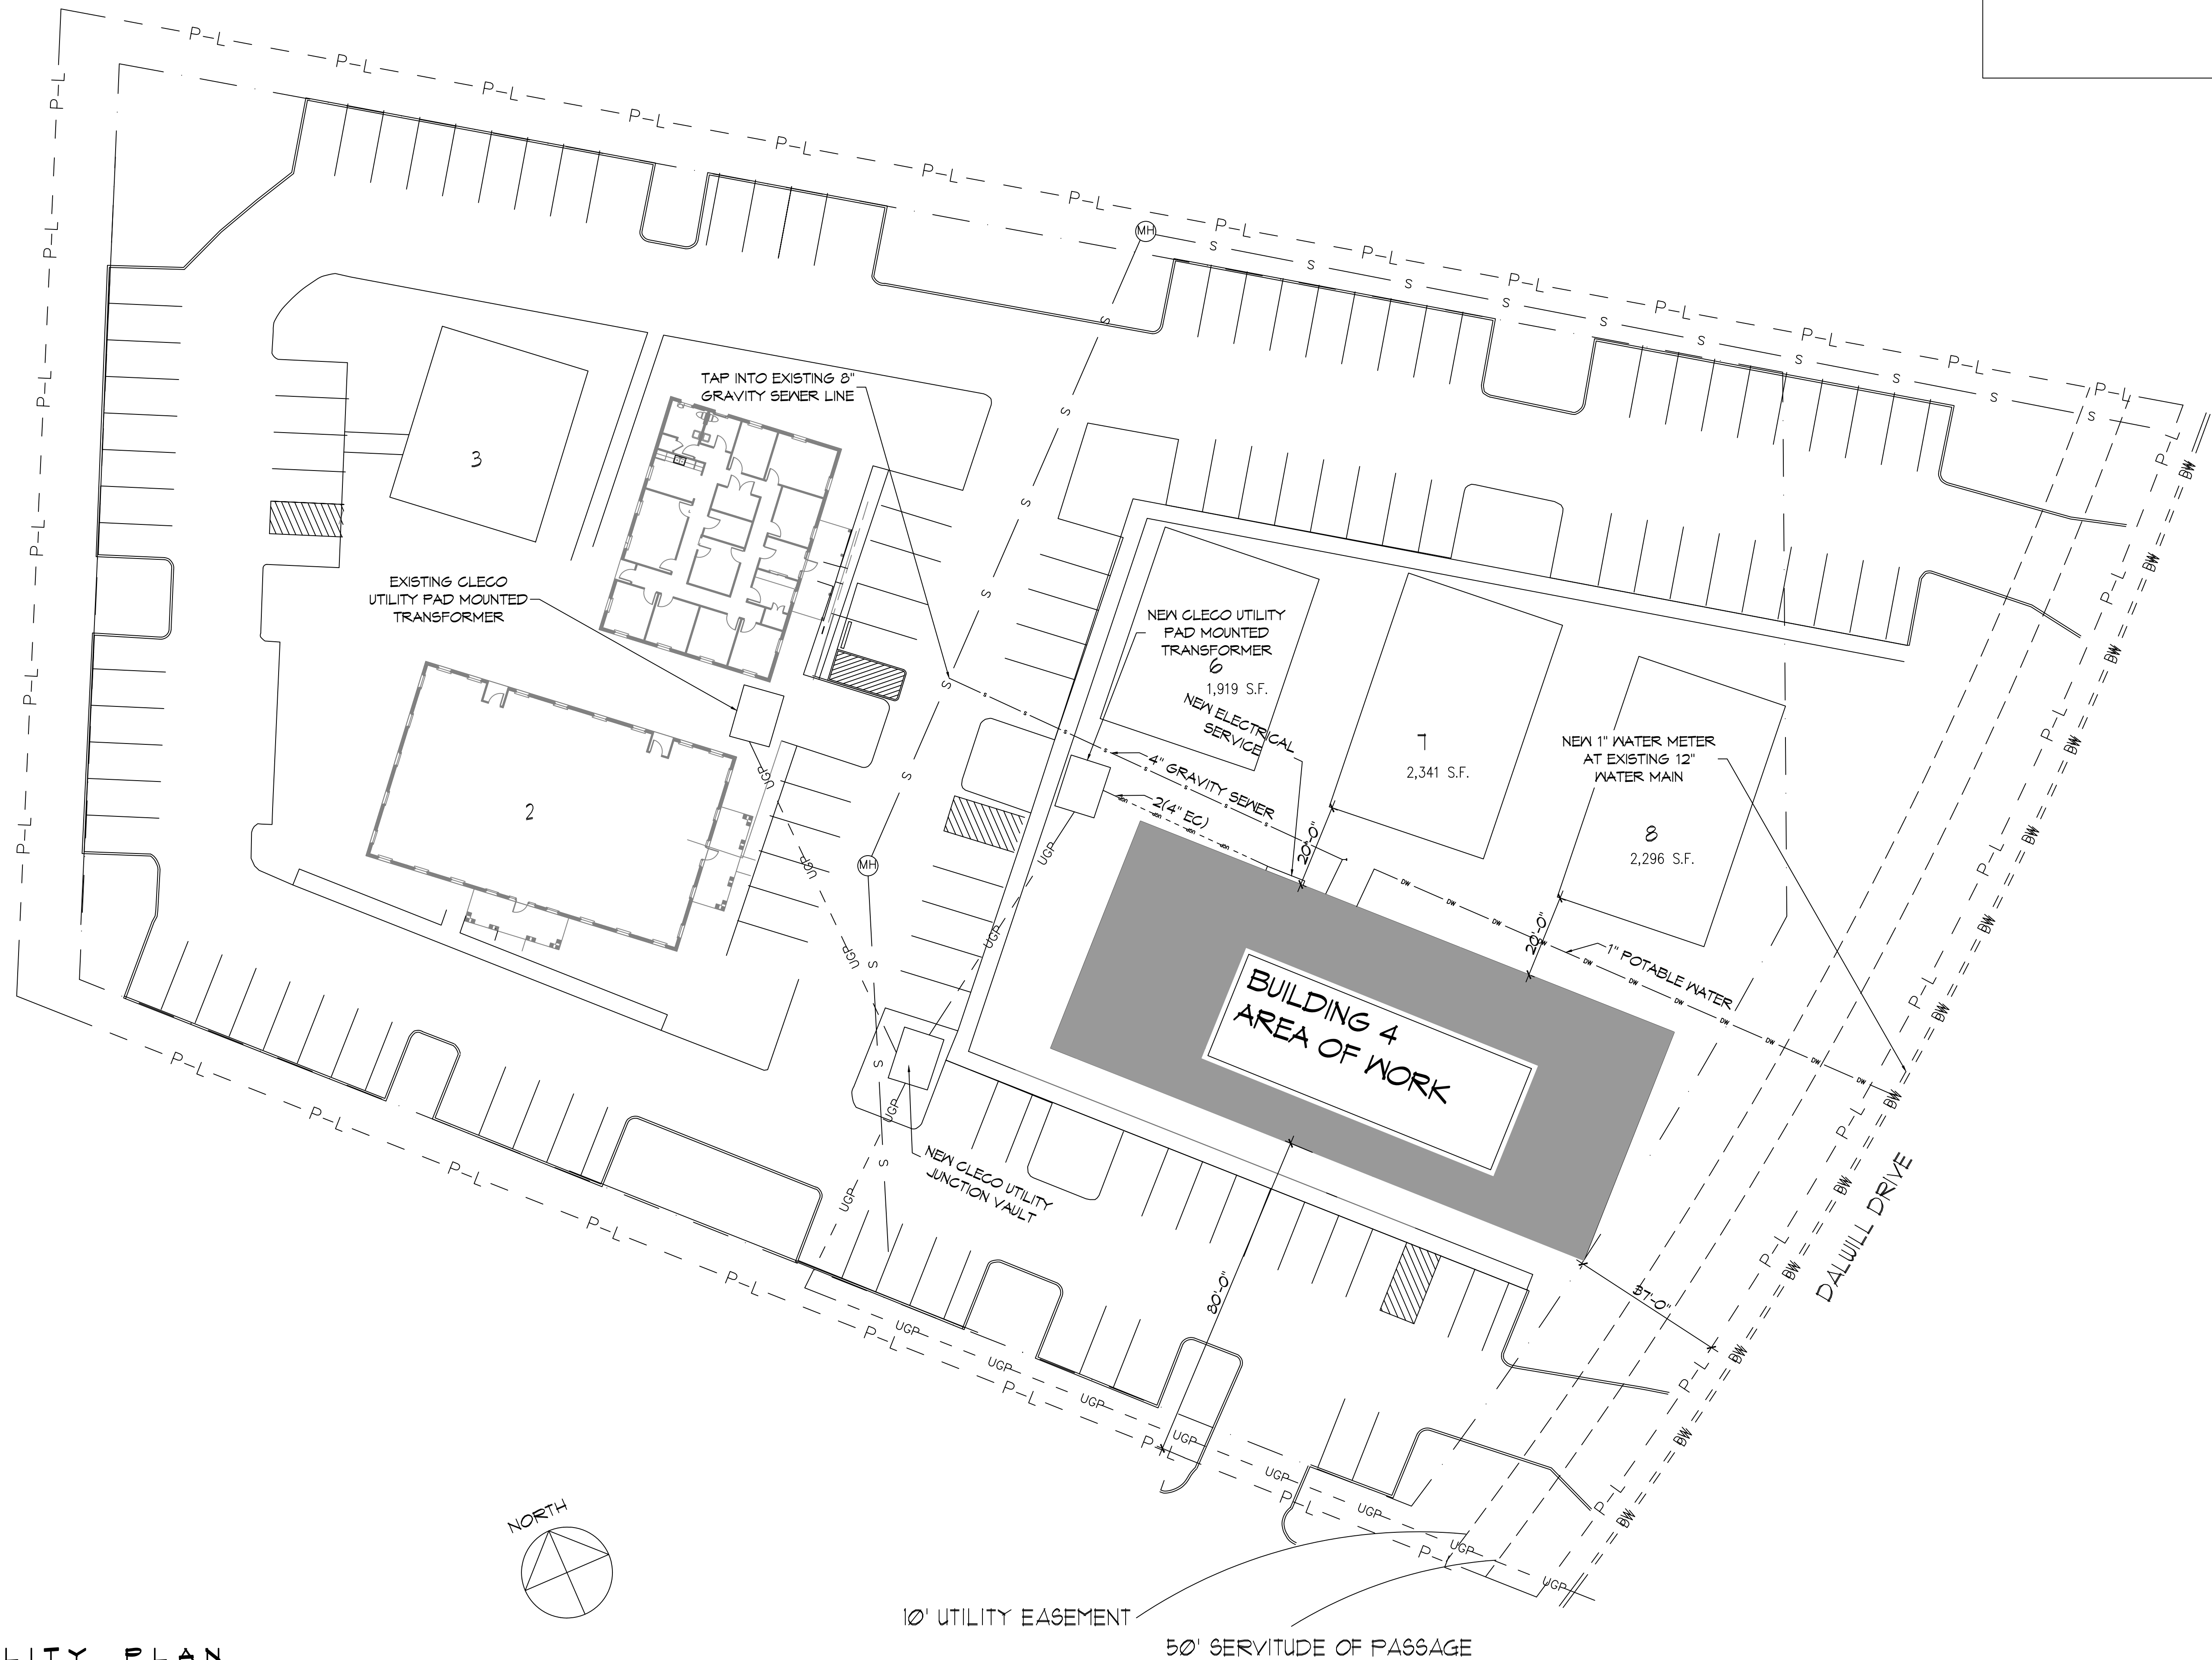

LEGEND	
---	UGP UNDERGROUND ELECTRICAL POWER CONDUIT(S).
—	DW UNDERGROUND DOMESTIC WATER PIPE(S).
- - -	S UNDERGROUND SANITARY SEWER GRAVITY PIPE(S).
- - -	P-L PROPERTY LINE

**1 SITE UTILITY PLAN**  
 SCALE: 1" = 20'-0"

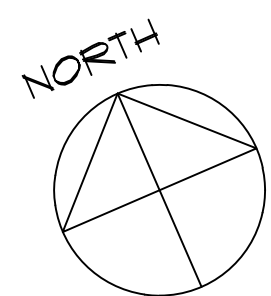

10' UTILITY EASEMENT  
 50' SERVITUDE OF PASSAGE

**DAMMON ENGINEERING, INC.**  
 LOUISIANA & MISSISSIPPI  
 Chief Engineer: Brian Mistich, PE  
 554 Old Spanish Trail  
 Slidell, LA 70458  
 www.dammonengineering.com  
 info@dammonengineering.com  
 PH: 985.649.5832

#	DESCRIPTION	DATE



NEW OFFICE BUILDING  
**TRUWEALTH LLC**  
 ADVISORS LLC  
 Dalwill Drive  
 Metairie, LA  
 JOB No: 2479 DATE: 5-11-2023  
 DRAWN BY: TT CHECKED BY: PFP

SHEET TITLE:  
 SITE UTILITY PLAN

DRAWING NUMBER:  
**C101**  
 SHEET No: